

SAMPLE DRAWINGS

SUBMITTAL 1

ORANGE AVE, NASHVILLE, TN

PROJECT:
SAMPLE DRAWINGS

PROJECT ADDRESS:
ORANGE AVE, NASHVILLE, TN

ARCHITECT:
FREDDY C.

G.C.:
PAOLO P.

	QCP	YES <input checked="" type="checkbox"/>	NO <input type="checkbox"/>
	LEED	YES <input type="checkbox"/>	NO <input checked="" type="checkbox"/>
	FSC	YES <input type="checkbox"/>	NO <input checked="" type="checkbox"/>
	NAUF	YES <input type="checkbox"/>	NO <input checked="" type="checkbox"/>

THESE SHOP DRAWINGS HAVE BEEN PREPARED USING THE CONTRACT DOCUMENTS LISTED BELOW:


DESCRIPTION	ISSUE DATE
PERMIT SET	N/A

SECTION	ITEM	AWS GRADE
-	-	CUSTOM


GENERAL NOTES:

DRAWING SYMBOLS:


Ref Plan Symbols:

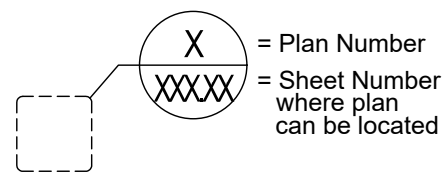

Plan Symbols:

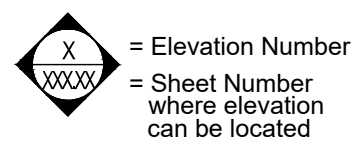


Section Symbols:

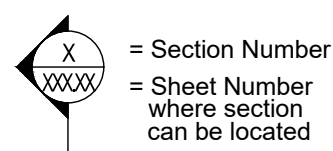

Elevation Symbols:

- ⊕ — CENTER LINE
- ∅ — DIAMETER
- 30" — IN WALL BLOCKING BY G.C.
- ↔ — GRAIN DIRECTION
- PL# — LAMINATE SYMBOL & NUMBER
- WD# — WOOD SYMBOL & NUMBER
- SS# — SOLID SURFACE SYMBOL & NUMBER
- ST# — STONE SYMBOL & NUMBER

 Layout View Symbols:



ARCHITECT:

DAVID F.
ADDRESS: -

CITY/STATE: -
PHONE: -
FAX: N/A
CONTACT: N/A
EMAIL: N/A
JOB #: 20168

G.C.:

MW
ADDRESS: N/A

CITY/STATE: N/A
PHONE: N/A
FAX: N/A
CONTACT: N/A
CELL: N/A
EMAIL: N/A

PM:	ERW
DRAWN BY:	TMS
DATE DRAWN:	02/10/2023
REVIEWED BY:	LCT (LOC)

REVISIONS:			
No.	DATE:	DESCRIPTIONS:	BY:
△	-	-	-
△	-	-	-
△	-	-	-
△	-	-	-
△	-	-	-
△	-	-	-
△	-	-	-
△	-	-	-

APPROVAL DATE	-
PLOT DATE	07/11/2024
PROJECT NUMBER	P-5567446
ROOM NAME	GENERAL INFO.
SHEET NUMBER	1CS.01


DEVIATION REPORT				
NO.	TMS REF.	ARCH REF.	EXPLANATION	RESPONSES FROM DESING PROFESSIONAL
01	103.01	A10 /12	34"H CABINET HEIGHTS ADJUSTED TO 33-3/4" TO MEET ADA STANDARDS, ALLOWING FOR LEVELING AND SHIMS.	APPROVED BY G.C.
02	1CS.07	N/A	REVEAL OVERLAY, WITH 5/16" REVEALS AT HINGE SIDE OF DOORS, AND HINGES ARE NOT NOTCHED INTO DOORS IN LIEU OF FLUSH OVERLAY.	
03	PAGE#	PAGE#	EXPLANATION	RESPONSES
04	PAGE#	PAGE#	EXPLANATION	RESPONSES
05	PAGE#	PAGE#	EXPLANATION	RESPONSES
06	PAGE#	PAGE#	EXPLANATION	RESPONSES
07	PAGE#	PAGE#	EXPLANATION	RESPONSES
08	PAGE#	PAGE#	EXPLANATION	RESPONSES
09	PAGE#	PAGE#	EXPLANATION	RESPONSES
10	PAGE#	PAGE#	EXPLANATION	RESPONSES

PROJECT:
SAMPLE DRAWINGS

PROJECT ADDRESS:
ORANGE AVE, NASHVILLE.
TN

ARCHITECT:
FREDDY C.

G.C.:
PAOLO P.

	QCP	YES <input checked="" type="checkbox"/>	NO <input type="checkbox"/>
	LEED	YES <input type="checkbox"/>	NO <input checked="" type="checkbox"/>
	FSC	YES <input type="checkbox"/>	NO <input checked="" type="checkbox"/>
	NAUF	YES <input type="checkbox"/>	NO <input checked="" type="checkbox"/>

FINISHES:

RFI'S / CLARIFICATION				
NO.	TMS REF.	ARCH REF.	QUESTION	G.C. / ARCHITECTS COMMENTS
01	03/105.03	A2/A608	PLEASE PROVIDE P-2 AND P-2X SPECIFICATIONS	IN THE APPROVED ADDENDUM G.C. WILL PROVIDE SPECS.
02	02/105.02	A2/A608	PLEASE PROVIDE EQUIPMENT SPECIFICATIONS.	USE THE SAME EQUIPMENT SPECS OF THE WORKING ROOM A108
03	03/102.02	A11/A605	PLEASE PROVIDE WD2 SPECIFICATIONS	WHITE OAK. PROFILE T3T8 RUBIO MONOCOAR
04	09/105.05	A8/A608	PLEASE PROVIDE EQ05, EQ06 AND EQ07 SPECIFICATIONS.	IN THE APPROVED ADDENDUM G.C. WILL PROVIDE SPECS.
05	PAGE#	PAGE#	QUESTION	COMMENT
06	PAGE#	PAGE#	QUESTION	COMMENT
07	PAGE#	PAGE#	QUESTION	COMMENT
08	PAGE#	PAGE#	QUESTION	COMMENT
09	PAGE#	PAGE#	QUESTION	COMMENT
10	PAGE#	PAGE#	QUESTION	COMMENT

PM:	ERW
DRAWN BY:	TMS
DATE DRAWN:	02/10/2023
REVIEWED BY:	LCT (LOC)

REVISIONS:			
No.	DATE:	DESCRIPTIONS:	BY:
△	-	-	-
△	-	-	-
△	-	-	-
△	-	-	-
△	-	-	-
△	-	-	-
△	-	-	-
△	-	-	-

APPROVAL DATE	-
PLOT DATE	07/11/2024
PROJECT NUMBER	P-5567446
ROOM NAME	DEVIATION - RFI
SHEET NUMBER	1CS.02

SHEET INDEX:



678 Orange Ave Orlando, FL 32804
www.themillworkstudio.com

PROJECT:
SAMPLE DRAWINGS

PROJECT ADDRESS:
ORANGE AVE, NASHVILLE, TN

ARCHITECT:
FREDDY C.

G.C.:
PAOLO P.

	QCP	YES <input checked="" type="checkbox"/>	NO <input type="checkbox"/>
	LEED	YES <input type="checkbox"/>	NO <input checked="" type="checkbox"/>
	FSC	YES <input type="checkbox"/>	NO <input checked="" type="checkbox"/>
	NAUF	YES <input type="checkbox"/>	NO <input checked="" type="checkbox"/>

FINISHES:

PM:	ERW
DRAWN BY:	TMS
DATE DRAWN:	02/10/2023
REVIEWED BY:	LCT (LOC)

REVISIONS:

No.	DATE:	DESCRIPTIONS:	BY:
△	-	-	-
△	-	-	-
△	-	-	-
△	-	-	-
△	-	-	-
△	-	-	-
△	-	-	-
△	-	-	-

APPROVAL DATE	-
PLOT DATE	07/11/2024
PROJECT NUMBER	P-5567446
ROOM NAME	INDEX
SHEET NUMBER	1CS.03

SHEET LIST TABLE	
SHEET NUMBER	SHEET TITTLE
GENERAL INFO.	
1CS.01	COVER
1CS.02	DEVIATION - RFI
1CS.03	INDEX
1CS.04	MATERIAL
1CS.05	FINISH SPECS
1CS.06	TYP. CONSTRUCTION
1CS.07	TYP. DETAIL
1CS.08	HW SPECS
REF. PLANS	
1RP.01	OVERALL PLAN
1RP.02	ENLARGE PLAN
1RP.03	ENLARGE PLAN
LOUNGE - BANQUETTE A103	
101.01	PLAN & ELEVATION
101.02	ELEVATION
101.03	SECTION
101.04	SECTION
LOBBY A105	
102.01	PLAN & ELEVATION
102.02	ELEVATION
102.03	SECTION
102.04	SECTION
102.05	SECTION

RESTROOMS A402	
103.01	PLAN & ELEVATION
103.02	SECTION
WORKING ROOM A108	
104.01	PLAN
104.02	ELEVATION
104.03	SECTION
104.04	SECTION
104.05	SECTION
BREAK ROOM	
105.01	PLAN
105.02	ELEVATION
105.03	ELEVATION
105.04	ELEVATION
105.05	SECTION
105.06	SECTION
105.07	SECTION
105.08	SECTION
105.09	SECTION
105.10	SECTION
105.11	SECTION
105.12	SECTION
105.13	SECTION
105.14	SECTION

PROJECT:
SAMPLE DRAWINGS

PROJECT ADDRESS:
ORANGE AVE, NASHVILLE, TN

ARCHITECT:
FREDDY C.

G.C.:
PAOLO P.

	QCP	YES <input checked="" type="checkbox"/>	NO <input type="checkbox"/>
	LEED	YES <input type="checkbox"/>	NO <input checked="" type="checkbox"/>
	FSC	YES <input type="checkbox"/>	NO <input checked="" type="checkbox"/>
	NAUF	YES <input type="checkbox"/>	NO <input checked="" type="checkbox"/>

FINISHES:

PM:	ERW
DRAWN BY:	TMS
DATE DRAWN:	02/10/2023
REVIEWED BY:	LCT (LOC)

REVISIONS:

No.	DATE:	DESCRIPTIONS:	BY:
△	-	-	-
△	-	-	-
△	-	-	-
△	-	-	-
△	-	-	-
△	-	-	-
△	-	-	-
△	-	-	-

APPROVAL DATE	-
PLOT DATE	07/11/2024
PROJECT NUMBER	P-5567446
ROOM NAME	MATERIAL SPECS.
SHEET NUMBER	1CS.04

P-LAM CABINET MATERIAL	
DESCRIPTION	SPECIFICATION
SEMI EXPOSED CASE BODY	3/4" WHITE MELAMINE w/ PARTICLEBOARD CORE
EXPOSED CASE BODY	11/16" PARTICLEBOARD CORE w/ .028 (VGP) LAMINATE ON EXPOSED SURFACES
SEMI EXPOSED BACKS	1/4" WHITE MELAMINE w/ MEDIUM DENSITY FIBERBOARD CORE
EXPOSED BACKS	1/4" MDF CORE w/ .028 (VGP) LAMINATE ON EXPOSED FACE
DOOR & DRAWER FRONTS	11/16" PARTICLEBOARD CORE w/ .028 (VGP) LAMINATE ON EXPOSED FACE & .020 WHITE LINER FOR BALANCE
DRAWER BOX	3/4" WHITE MELAMINE w/ PARTICLEBOARD CORE - DOWEL CONSTRUCTION
DRAWER BOX BOTTOMS	1/4" WHITE MELAMINE w/ MDF CORE (1/2" IF OVER 36" WIDE)
SEMI EXPOSED SHELVES	3/4" WHITE MELAMINE w/ PARTICLEBOARD CORE (1" IF OVER 30")
EXPOSED SHELVES	3/4" PARTICLEBOARD CORE w/ .028 (VGP) LAMINATE ON EXPOSED SURFACES (1" IF OVER 35")
TOEKICK	3/4" x4 EXTERIOR GRADE PLYWOOD - CONTINUOUS RUN LADDER STYLE
CONSTRUCTION METHOD	FRAMELESS CONSTRUCTION, FLUSH OVERLAY DOORS / DRAWER FRONTS, DOWEL JOINERY
WALL SHELVES	3/4" PARTICLEBOARD CORE w/ .028 (VGP) LAMINATE

P-LAM EDGE BANDING TREATMENT	
DESCRIPTION	SPECIFICATION
CASE BODY EDGE	3mm HIGH IMPACT PVC EDGE BANDING COLOR: TO MATCH DOOR & DRAWER FRONTS
OPEN CASE BODY EDGE	3mm HIGH IMPACT PVC EDGE BANDING COLOR: TO MATCH EXPOSED SURFACES
DOOR & DRAWER FRONT EDGE	3mm HIGH IMPACT PVC EDGE BANDING COLOR: TO MATCH DOOR & DRAWER FRONTS
DRAWER BOX EDGE	0.5mm HIGH IMPACT PVC EDGE BANDING COLOR: TO MATCH DRAWER BOX
SEMI EXPOSED SHELF EDGE	3mm HIGH IMPACT PVC EDGE BANDING ON FRONT EDGE COLOR: TO MATCH DOOR & DRAWER FRONTS
EXPOSED SHELF EDGE	3mm HIGH IMPACT PVC EDGE BANDING ON FRONT EDGE COLOR: TO MATCH DOOR & DRAWER FRONTS
WALL SHELF EDGE	3mm HIGH IMPACT PVC EDGE BANDING ON ALL SIDES COLOR: TO MATCH SHELF

VENEER CABINETS MATERIALS	
DESCRIPTION	SPECIFICATION
SEMI EXPOSED CASE BODY	3/4" VENEER CORE PLYWOOD
EXPOSED CASE BODY	3/4" VENEER CORE PLYWOOD
EXPOSED BACKS	1/4" VENEER CORE PLYWOOD
EXPOSED BACKS	1/4" VENEER CORE PLYWOOD
DOOR & DRAWER FRONTS	3/4" VENEER CORE PLYWOOD w/ VENEER ON BOTH FACES
DRAWER BOX	3/4" VENEER CORE PLYWOOD w/ WHITE LAMINATE - DOWEL CONSTRUCTION
DRAWER BOX BOTTOMS	1/4" WHITE MELAMINE w/ MDF CORE (1/2" IF OVER 36" WIDE)
SEMI EXPOSED SHELVES	3/4" VENEER CORE PLYWOOD (1" IF OVER 35")
EXPOSED SHELVES	3/4" VENEER CORE PLYWOOD (1" IF OVER 35")
TOEKICK	3/4" x4 EXTERIOR GRADE PLYWOOD - CONTINUOUS RUN LADDER STYLE
CONSTRUCTION METHOD	FRAMELESS CONSTRUCTION, FLUSH OVERLAY DOORS / DRAWER FRONTS, DOWEL JOINERY
WALL SHELVES	3/4" PARTICLEBOARD CORE w/ VENEER

VENEER EDGE BANDING TREATMENT	
DESCRIPTION	SPECIFICATION
CASE BODY EDGE	3mm VENEER EDGE BANDING COLOR: TO MATCH DOOR & DRAWER FRONTS
OPEN CASE BODY EDGE	3mm VENEER EDGE BANDING COLOR: TO MATCH EXPOSED SURFACES
DOOR & DRAWER FRONT EDGE	3mm VENEER EDGE BANDING COLOR: TO MATCH DOOR & DRAWER FRONTS
DRAWER BOX EDGE	0.5mm VENEER EDGE BANDING COLOR: TO MATCH DRAWER BOX
SEMI EXPOSED SHELF EDGE	0.5mm VENEER EDGE BANDING ON FRONT EDGE COLOR: TO MATCH CABINET INTERIOR
EXPOSED SHELF EDGE	3mm VENEER EDGE BANDING ON FRONT EDGE COLOR: TO MATCH DOOR & DRAWER FRONTS
WALL SHELF EDGE	3mm VENEER EDGE BANDING ON ALL SIDES COLOR: TO MATCH SHELF

WALL PANEL MATERIAL	
DESCRIPTION	SPECIFICATION
WALL PANELS	3/4" MDF CORE w/ VENEER FACE AND BACKER

WALL PANEL EDGE BANDING TREATMENT	
DESCRIPTION	SPECIFICATION
WALL PANEL EDGE	0.5mm VENEER EDGE BANDING ON ALL SIDES COLOR: TO MATCH PANEL

C'TOP MATERIALS	
DESCRIPTION	SPECIFICATION
QUARTZ TOPS	3CM (1 3/16") QUARTZ SLAB GLUED TO CASEWORK TOPS
QUARTZ BACKSPLASH	LOOSE - 2CM (3/4") QUARTZ FOR FIELD APPLICATION
PORCELAIN TOPS (PC1)	12MM PORCELAIN C'TOP SLAB, ON 3/4" MOISTURE RESISTANT MDF
STONE (ST1)	12MM STONE SLAB APPLIED TO EXISTING SUBSTRATE - WALL

*PER AWI DOOR, DRAWER FRONTS, AND FALSE FRONTS SHALL RUN AND MATCH VERTICALLY WITHIN EACH CABINET

GRAIN DIRECTIONS:

DRAWER FRONTS - VERTICAL
DOORS - VERTICAL
APRON / TABLE FRAMES - HORIZONTAL
END PANELS - VERTICAL
KNEE SPACE PANELS - VERTICAL
WALL PANELS - VERTICAL

PLASTIC LAMINATE			GRAIN	EDGE FINISH
KEY	COLOR			
PL1	CARBON, TRUMATTE, BLACK		NO	TO MATCH PL1
PL2	WILSONART - WALNUT HEIGHT, 7965K-12K		YES	TO MATCH PL2
VENEER			GRAIN	EDGE FINISH
KEY	COLOR			
WD1	VENEER TO MATCH PL2		YES	TO MATCH WD1
WD2	WHITE OAK. PROFILE T3T8 RUBIO MONOCOAR		YES	TO MATCH WD2
WD3	SOLID WALLNUT		YES	TO MATCH WD3
STONE			GRAIN	EDGE FINISH
KEY	COLOR			
ST1	CAESARSTONE 5121 LAYATILE		YES	TO MATCH ST1
INTERIOR FINISHES			GRAIN	EDGE FINISH
KEY	COLOR			
MEL1	WHITE MELAMINE		NO	TO MATCH MEL1
MEL2	BLACK MELAMINE		NO	TO MATCH MEL2

EQUIPMENT SCHEDULE			
KEY	EQUIPMENT ITEM	MANUFACTURER- MODEL	SIZE
EQ01	ICE MACHINE (BY OTHERS)	HOSHIZAKI - AM-50BAJ	33 1/2"H x 14 3/4"W x 22 3/4"H
EQ02	DISWASHER (BY OTHERS)	GE APPLIANCES - GDT225SSLSS	32 1/4"H x 23 3/4"W x 23 1/2"D
EQ03	U.C. MICROWAVE (BY OTHERS)	MONOGRAM- ZWL1126SJSS	15"H x 23 7/8"W x 23 1/8"D
EQ04	REFRIGERATOR (BY OTHERS)	MONOGRAM - ZIS480NNII	84"H x 48"W x 25 3/4"D
EQ05	TBD	TBD	TBD
EQ06	TBD	TBD	TBD
EQ07	TBD	TBD	TBD

PLUMBING SCHEDULE			
KEY	EQUIPMENT ITEM	MANUFACTURER- MODEL	SIZE
L-2	MOUNTED SINK (BY OTHERS)	KOHLER K-2882	13" x 17 1/4" x 3"
L-2X	FAUCET	KOHLER K-73168-5-CP	7 1/8"
S-2	SINGLE SINK UNDERMOUNT	MOEN - G18180	31" X 18"
S-2X	FAUCET	KOLHLER K- 596-BL	-
P-2	MOUNTED SINK (BY OTHERS)	TBD	TBD
P-2X	FAUCET	TBD	TBD

HARDWARE SCHEDULE			
KEY	HARDWARE ITEM	MANUFACTURER- MODEL	FINISH
HW01	DOOR / DRAWER PULL	HAFELE - 4" CENTERS WIRE PULL	BRUSHED CHROME
HW02	DOOR HINGE	BLUM - 110° SELF CLOSING	NICKEL
HW03	HINGE BASE PLATE	BLUM - 0MM EXPANDO CAMMOUNTING	NICKEL
HW04	CABINET SHELF SUPPORT	RICHELIEU - CP5834180 5mm	NICKEL
HW05	DRAWER SLIDE	BLUM - STANDARD 230M SELF CLOSING	NICKEL
HW06	TOUCH LATCH SYSTEM	RICHELIEU - NON-MAGNETIC 7502190	BLACK
HW07	KEKU CLIP	HAFELE - KEKU 26250358	BLACK
HW08	CONCEALED SHELF SUPPORT	A&M -CONCEALED FLAT C-12	WHITE
HW09	CONCEALED COUNTER SUPPORT	A&M - CONCEALED C-21	WHITE

**** NOTE TO ARCH AND G.C. ****
REFERENCE RFI LIST ON SHEET 1CS.02

PLEASE PROVIDE EQ05, EQ06 AND EQ07 SPECIFICATIONS.

**** NOTE TO ARCH AND G.C. ****
REFERENCE RFI LIST ON SHEET 1CS.02


PLEASE PROVIDE P-2 AND P-2X SPECIFICATIONS.

PROJECT:
SAMPLE DRAWINGS

PROJECT ADDRESS:
ORANGE AVE, NASHVILLE.
TN

ARCHITECT:
FREDDY C.

G.C.:
PAOLO P.

	QCP	YES <input checked="" type="checkbox"/>	NO <input type="checkbox"/>
	LEED	YES <input type="checkbox"/>	NO <input checked="" type="checkbox"/>
	FSC	YES <input type="checkbox"/>	NO <input checked="" type="checkbox"/>
	NAUF	YES <input type="checkbox"/>	NO <input checked="" type="checkbox"/>

FINISHES:

PM:	ERW
DRAWN BY:	TMS
DATE DRAWN:	02/10/2023
REVIEWED BY:	LCT (LOC)

REVISIONS:			
No.	DATE:	DESCRIPTIONS:	BY:
△	-	-	-
△	-	-	-
△	-	-	-
△	-	-	-
△	-	-	-
△	-	-	-
△	-	-	-
△	-	-	-

APPROVAL DATE	-
PLOT DATE	07/11/2024
PROJECT NUMBER	P-5567446
ROOM NAME	FINISH SPECS.
SHEET NUMBER	1CS.05

PROJECT:
SAMPLE DRAWINGS

PROJECT ADDRESS:
ORANGE AVE, NASHVILLE, TN

ARCHITECT:
FREDDY C.

G.C.:
PAOLO P.

	QCP	YES <input checked="" type="checkbox"/>	NO <input type="checkbox"/>
	LEED	YES <input type="checkbox"/>	NO <input checked="" type="checkbox"/>
	FSC	YES <input type="checkbox"/>	NO <input checked="" type="checkbox"/>
	NAUF	YES <input type="checkbox"/>	NO <input checked="" type="checkbox"/>


FINISHES:

PM:	ERW
DRAWN BY:	TMS
DATE DRAWN:	02/10/2023
REVIEWED BY:	LCT (LOC)

REVISIONS:

No.	DATE:	DESCRIPTIONS:	BY:
△	-	-	-
△	-	-	-
△	-	-	-
△	-	-	-
△	-	-	-
△	-	-	-
△	-	-	-
△	-	-	-

APPROVAL DATE	-
PLOT DATE	07/11/2024
PROJECT NUMBER	P-5567446
ROOM NAME	TYP. CONSTRUCTION
SHEET NUMBER	1CS.06

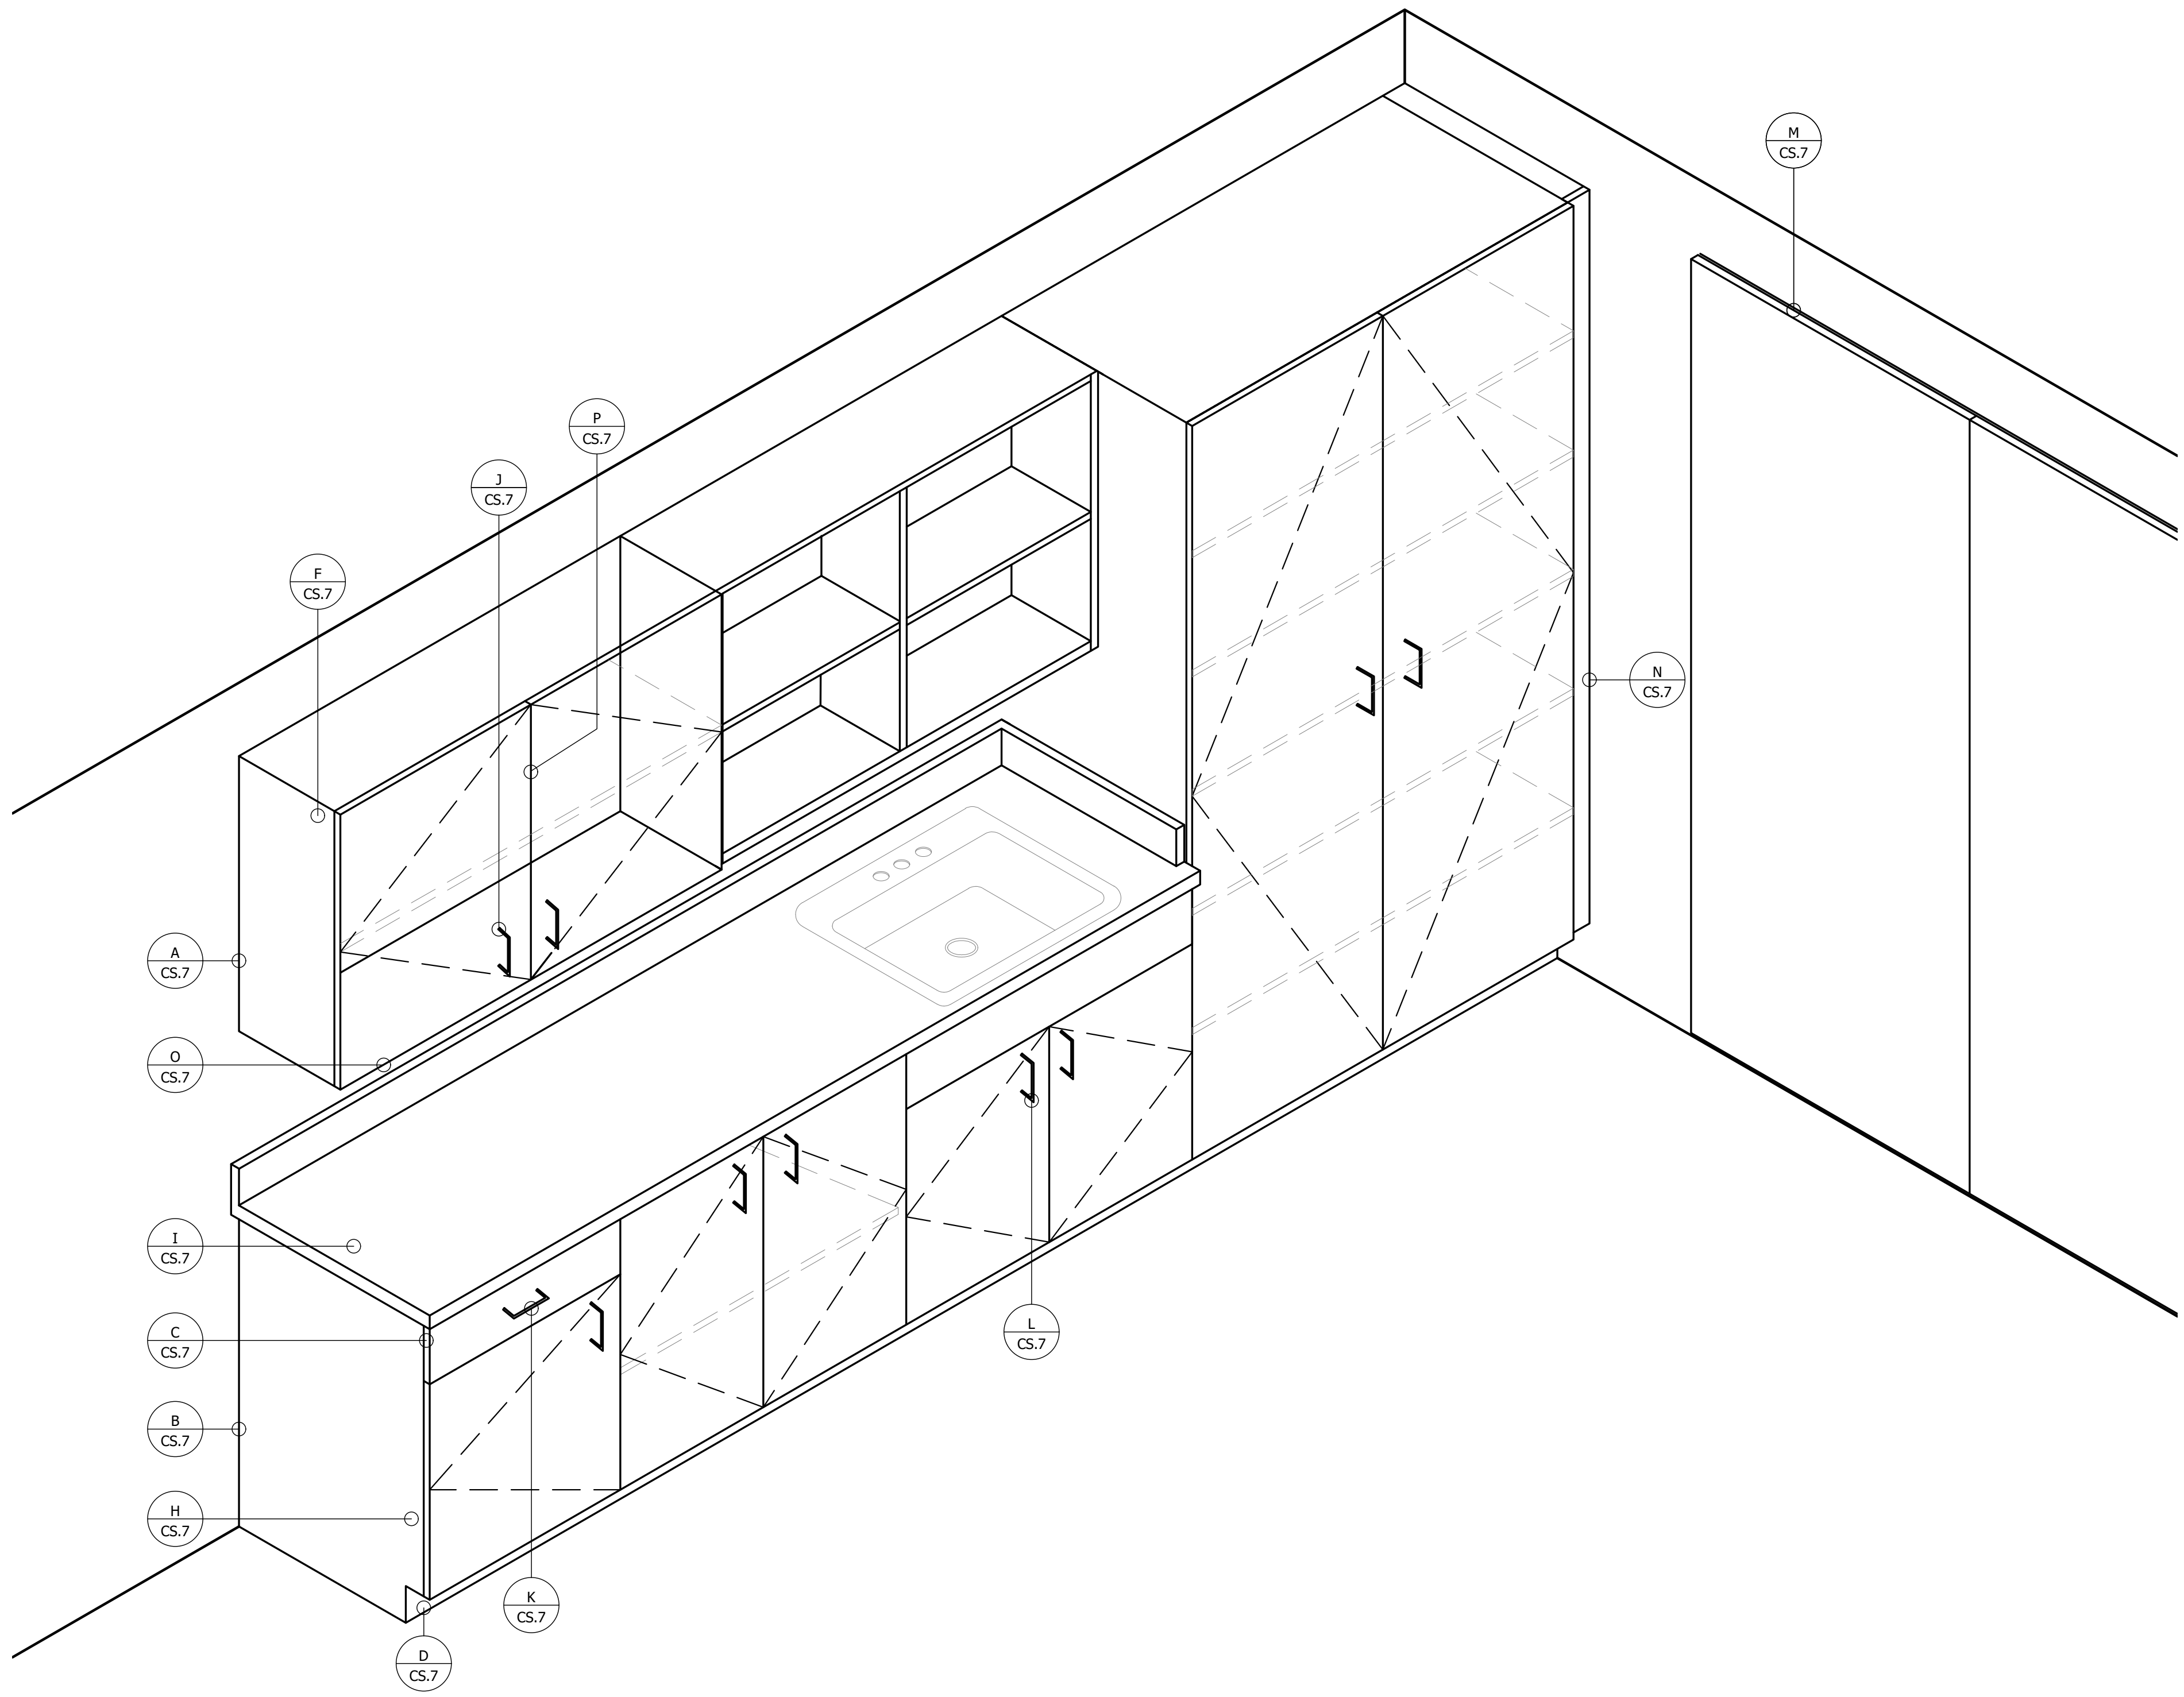

01 TYPICAL CONSTRUCTION AXONOMETRIC
AXONOMETRIC
SCALE: ARCH REF.:

PROJECT:
SAMPLE DRAWINGS

PROJECT ADDRESS:
ORANGE AVE, NASHVILLE, TN

ARCHITECT:
FREDDY C.

G.C.:
PAOLO P.

	QCP	YES <input checked="" type="checkbox"/>	NO <input type="checkbox"/>
	LEED	YES <input type="checkbox"/>	NO <input checked="" type="checkbox"/>
	FSC	YES <input type="checkbox"/>	NO <input checked="" type="checkbox"/>
	NAUF	YES <input type="checkbox"/>	NO <input checked="" type="checkbox"/>


FINISHES:

PM:	ERW
DRAWN BY:	TMS
DATE DRAWN:	02/10/2023
REVIEWED BY:	LCT (LOC)


REVISIONS:

No.	DATE	DESCRIPTIONS	BY:
△	-	-	-
△	-	-	-
△	-	-	-
△	-	-	-
△	-	-	-
△	-	-	-
△	-	-	-


APPROVAL DATE	-
PLOT DATE	07/11/2024
PROJECT NUMBER	P-5567446
ROOM NAME	TYP. DETAILS
SHEET NUMBER	1CS.07

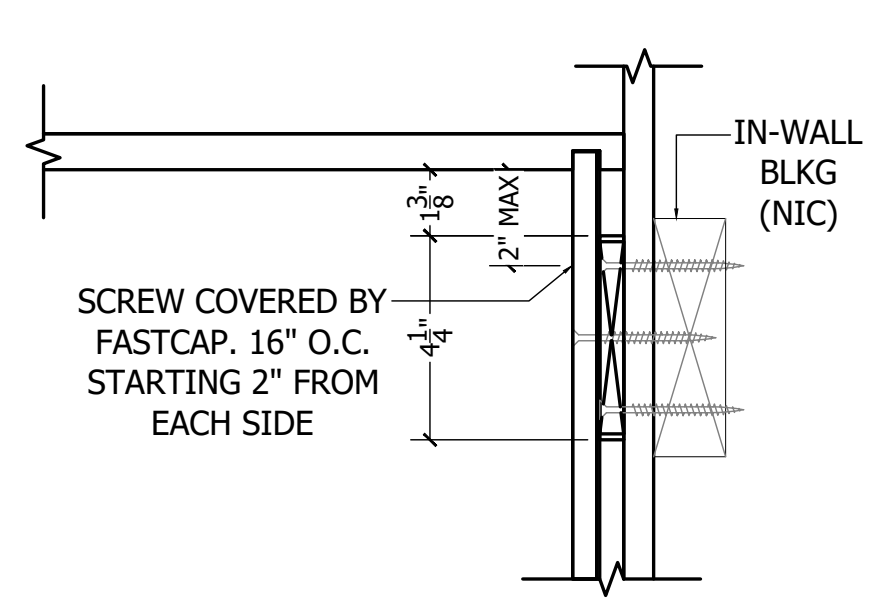


A UPPER ANCHORATE
DETAIL
SCALE: 3"=1'-0" ARCH REF.:

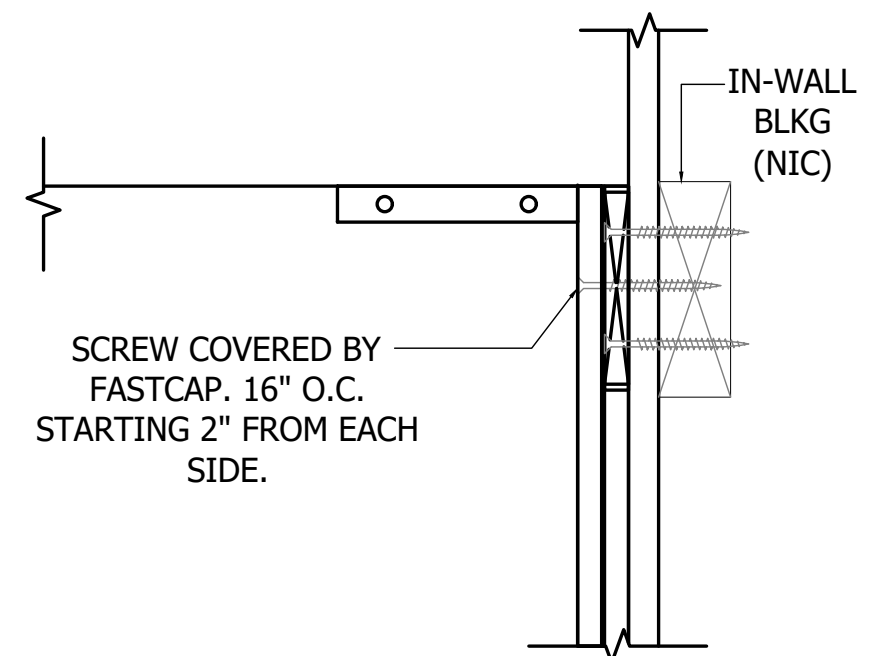


B BASE WALL ANCHORATE
DETAIL
SCALE: 3"=1'-0" ARCH REF.:

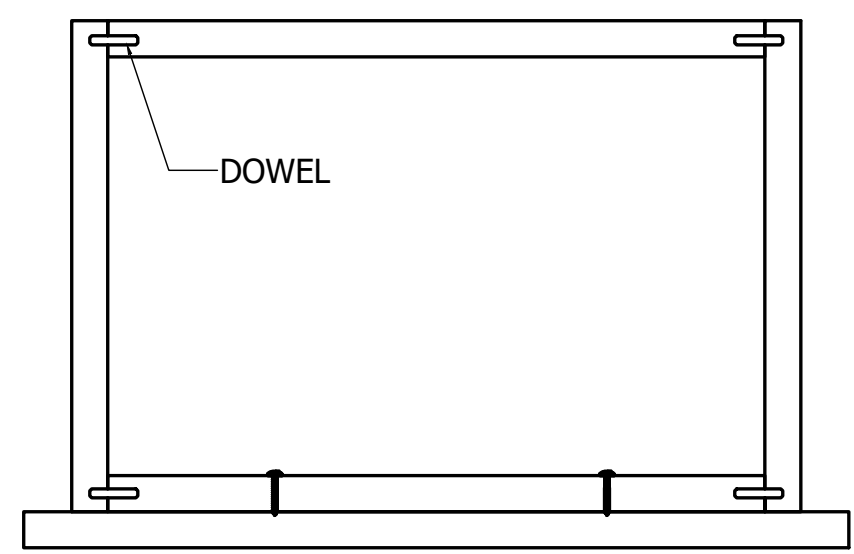


C DRAWER CONSTRUCTION
DETAIL
SCALE: 3"=1'-0" ARCH REF.:

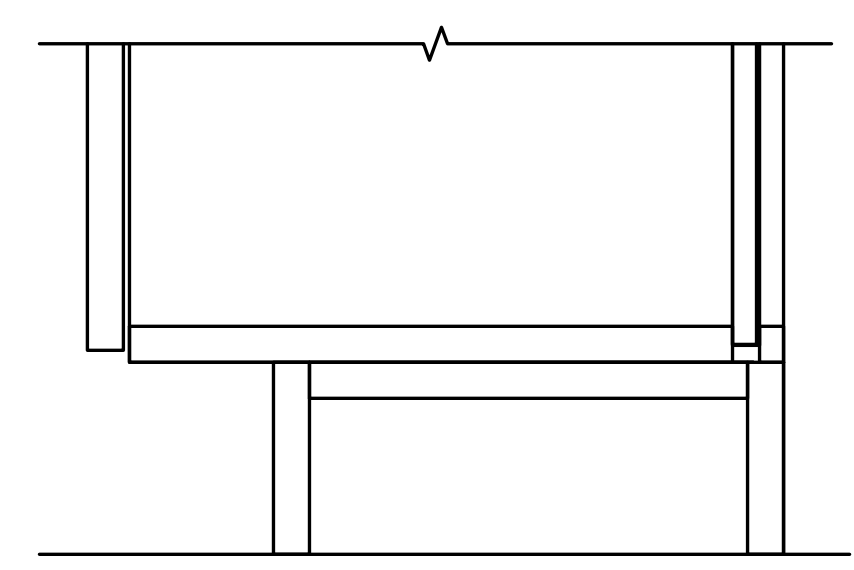


D TOEKICK CONSTRUCTION
DETAIL
SCALE: 3"=1'-0" ARCH REF.:

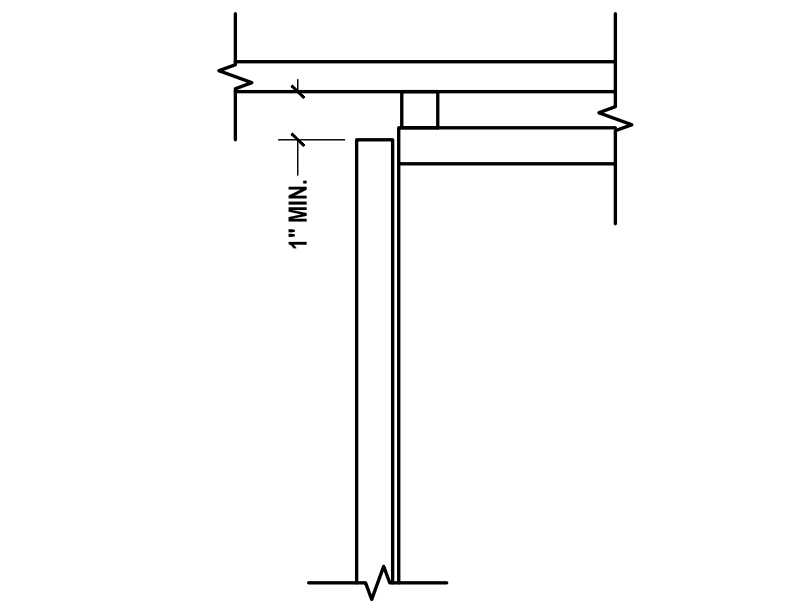


E CEILING FILLER
DETAIL
SCALE: 3"=1'-0" ARCH REF.:

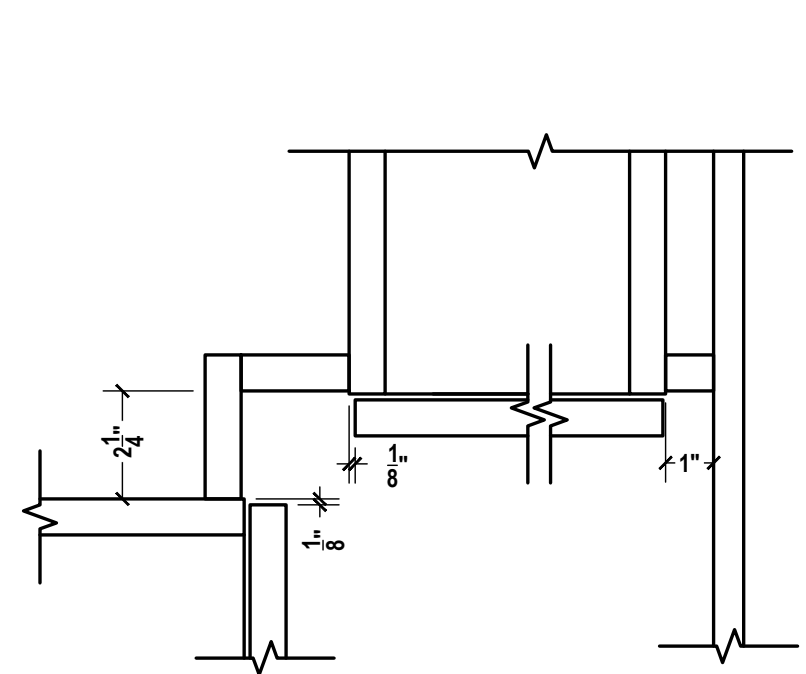


F UPPER FILLER
DETAIL
SCALE: 3"=1'-0" ARCH REF.:

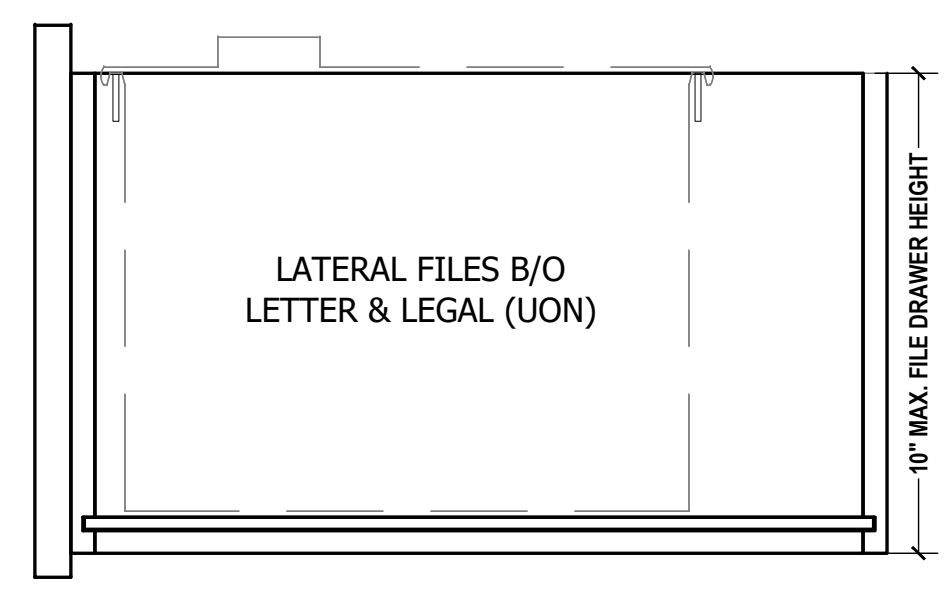


G FILE DRAWER DIMENSIONS
DETAIL
SCALE: 3"=1'-0" ARCH REF.:

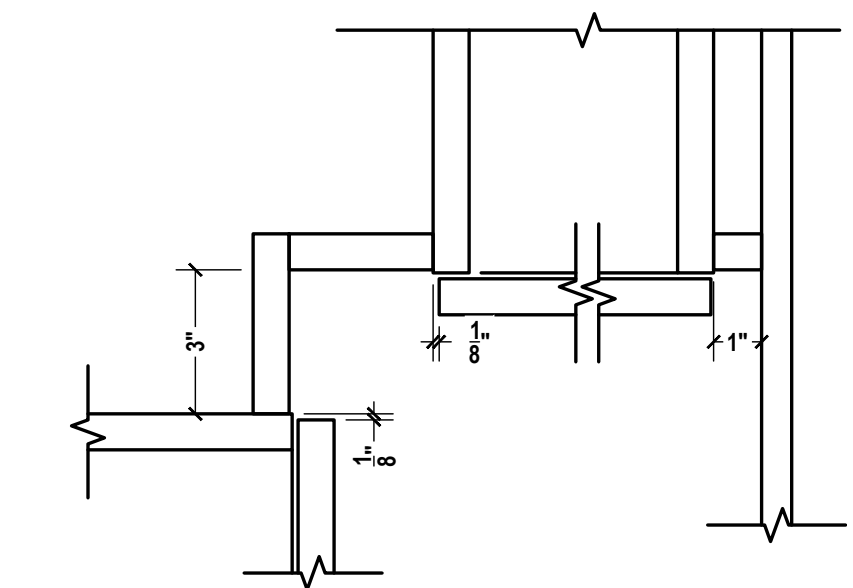


H BASE FILLER / REVEAL
DETAIL
SCALE: 3"=1'-0" ARCH REF.:

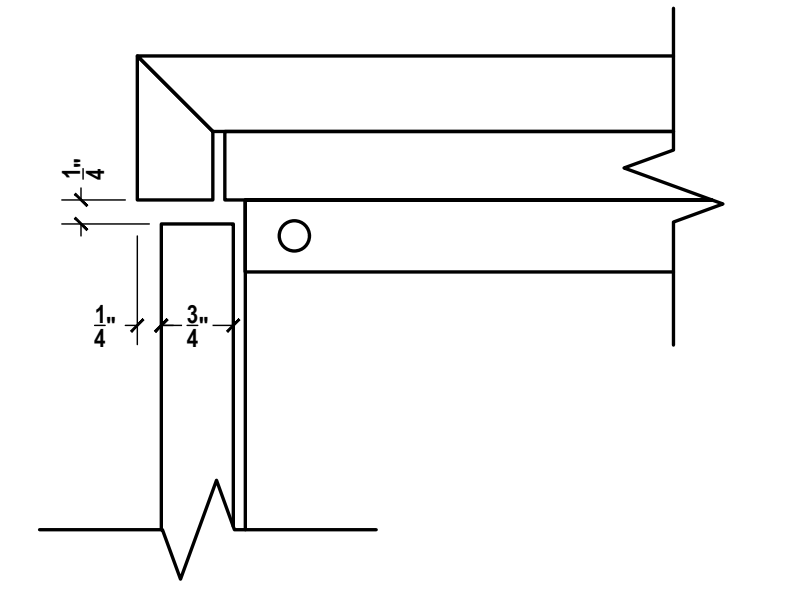


I C TOP
DETAIL
SCALE: 6"=1'-0" ARCH REF.:

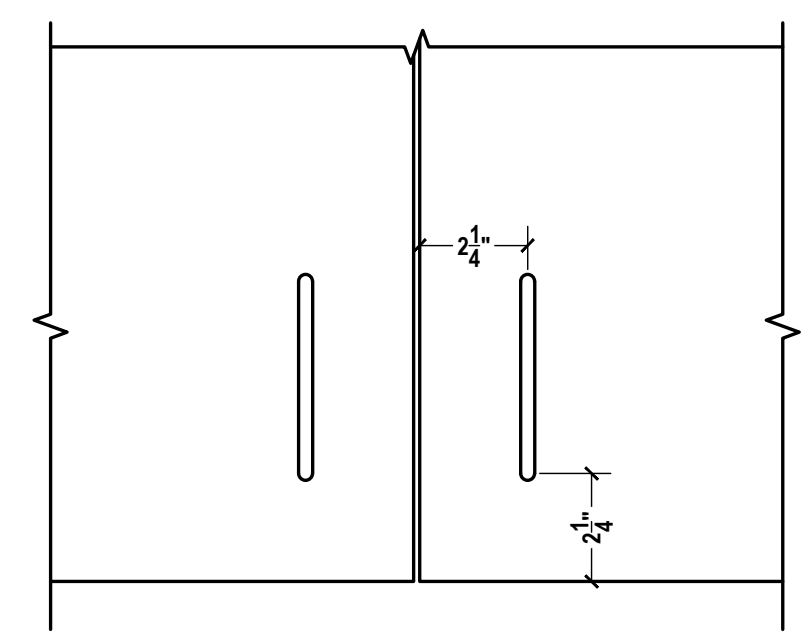


J UPPER DOOR PULL LOCATION
DETAIL
SCALE: 3"=1'-0" ARCH REF.:

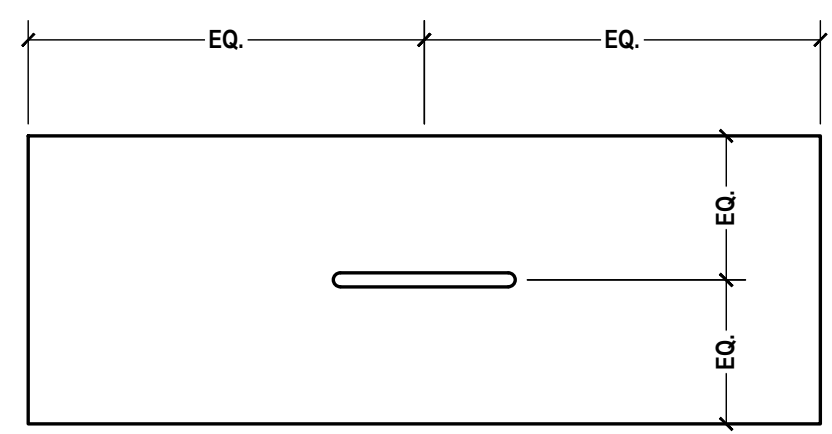


K DRAWER PULL LOCATION
DETAIL
SCALE: 3"=1'-0" ARCH REF.:

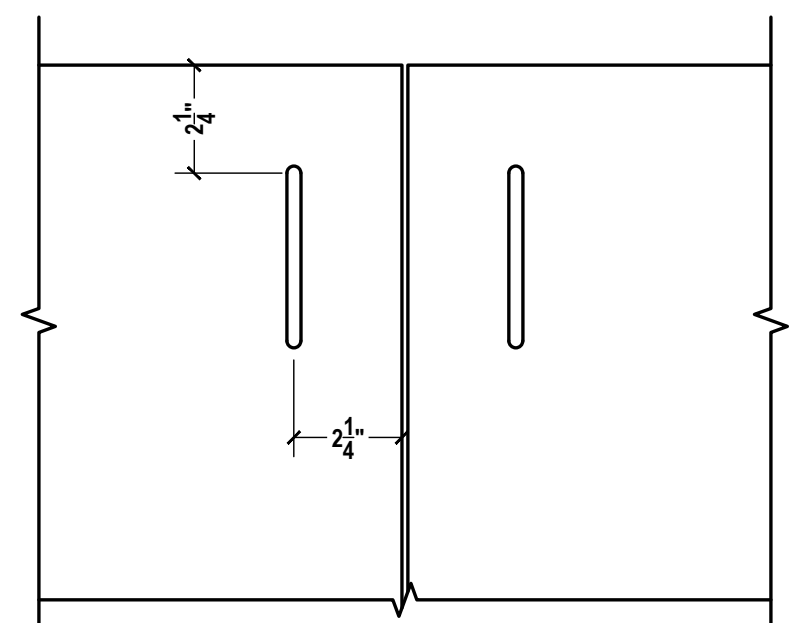


L BASE DOOR PULL LOCATION
DETAIL
SCALE: 3"=1'-0" ARCH REF.:

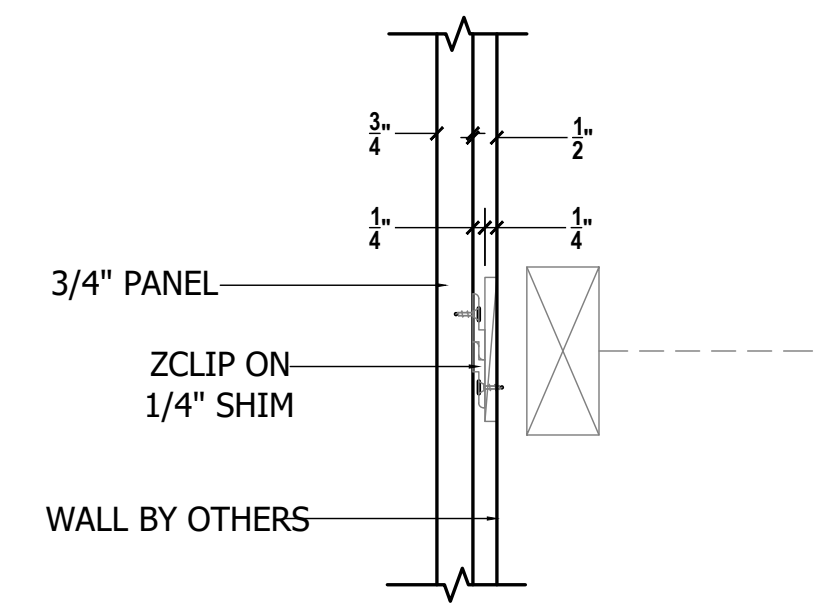


M WALL PANELING ANCHORAGE
DETAIL
SCALE: 3"=1'-0" ARCH REF.:

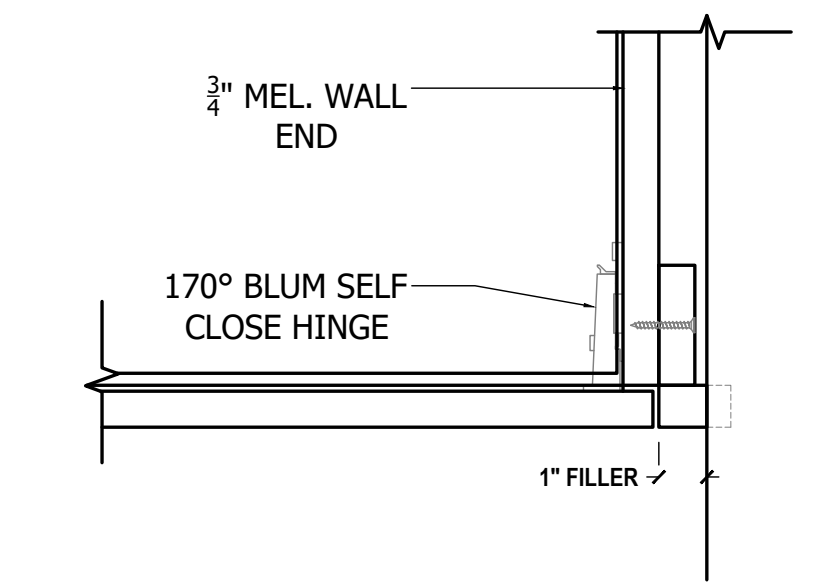

N FILLER AT WALL
DETAIL
SCALE: 3"=1'-0" ARCH REF.:

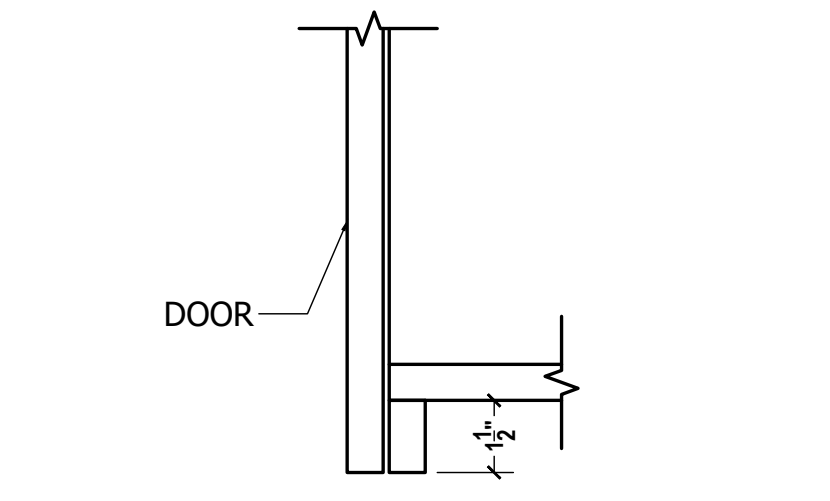

O UPPER VALANCE
DETAIL
SCALE: 3"=1'-0" ARCH REF.:

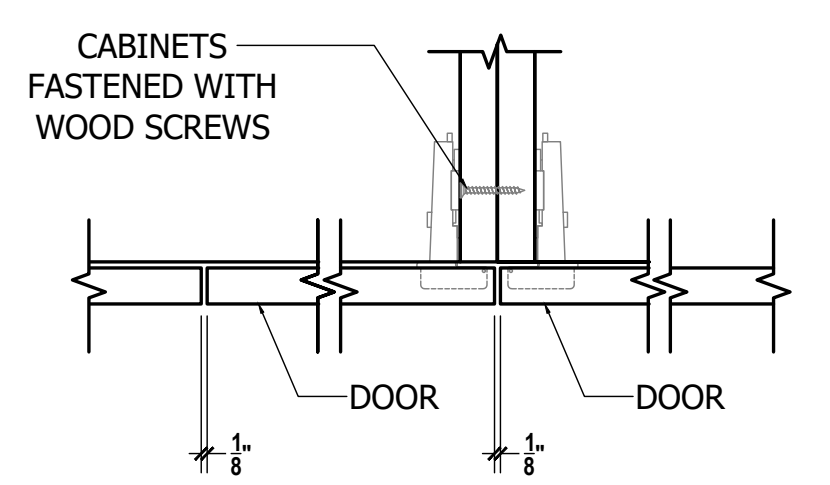

P DOOR GAP
DETAIL
SCALE: 3"=1'-0" ARCH REF.:

HARDWARE SPECIFICATIONS:



678 Orange Ave Orlando, FL 32804
www.themillworkstudio.com

PROJECT:
SAMPLE DRAWINGS

PROJECT ADDRESS:
ORANGE AVE, NASHVILLE, TN

ARCHITECT:
FREDDY C.

G.C.:
PAOLO P.

	QCP	YES <input checked="" type="checkbox"/>	NO <input type="checkbox"/>
	LEED	YES <input type="checkbox"/>	NO <input checked="" type="checkbox"/>
	FSC	YES <input type="checkbox"/>	NO <input checked="" type="checkbox"/>
	NAUF	YES <input type="checkbox"/>	NO <input checked="" type="checkbox"/>

FINISHES:


PM:	ERW
DRAWN BY:	TMS
DATE DRAWN:	02/10/2023
REVIEWED BY:	LCT (LOC)

REVISIONS:			
No.	DATE:	DESCRIPTIONS:	BY:
△	-	-	-
△	-	-	-
△	-	-	-
△	-	-	-
△	-	-	-
△	-	-	-
△	-	-	-

APPROVAL DATE	-
PLOT DATE	07/11/2024
PROJECT NUMBER	P-5567446
ROOM NAME	HARDWARE SPECS
SHEET NUMBER	1CS.08


HW01

Comerstone Collection
4" Centers Wire Pull in Satin/Brushed Chrome
by Hafele

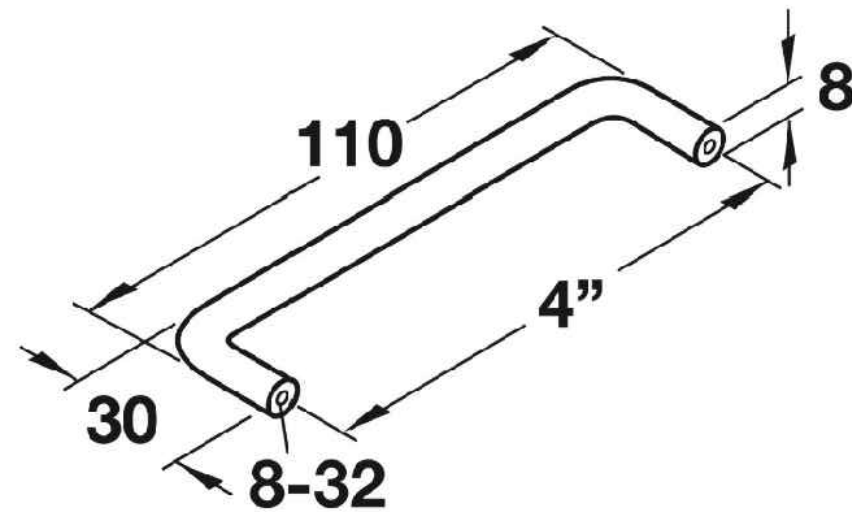


HW02 & HW3

blum 110° standard hinges

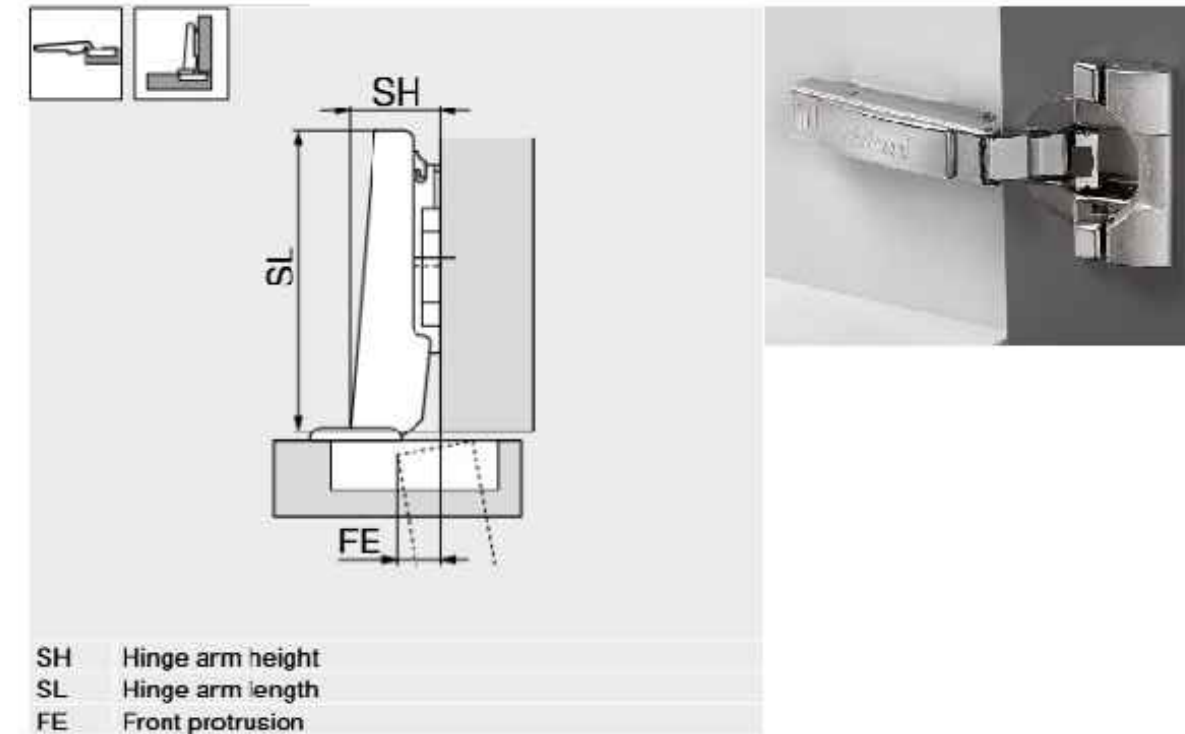


HW05

blum STANDARD 22" 230M Drawer Runner

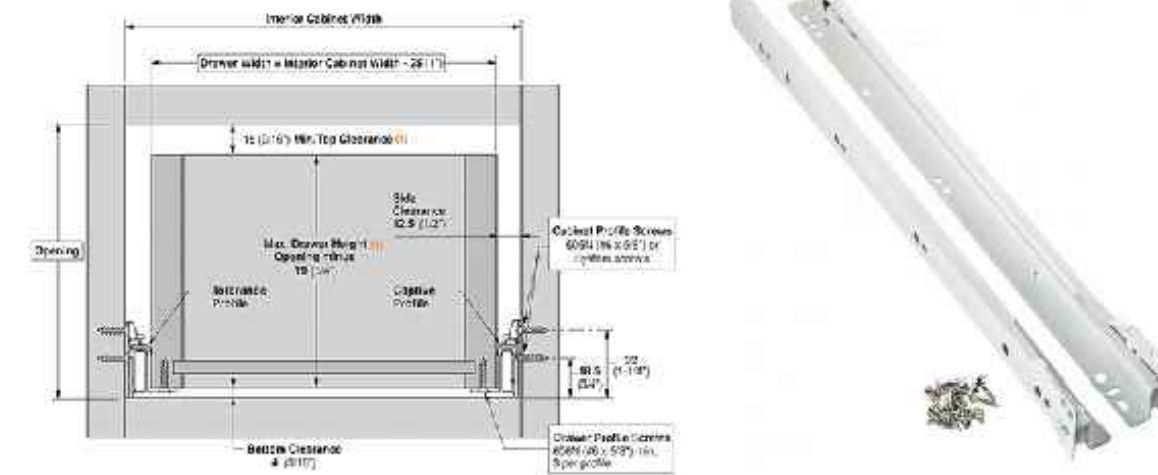

HW07

HAFELE KEKU AS

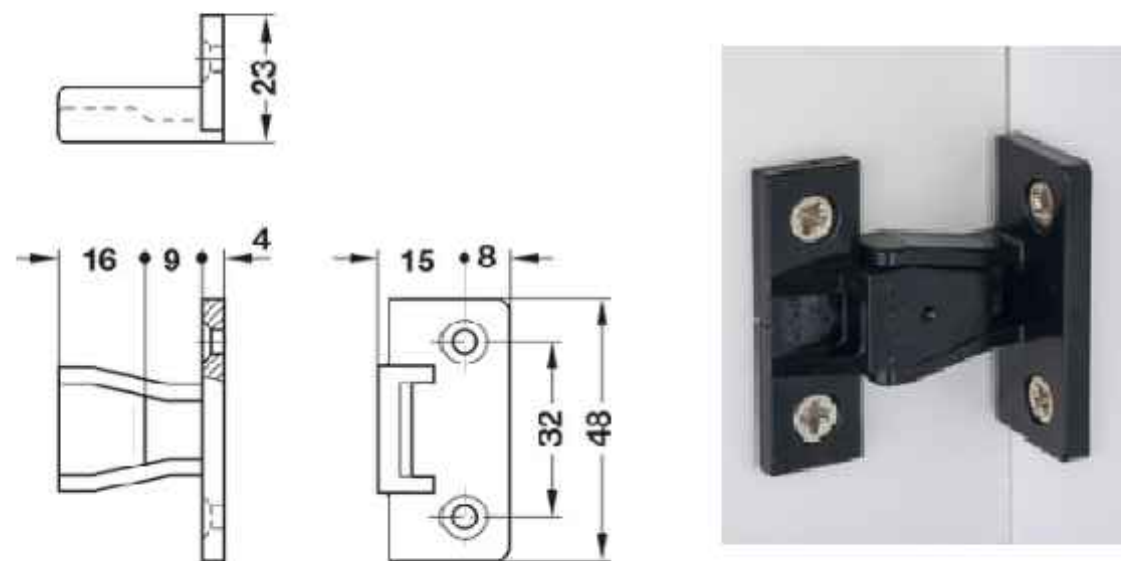

HW04

Richelieu Shelf -Support
Product # CP5834180 Finish: Nickel




HW06

Richelieu Non-Magnetic Touch Latch PR21
Product # 7502190




HW08

A&M HARDWARE, INC. 2.0" Concealed Flat Brackets

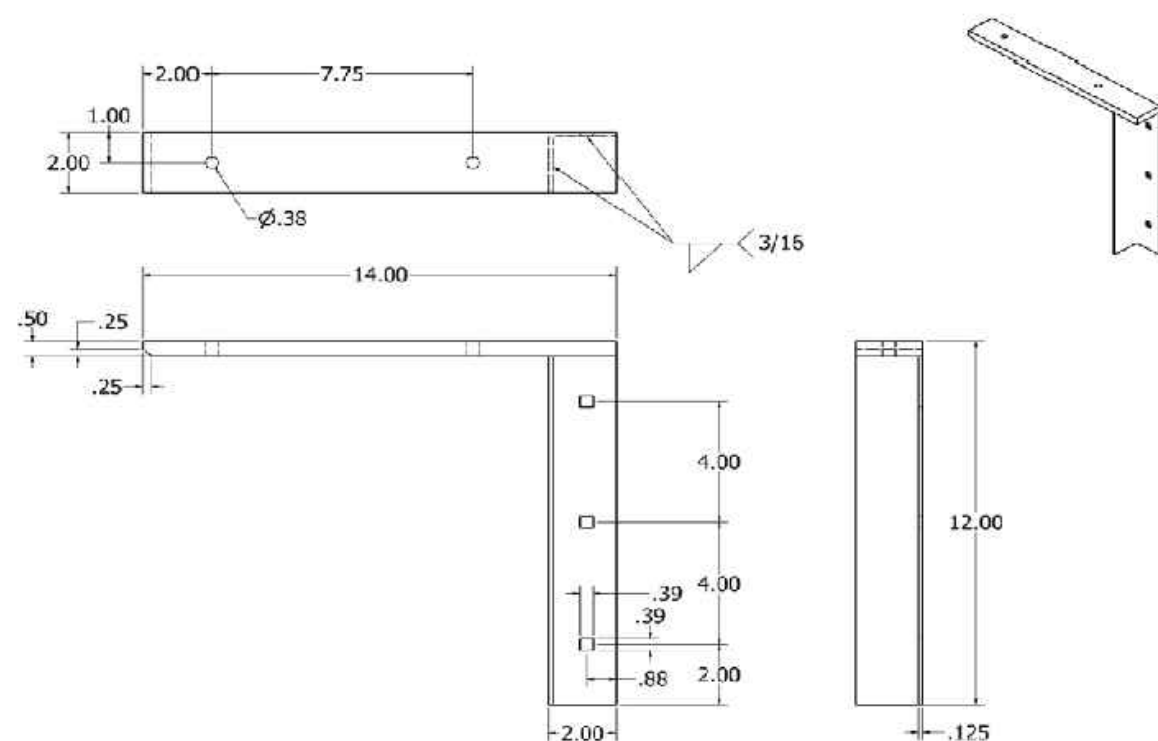

HW09

A&M HARDWARE, INC. Concealed Brackets

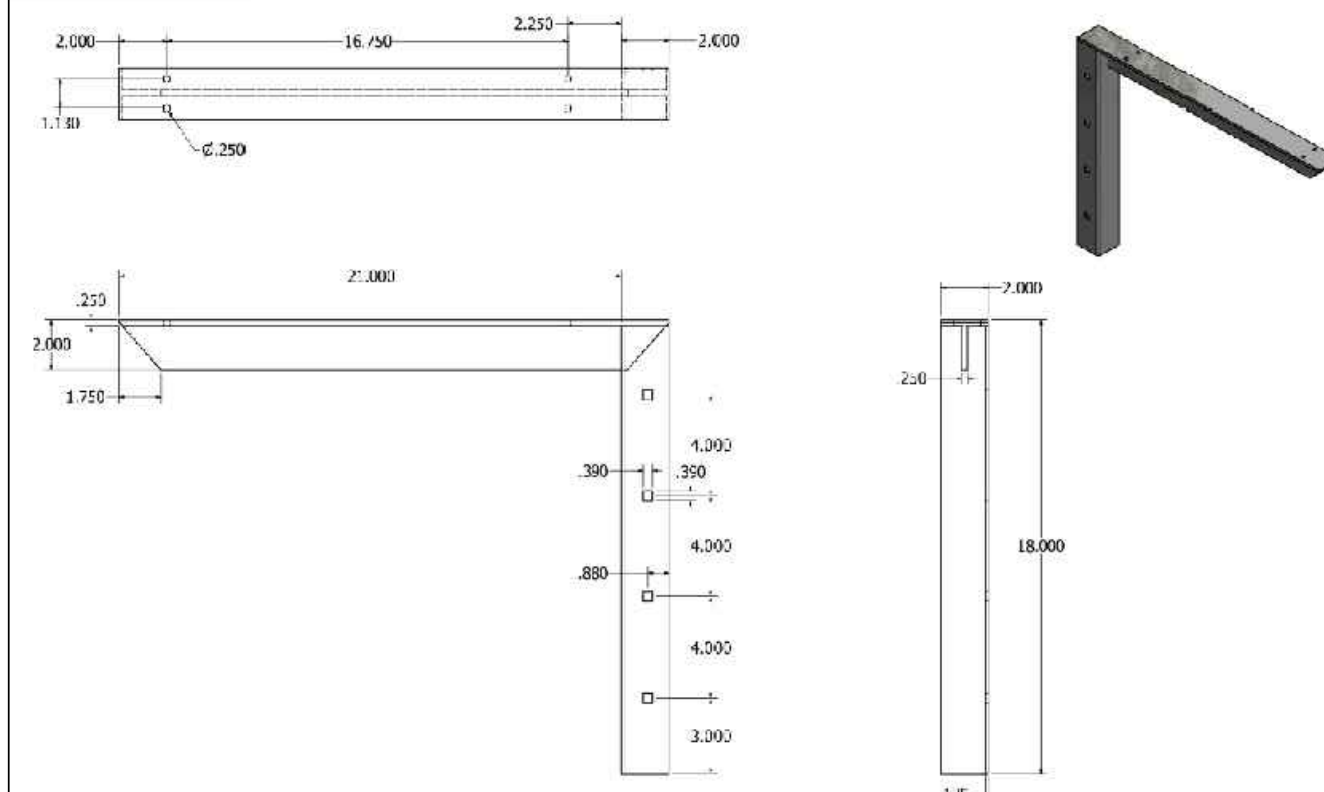


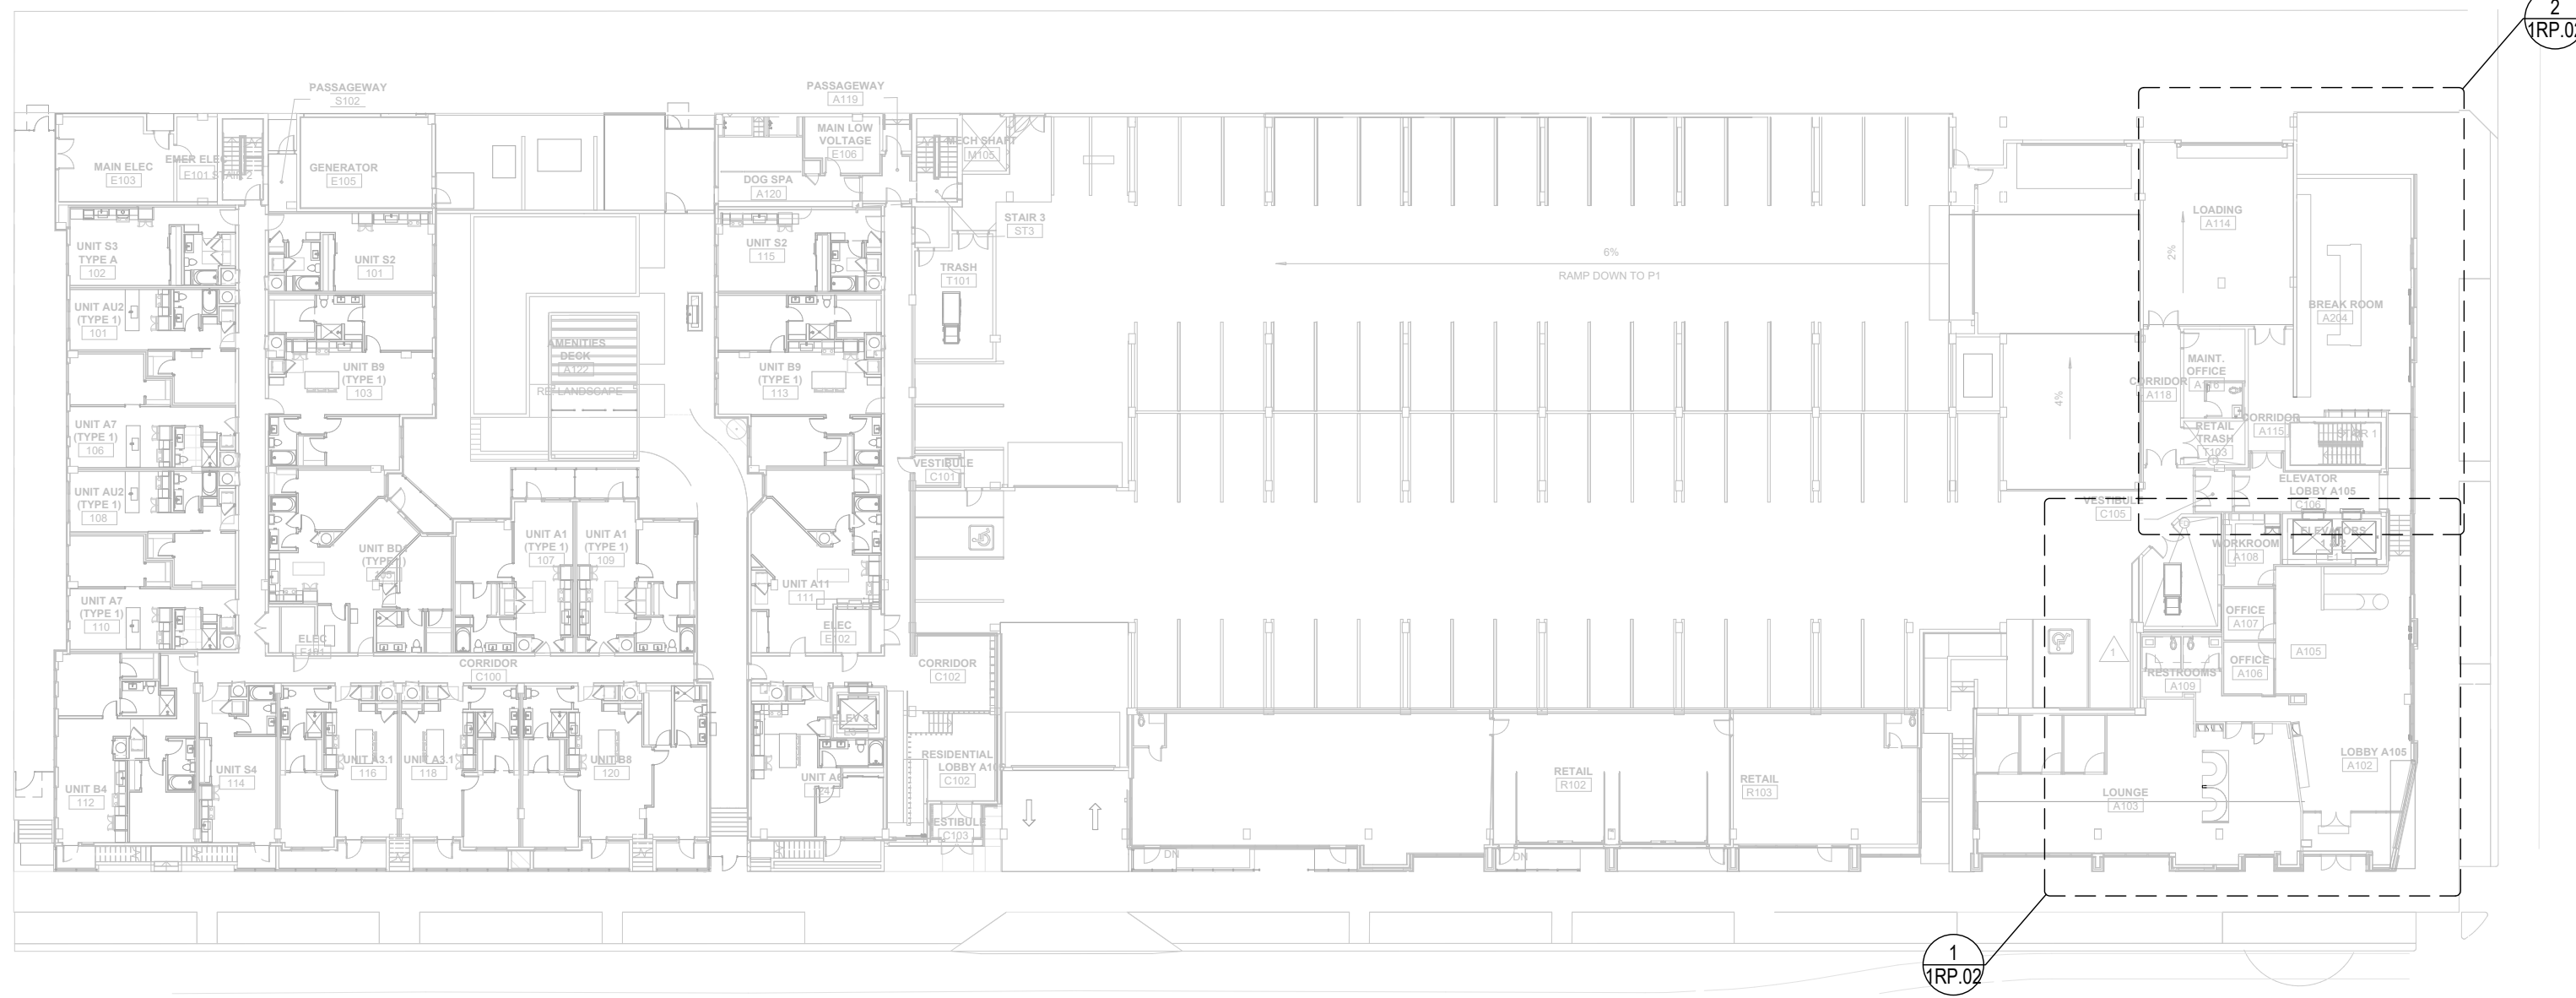
PROJECT:
SAMPLE DRAWINGS

PROJECT ADDRESS:
ORANGE AVE, NASHVILLE, TN


ARCHITECT:
FREDDY C.

G.C.:
PAOLO P.

	QCP	YES <input checked="" type="checkbox"/>	NO <input type="checkbox"/>
	LEED	YES <input type="checkbox"/>	NO <input checked="" type="checkbox"/>
	FSC	YES <input type="checkbox"/>	NO <input checked="" type="checkbox"/>
	NAUF	YES <input type="checkbox"/>	NO <input checked="" type="checkbox"/>



01 REFERENCE PLAN
REF_PLAN_LEVEL_1
SCALE: 1/32"=1'-0" ARCH REF.:A1/A601

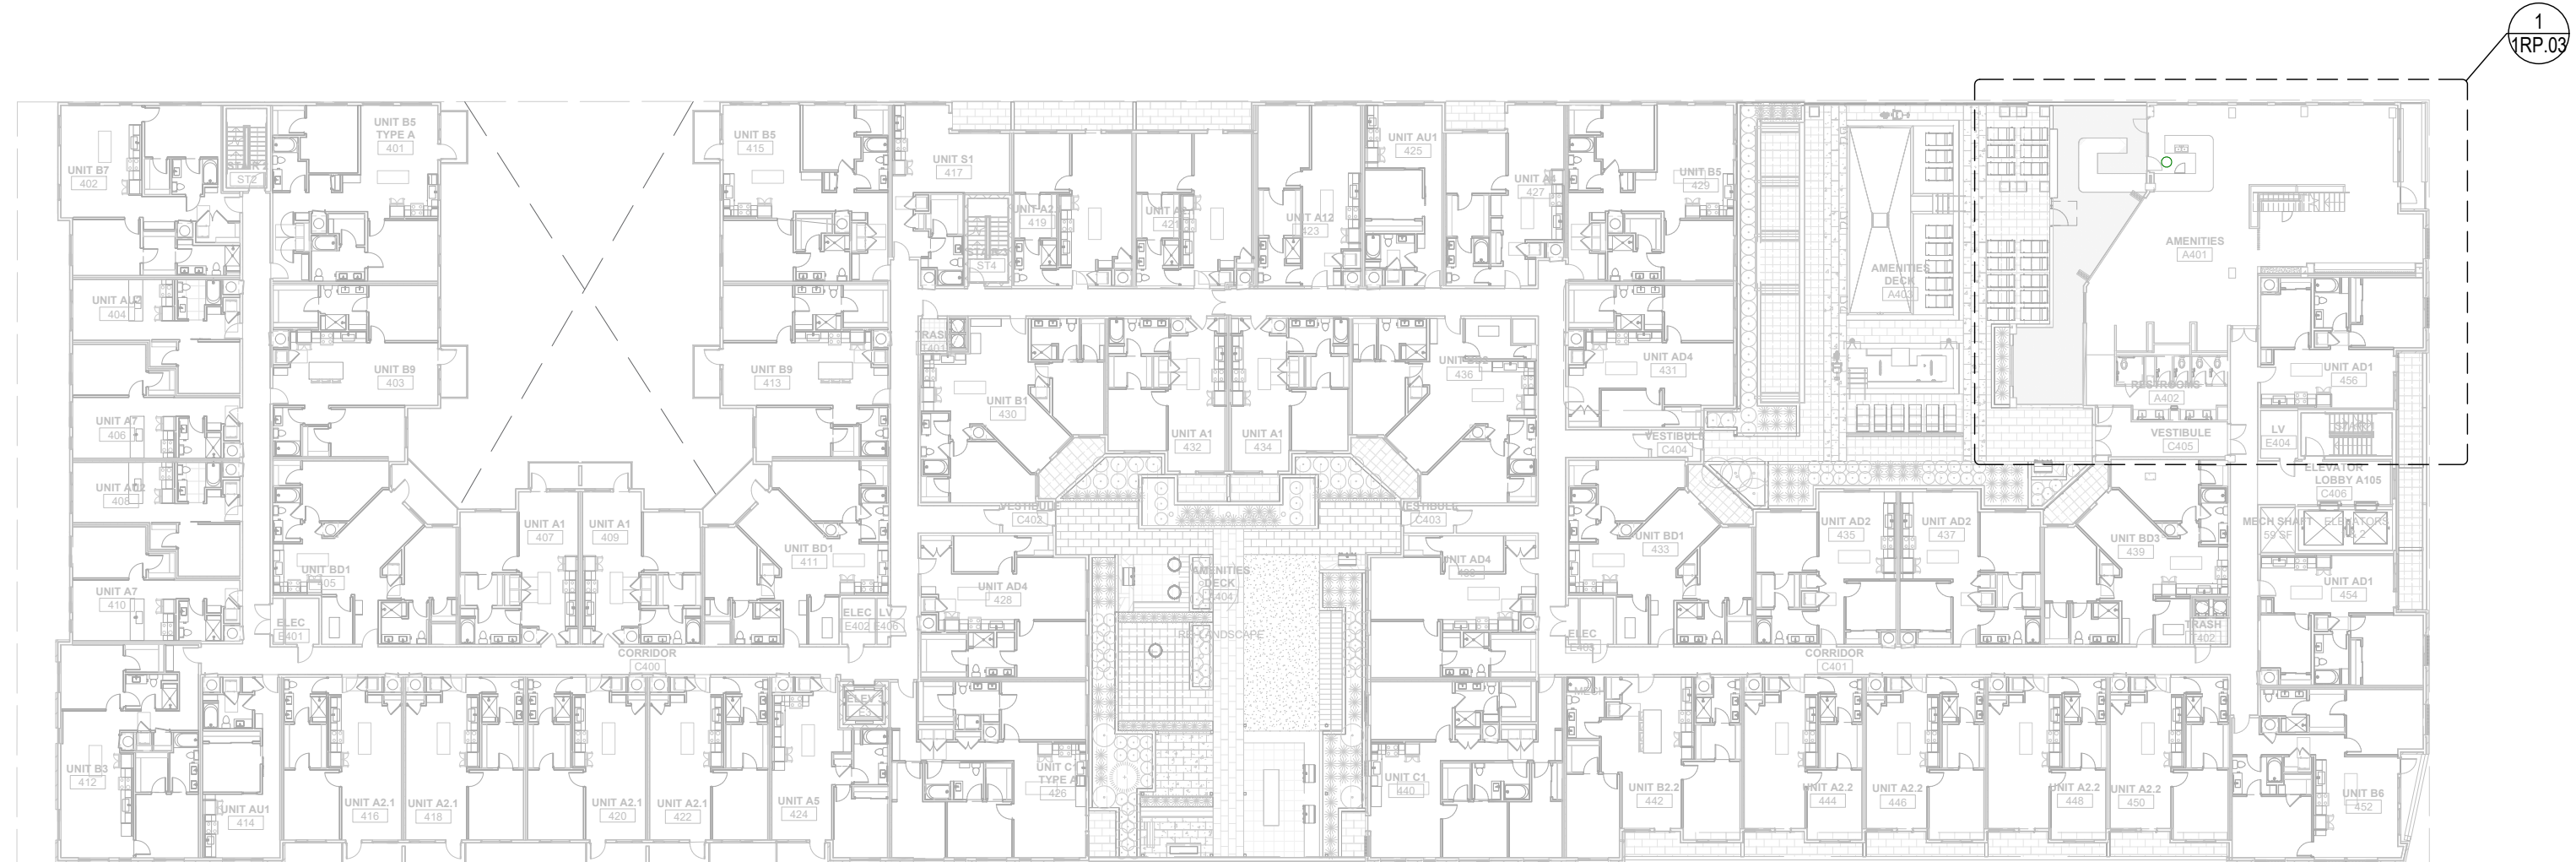

02 REFERENCE PLAN
REF_PLAN_LEVEL_1
SCALE: 1/32"=1'-0" ARCH REF.:A1/A604

FINISHES:

PM:	ERW
DRAWN BY:	TMS
DATE DRAWN:	02/10/2023
REVIEWED BY:	LCT (LOC)

REVISIONS:

No.	DATE:	DESCRIPTIONS:	BY:
△	-	-	-
△	-	-	-
△	-	-	-
△	-	-	-
△	-	-	-
△	-	-	-
△	-	-	-

APPROVAL DATE	-
PLOT DATE	07/11/2024
PROJECT NUMBER	P-5567446
ROOM NAME	REF. PLANS
SHEET NUMBER	1RP.01

PROJECT:
SAMPLE DRAWINGS

PROJECT ADDRESS:
ORANGE AVE, NASHVILLE, TN

ARCHITECT:
FREDDY C.

G.C.:
PAOLO P.


	QCP	YES <input checked="" type="checkbox"/>	NO <input type="checkbox"/>
	LEED	YES <input type="checkbox"/>	NO <input checked="" type="checkbox"/>
	FSC	YES <input type="checkbox"/>	NO <input checked="" type="checkbox"/>
	NAUF	YES <input type="checkbox"/>	NO <input checked="" type="checkbox"/>

FINISHES:


PM:	ERW
DRAWN BY:	TMS
DATE DRAWN:	02/10/2023
REVIEWED BY:	LCT (LOC)

REVISIONS:			
No.	DATE:	DESCRIPTIONS:	BY:
△	-	-	-
△	-	-	-
△	-	-	-
△	-	-	-
△	-	-	-
△	-	-	-
△	-	-	-

APPROVAL DATE	-
PLOT DATE	07/11/2024
PROJECT NUMBER	P-5567446
ROOM NAME	REF. PLANS
SHEET NUMBER	1RP.02

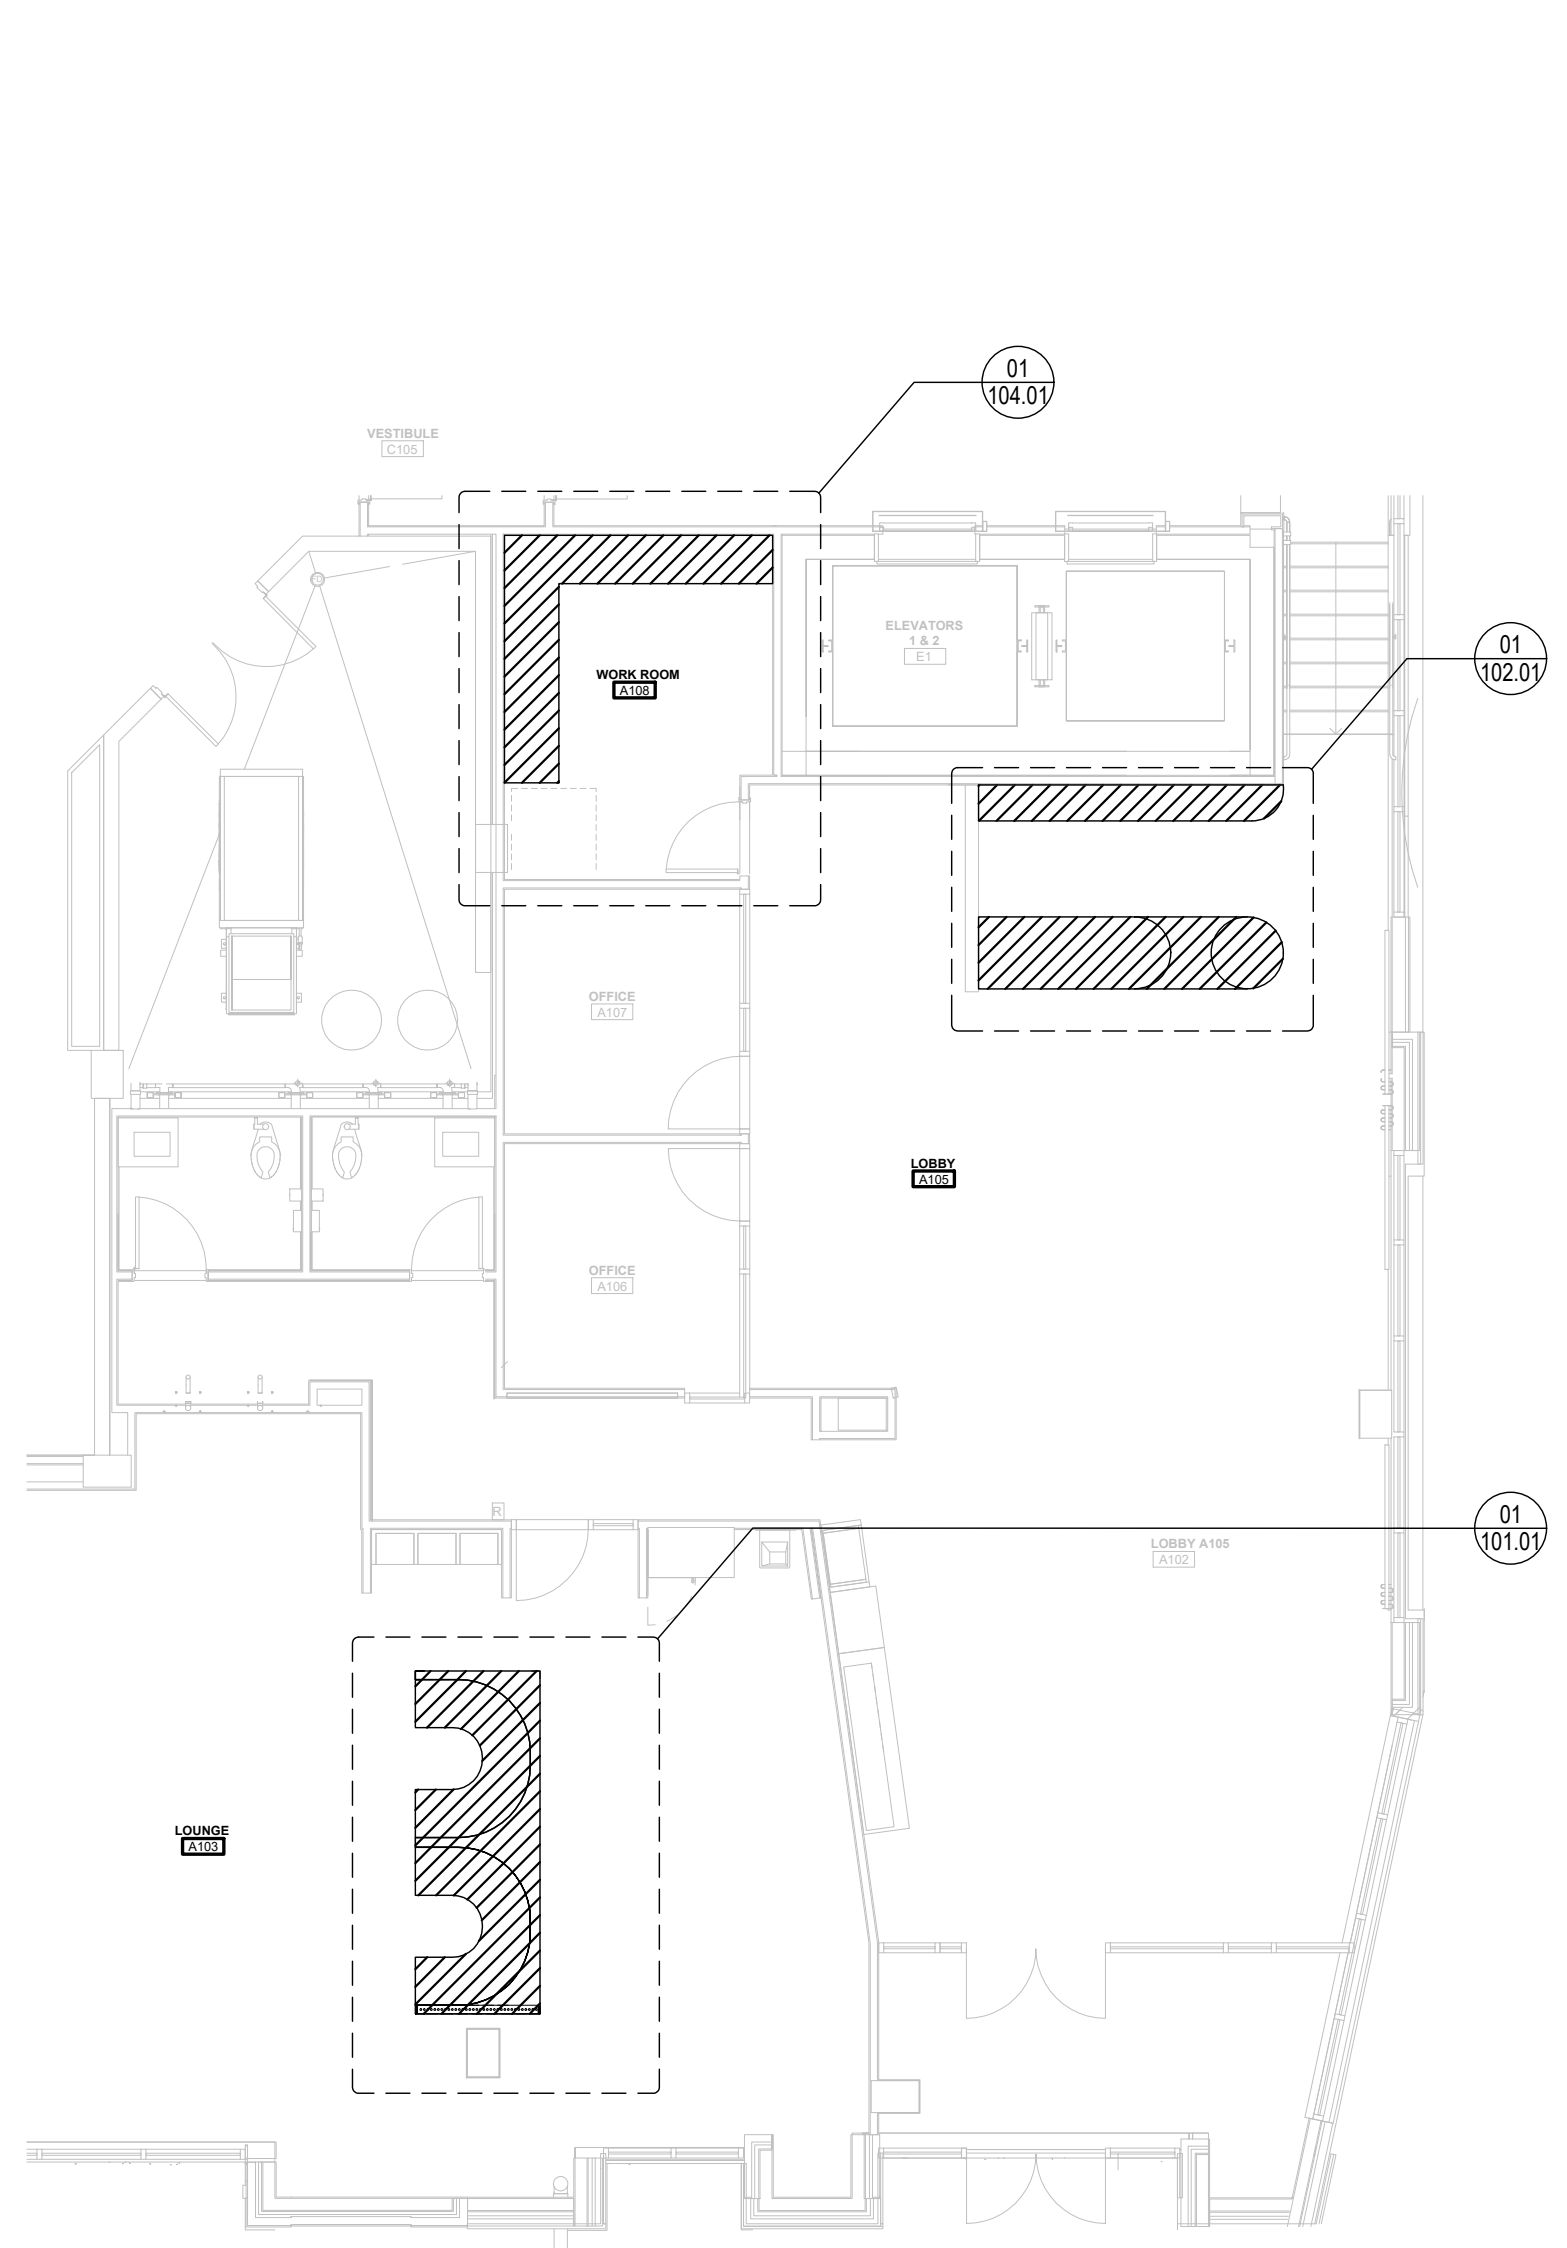

03 LEVEL 1 ENLARGED PLAN - LOBBY A105
REFERENCE PLAN
SCALE: 1/8"=1'-0" ARCH REF.: A1/A601A

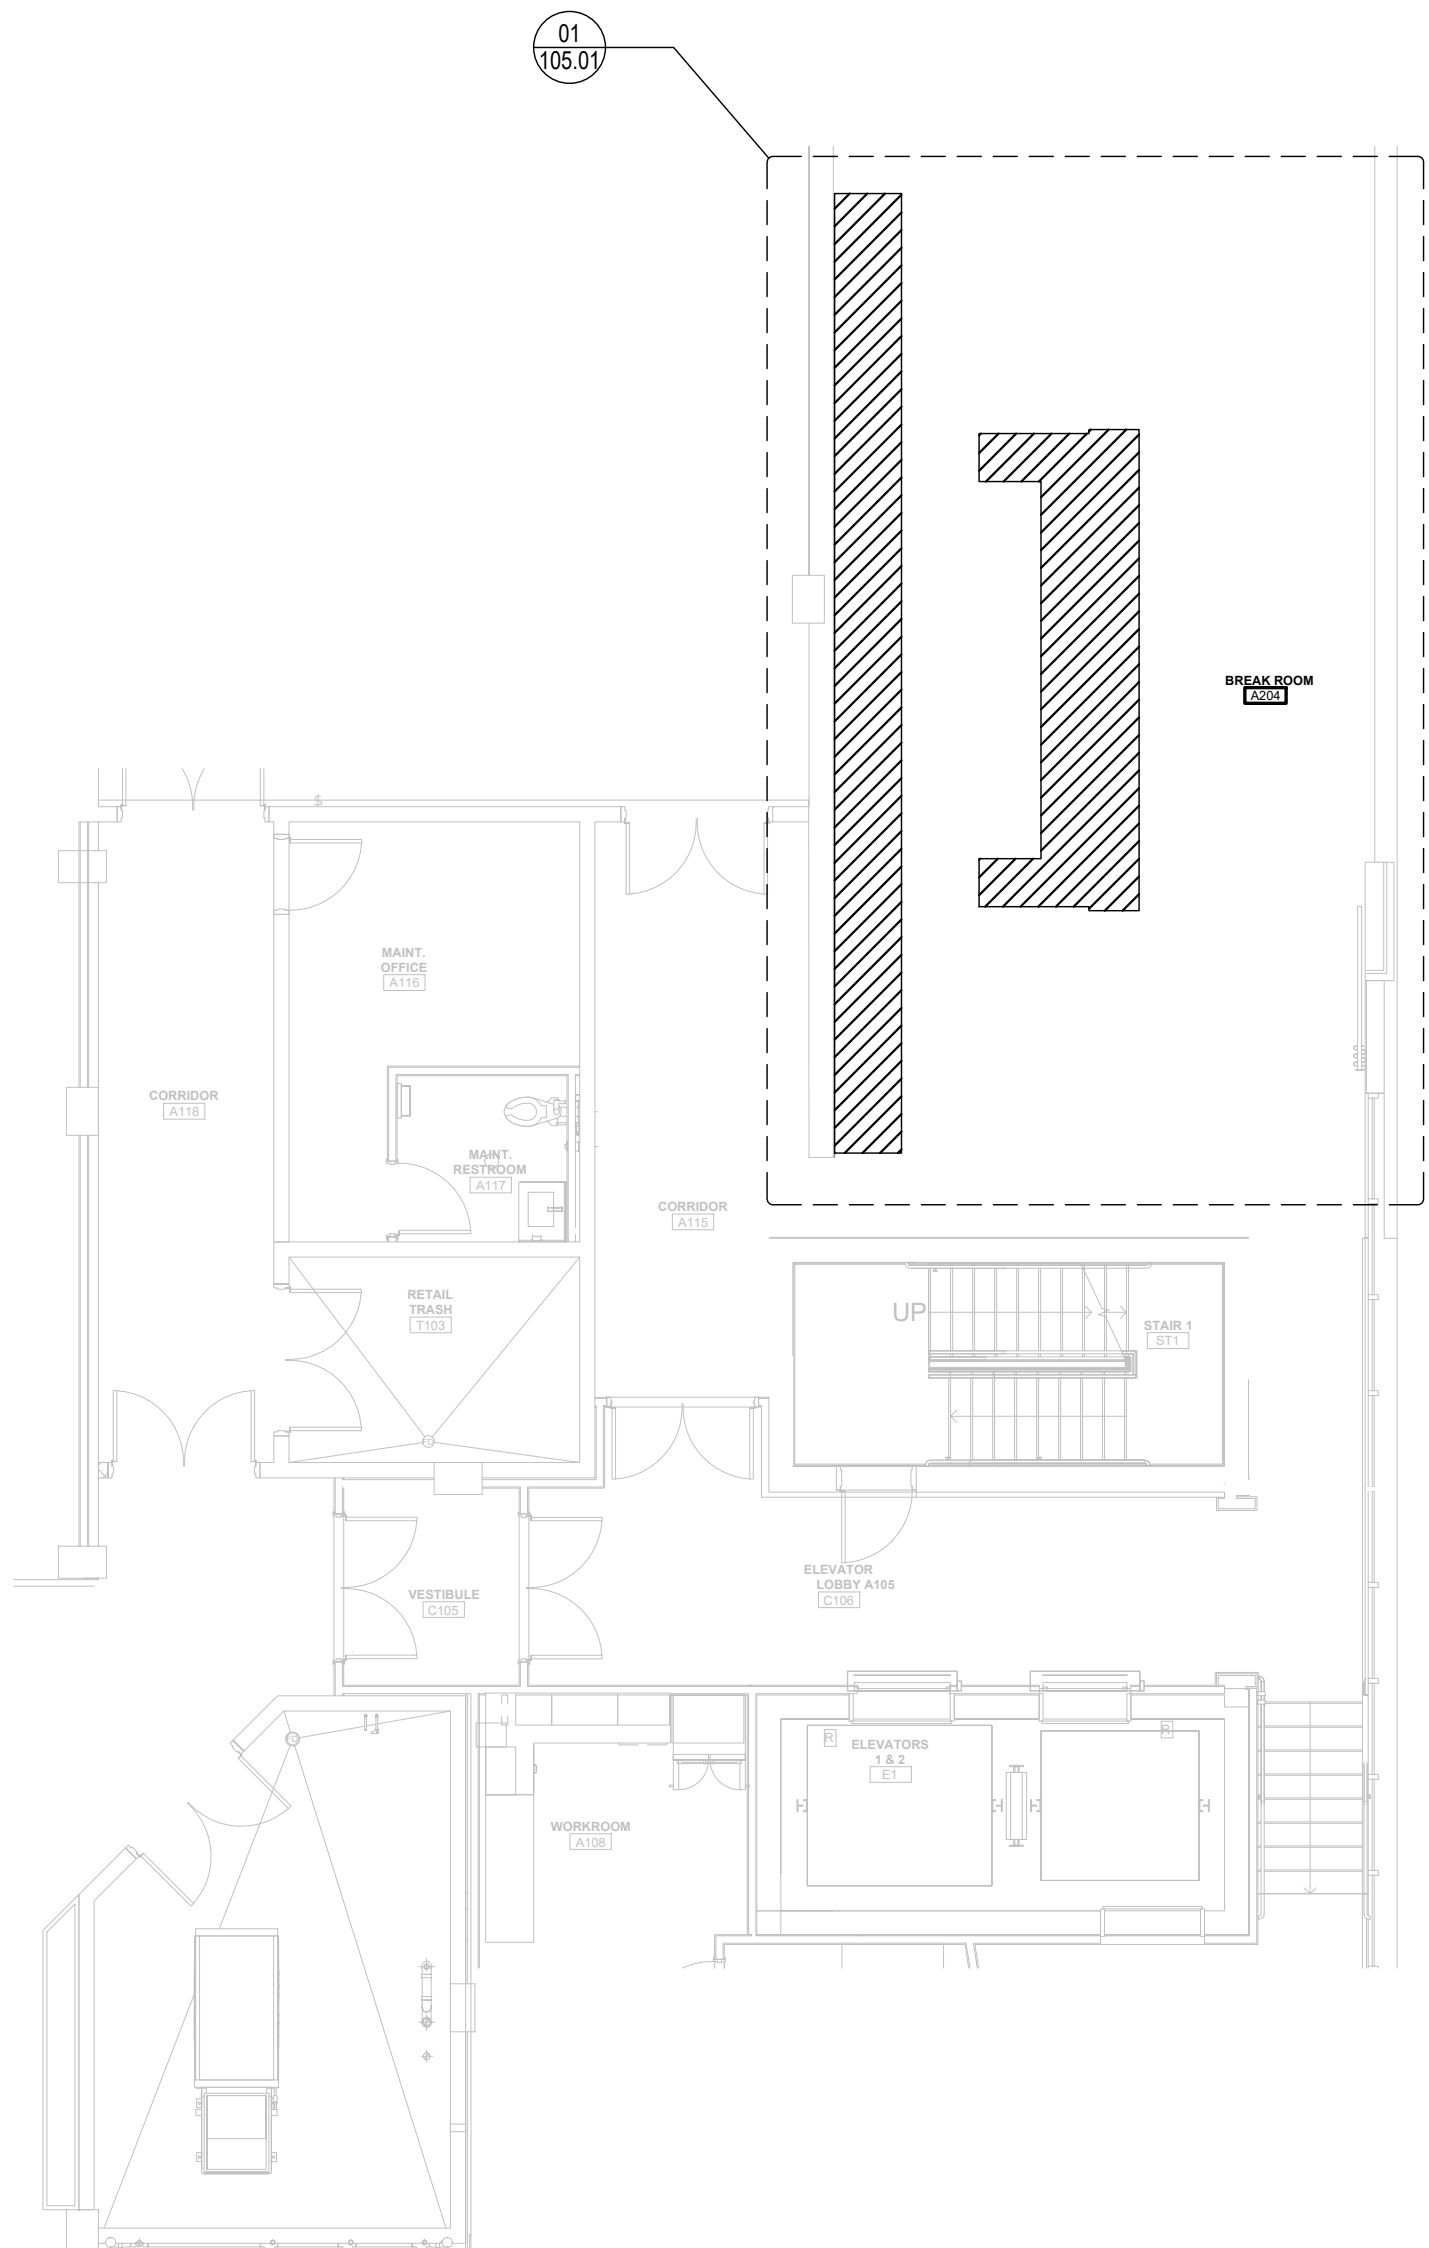

04 LEVEL 1 ENLARGED PLAN - MAIL ROOM
REFERENCE PLAN
SCALE: 1/8"=1'-0" ARCH REF.: A1/A602A

PROJECT:

SAMPLE DRAWINGS

PROJECT ADDRESS:


ORANGE AVE, NASHVILLE, TN

ARCHITECT:

FREDDY C.

G.C.:

PAOLO P.

	QCP	YES <input checked="" type="checkbox"/>	NO <input type="checkbox"/>
	LEED	YES <input type="checkbox"/>	NO <input checked="" type="checkbox"/>
	FSC	YES <input type="checkbox"/>	NO <input checked="" type="checkbox"/>
	NAUF	YES <input type="checkbox"/>	NO <input checked="" type="checkbox"/>


FINISHES:

PM:	ERW
DRAWN BY:	TMS
DATE DRAWN:	02/10/2023
REVIEWED BY:	LCT (LOC)

REVISIONS:

No.	DATE:	DESCRIPTIONS:	BY:
△	-	-	-
△	-	-	-
△	-	-	-
△	-	-	-
△	-	-	-
△	-	-	-
△	-	-	-
△	-	-	-

APPROVAL DATE	-
PLOT DATE	07/11/2024
PROJECT NUMBER	P-5567446
ROOM NAME	REF. PLANS
SHEET NUMBER	1RP.03

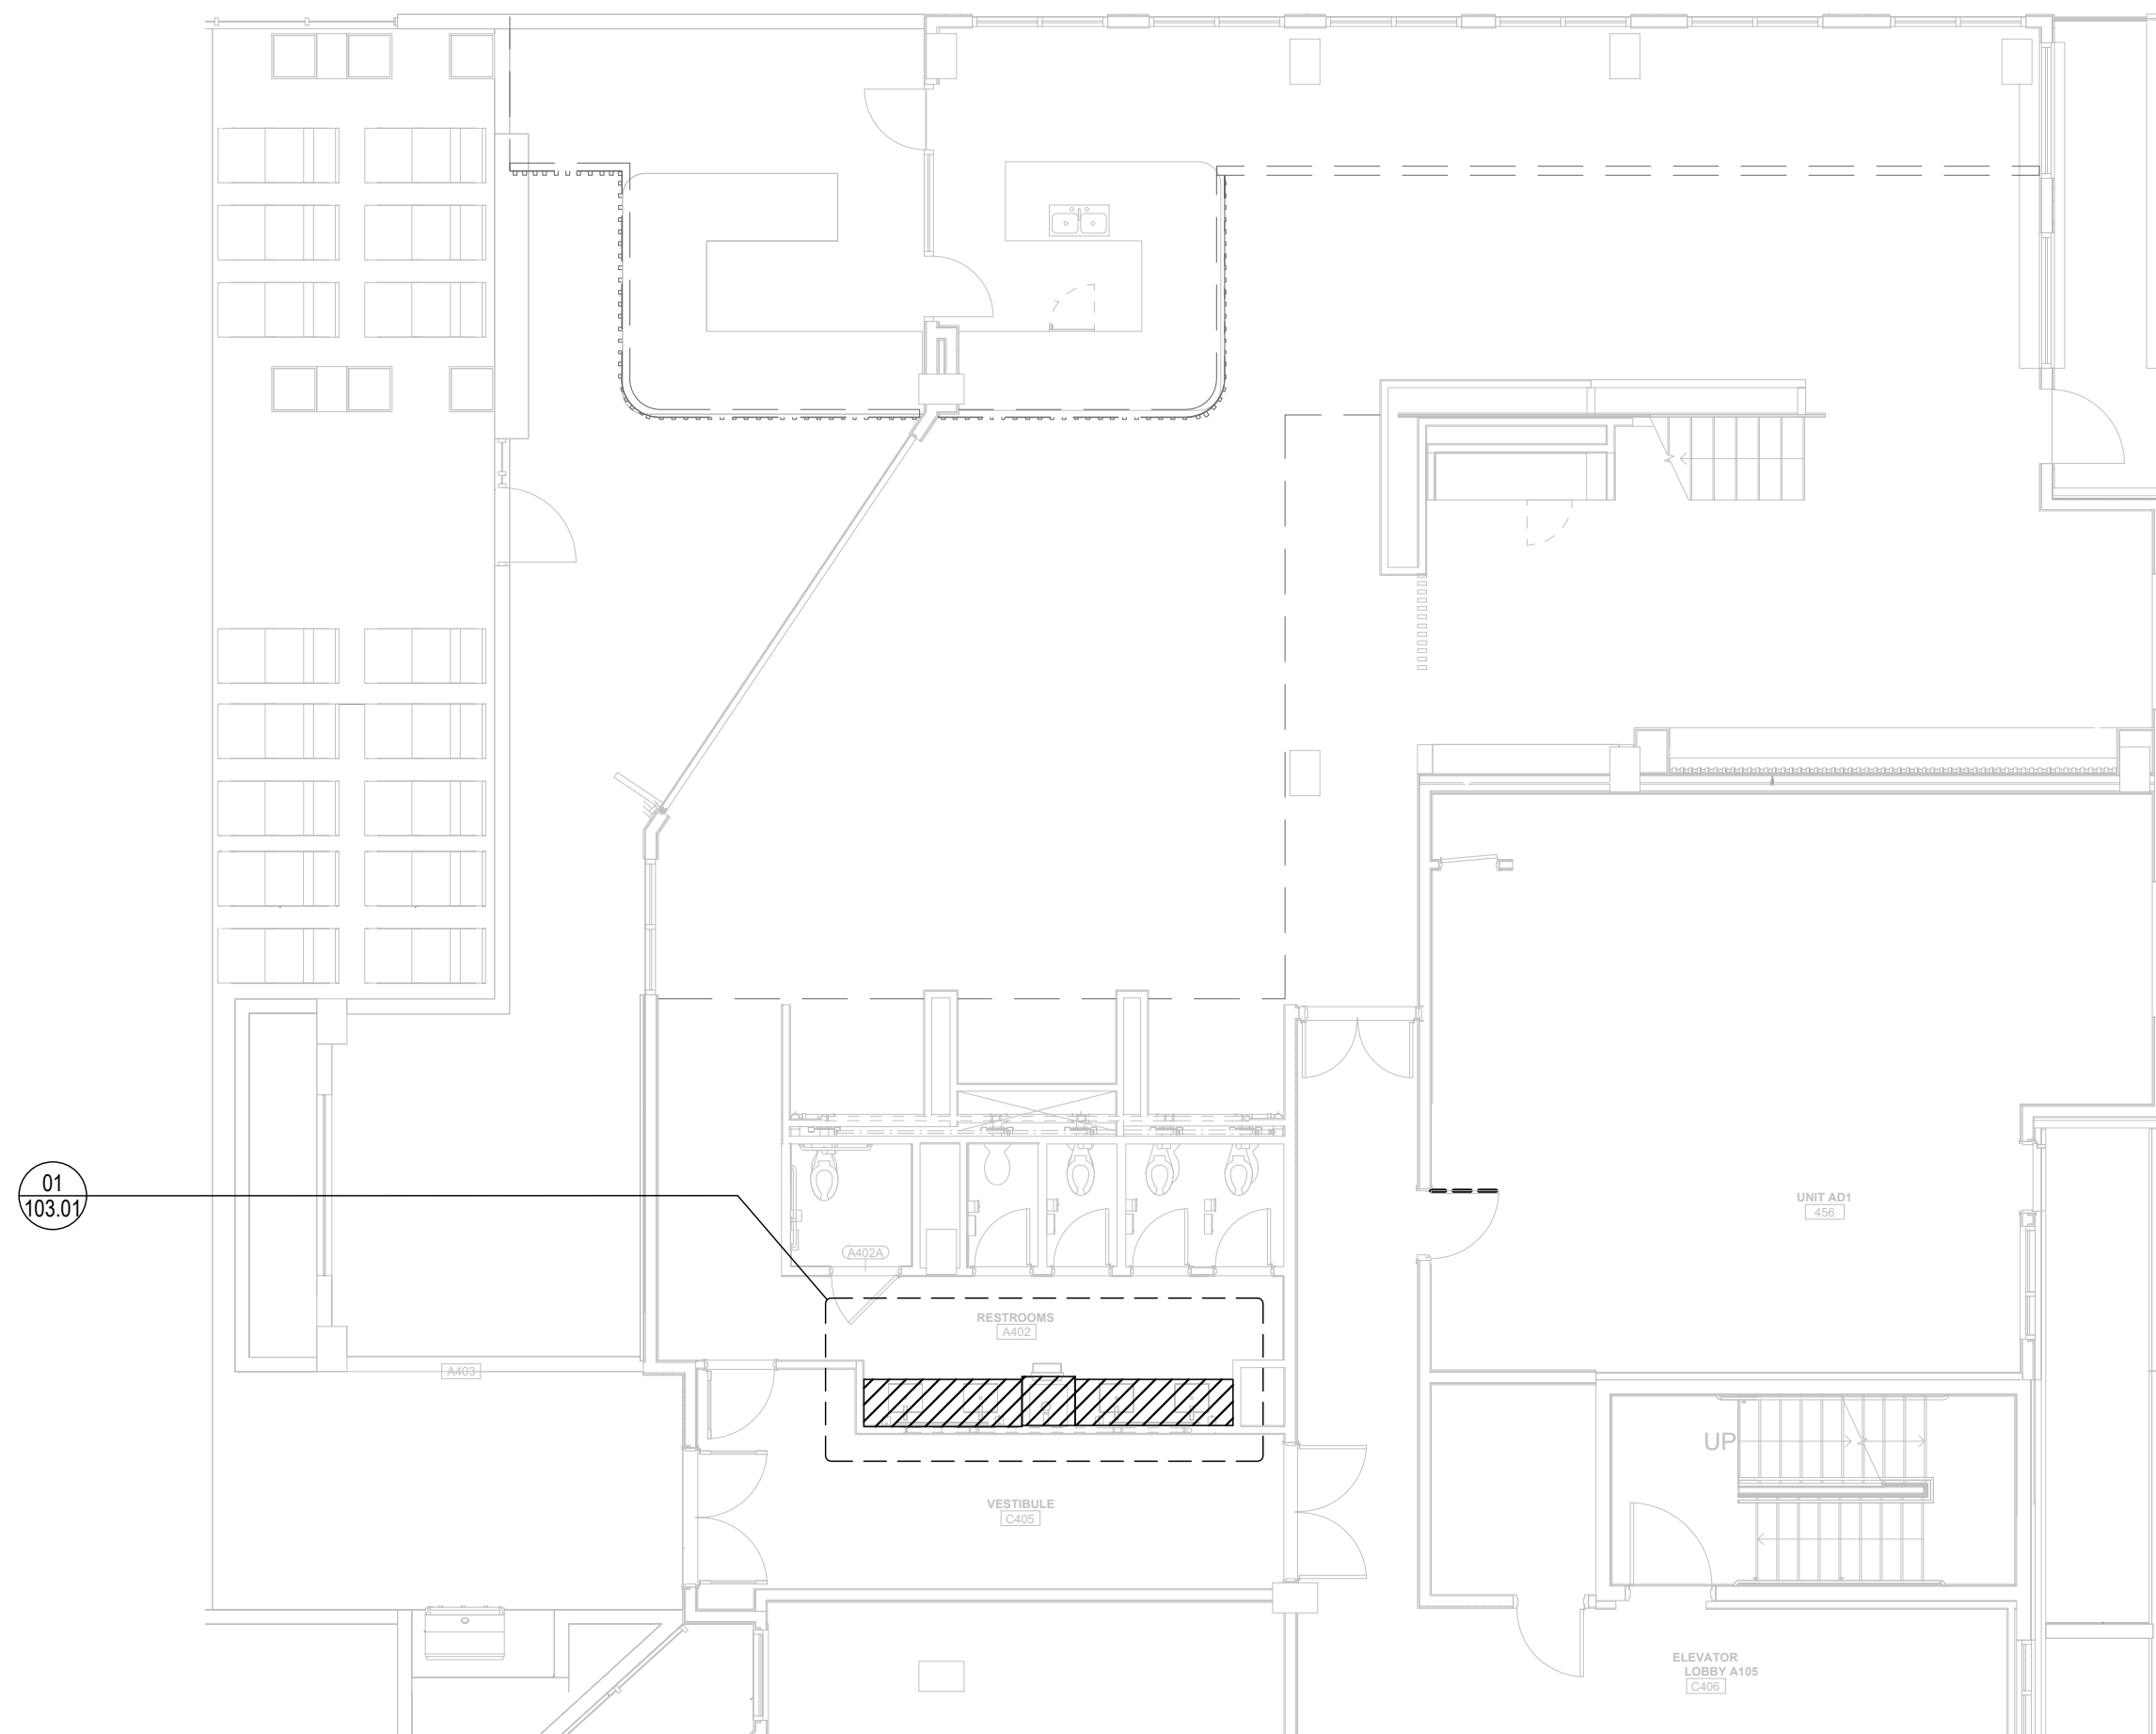

05 LEVEL 1 ENLARGED PLAN - MAIL ROOM
REFERENCE PLAN
SCALE: 1/8"=1'-0" ARCH REF.: A1/A603A

PROJECT:
SAMPLE DRAWINGS

PROJECT ADDRESS:
ORANGE AVE, NASHVILLE, TN

ARCHITECT:
FREDDY C.

G.C.:
PAOLO P.

	QCP	YES <input checked="" type="checkbox"/>	NO <input type="checkbox"/>
	LEED	YES <input type="checkbox"/>	NO <input checked="" type="checkbox"/>
	FSC	YES <input type="checkbox"/>	NO <input checked="" type="checkbox"/>
	NAUF	YES <input type="checkbox"/>	NO <input checked="" type="checkbox"/>

FINISHES:


PLASTIC LAMINATE	
KEY	COLOR
PL2	WILSONART - WALNUT HEIGHT, 7965K-12K
VENEER	
KEY	COLOR
WD1	VENEER TO MATCH PL2

PM:	ERW
DRAWN BY:	TMS
DATE DRAWN:	02/10/2023
REVIEWED BY:	LCT (LOC)


REVISIONS:

No.	DATE	DESCRIPTIONS	BY:
△	-	-	-
△	-	-	-
△	-	-	-
△	-	-	-
△	-	-	-
△	-	-	-
△	-	-	-

APPROVAL DATE	-
PLOT DATE	07/11/2024
PROJECT NUMBER	P-5567446
ROOM NAME	LOUNGE A103
SHEET NUMBER	101.01

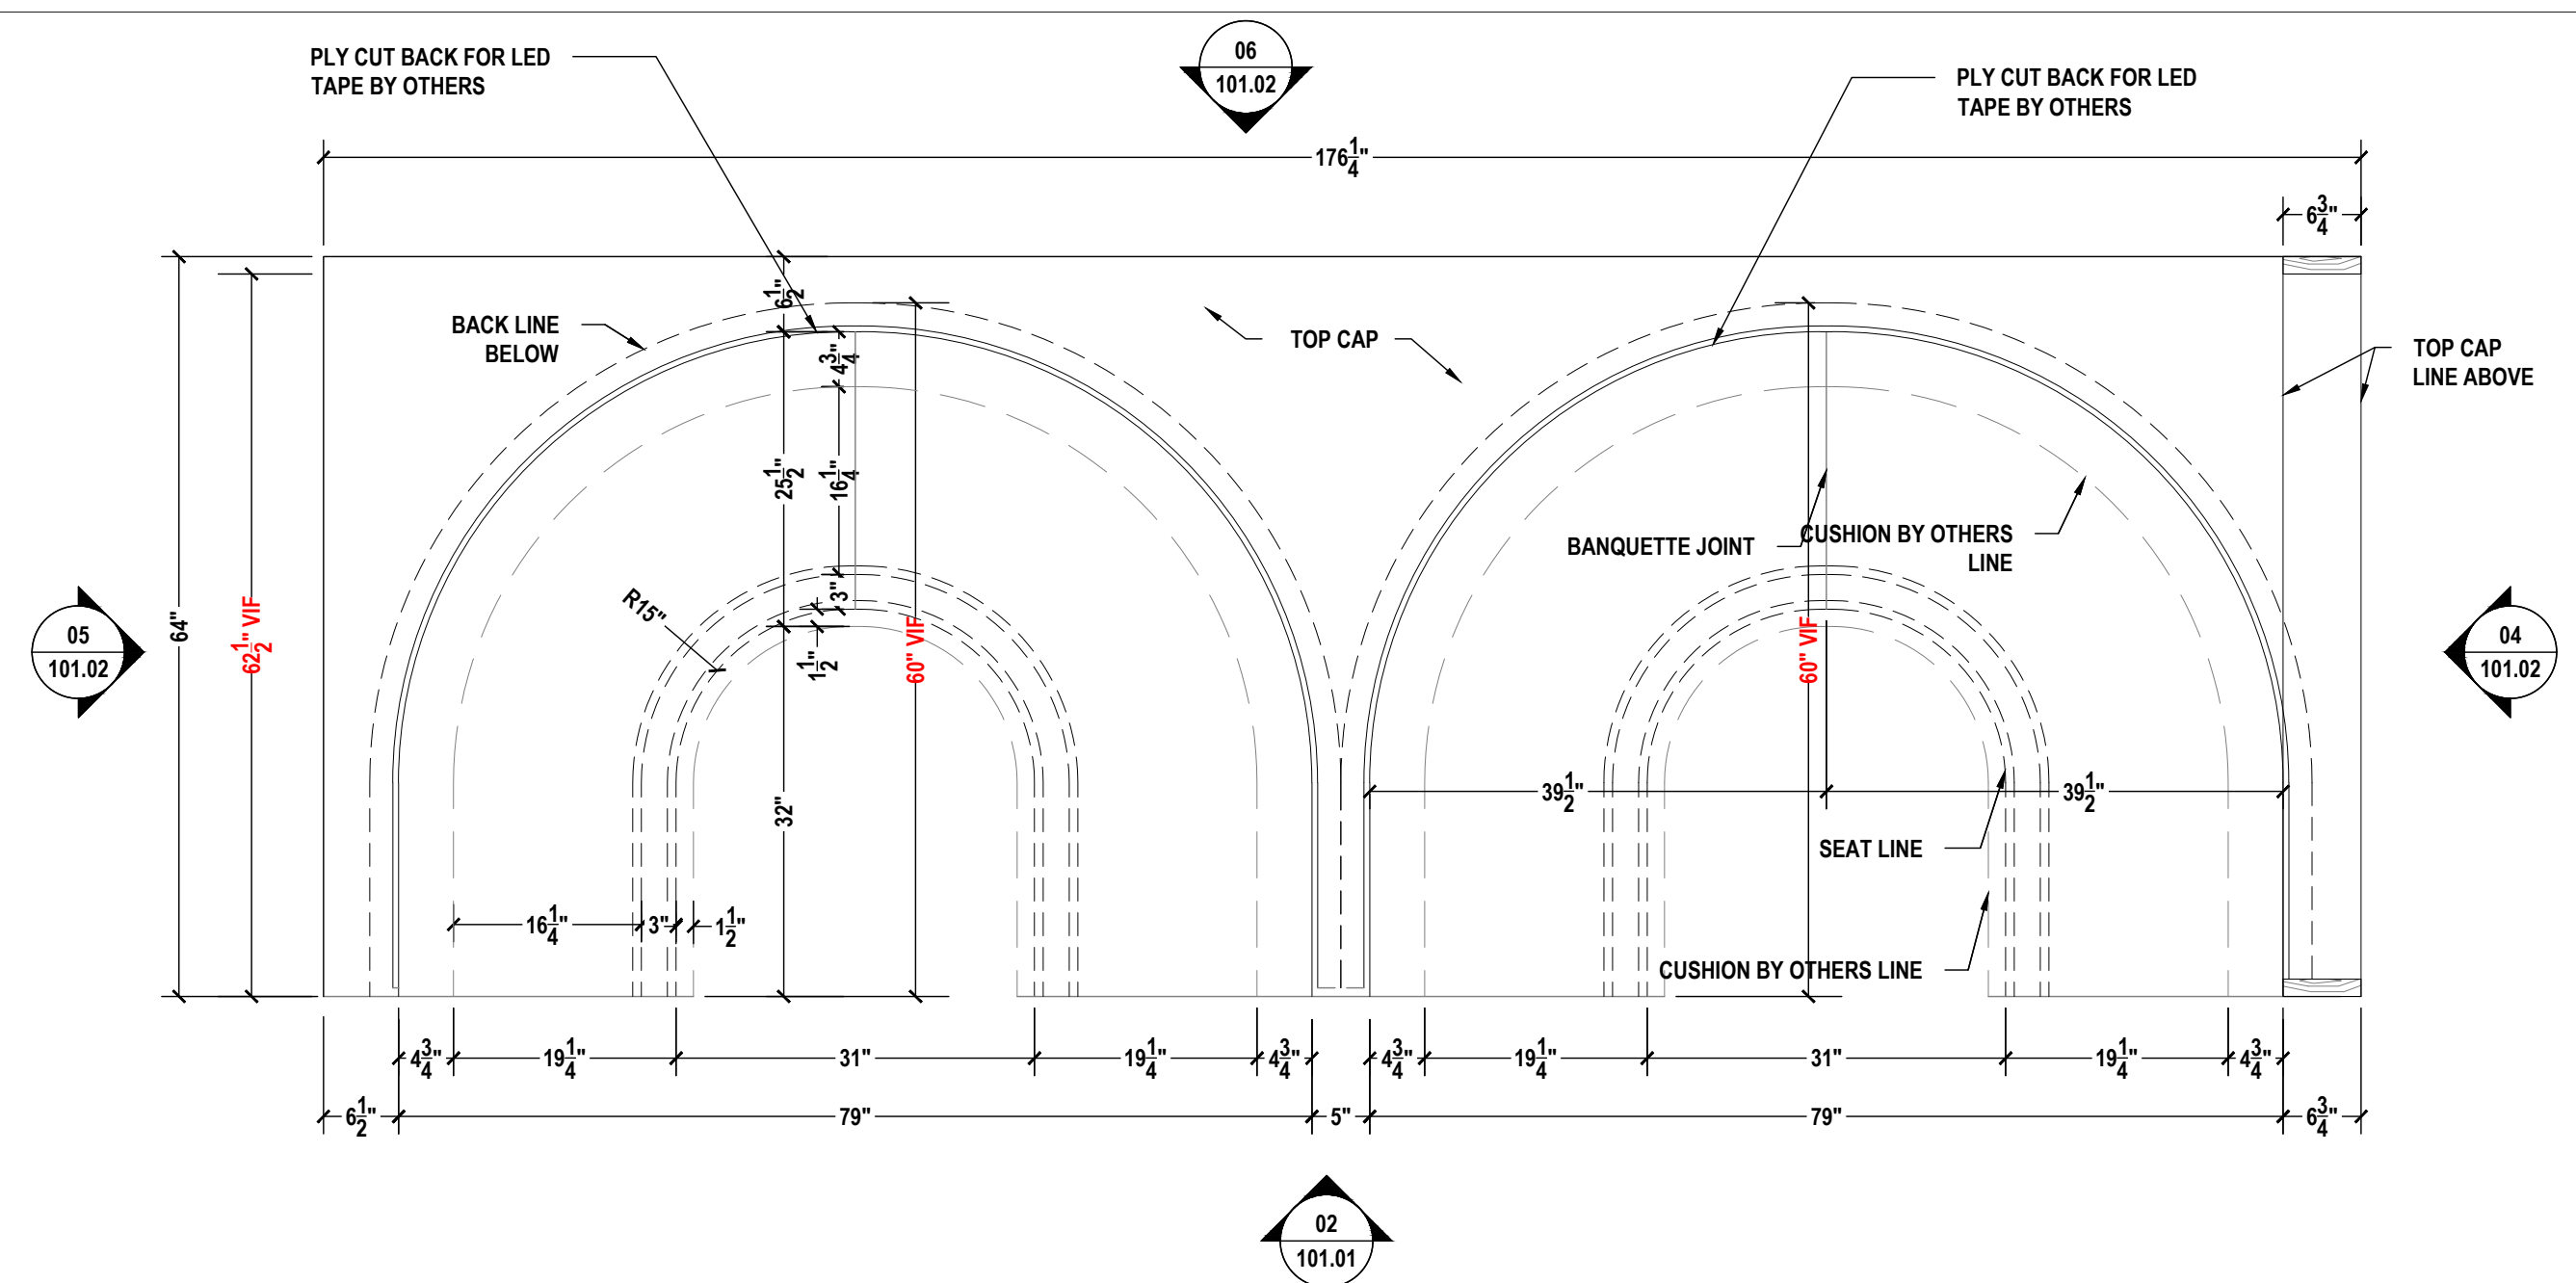

01 LOUNGE A103 - BANQUETTE
PLAN VIEW
SCALE: 3/4"=1'-0" ARCH REF.: A1/A603

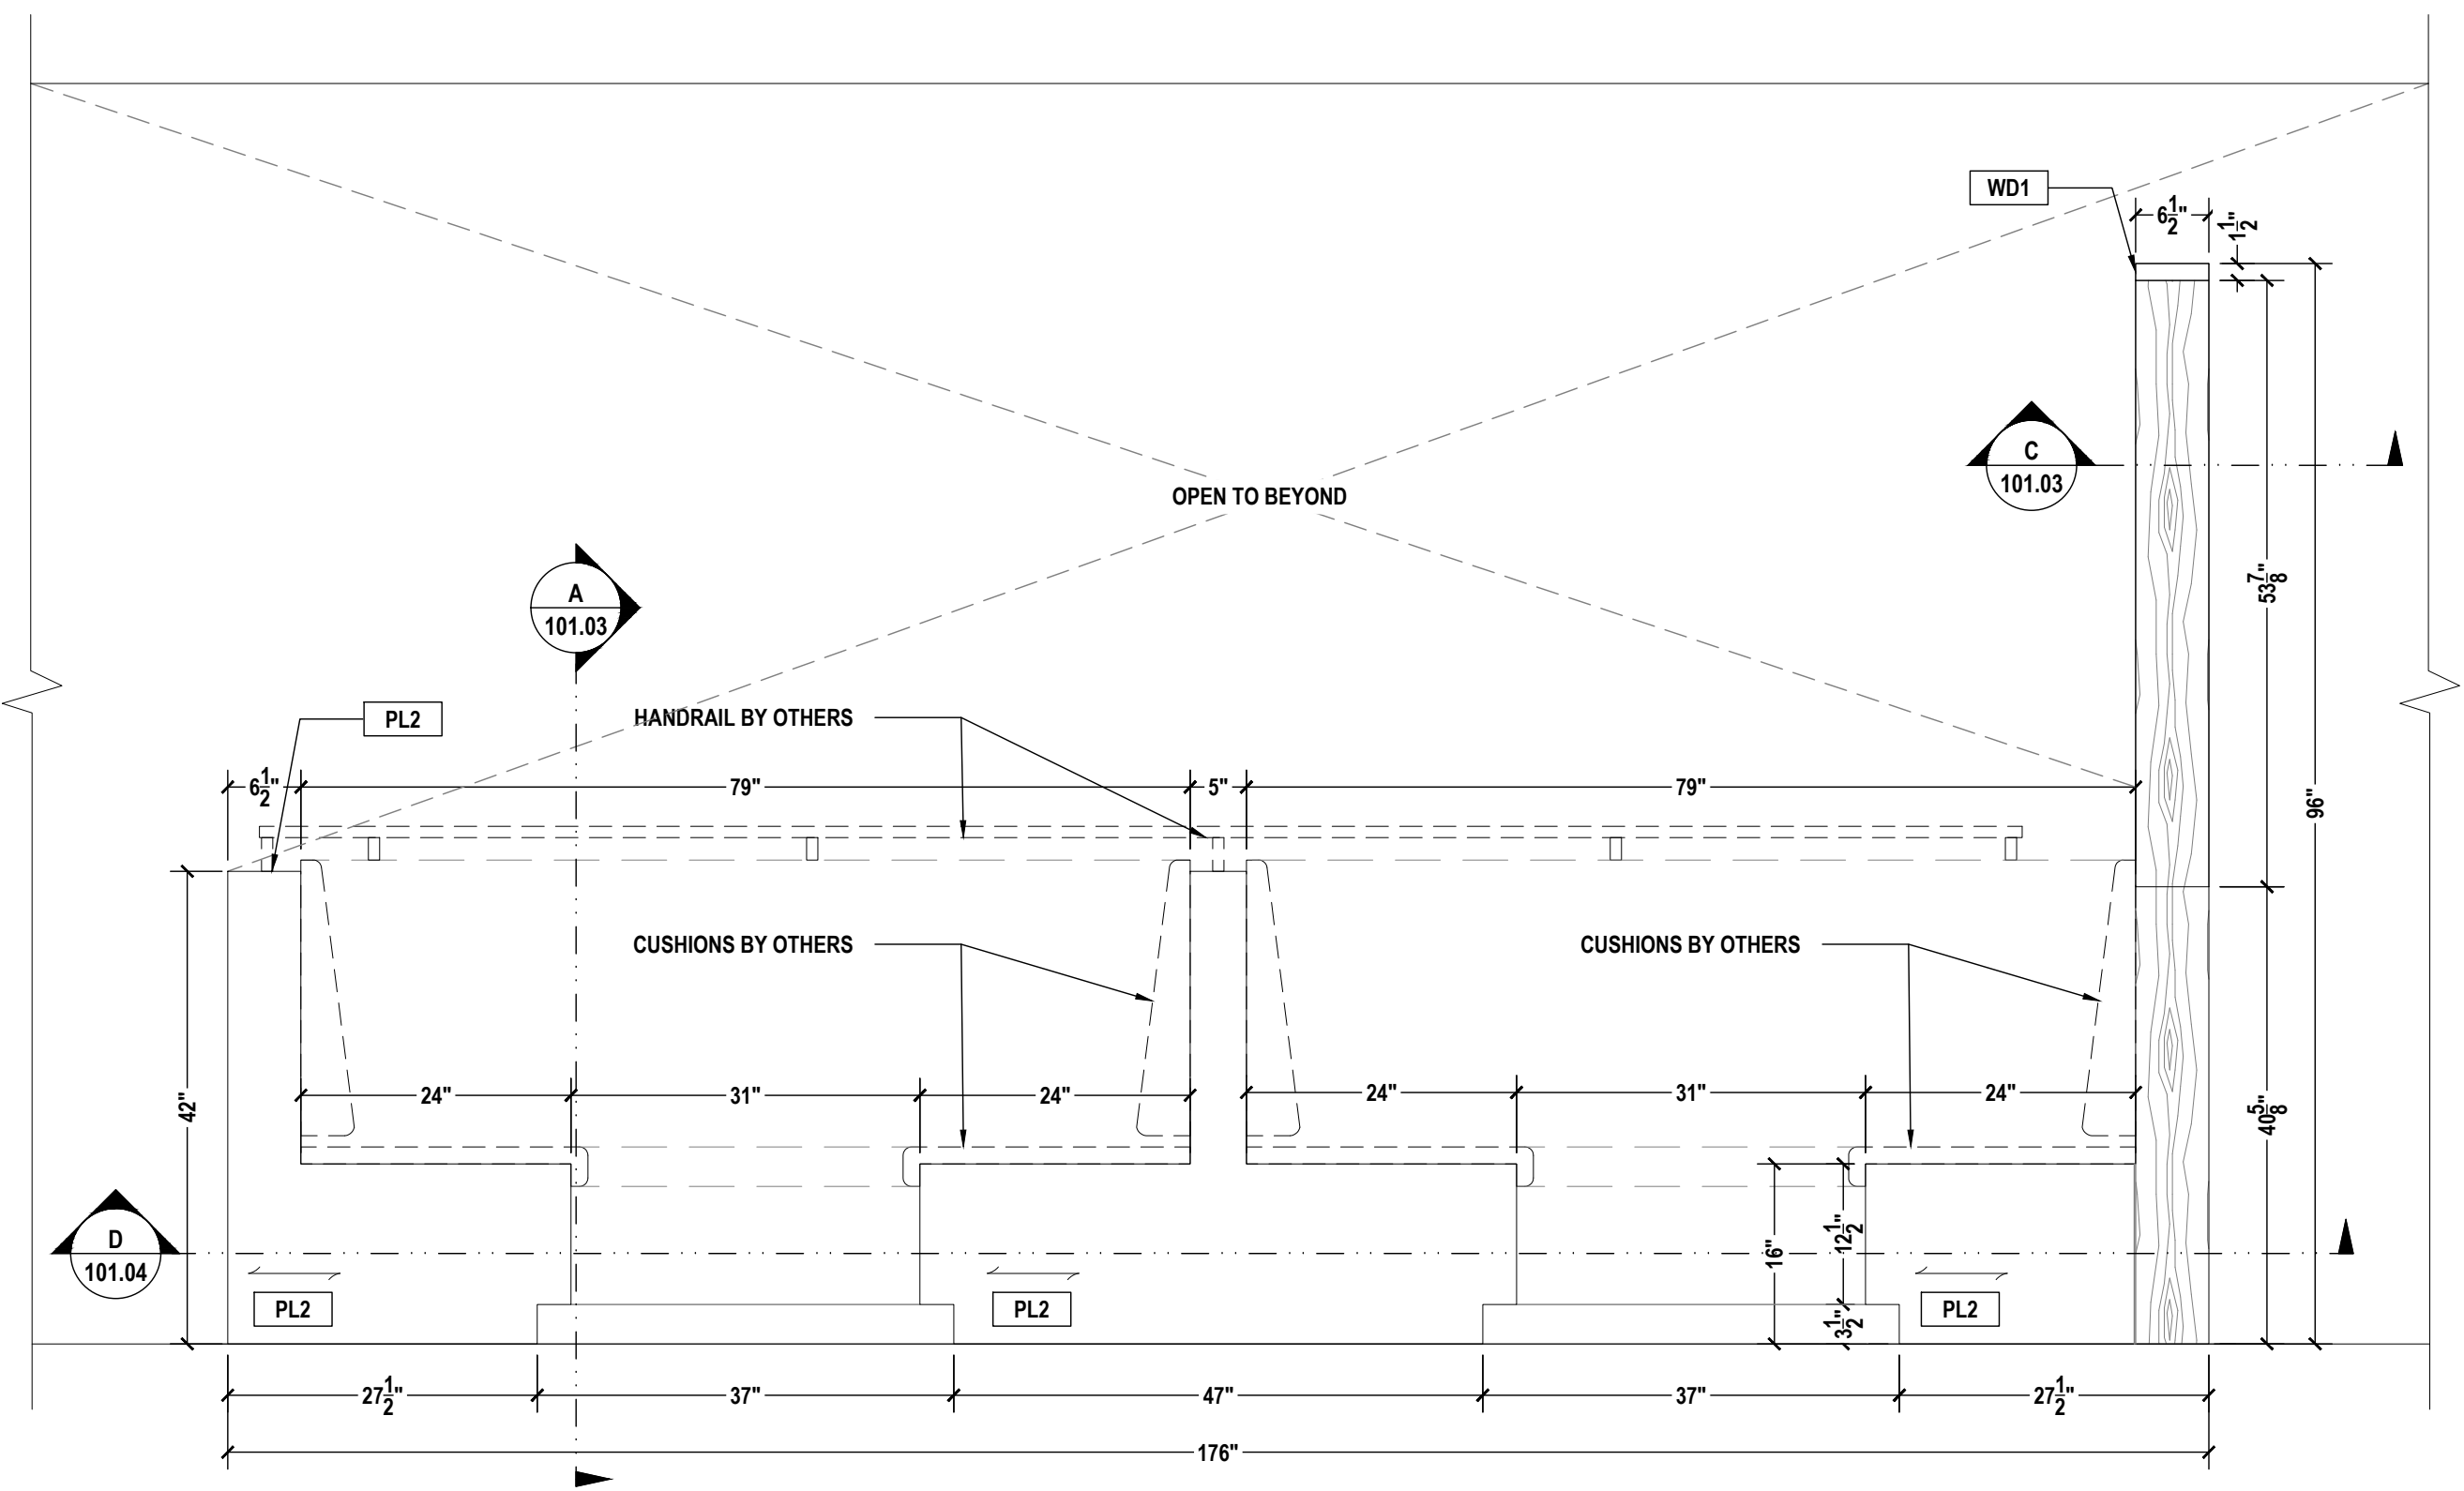

02 LOUNGE A103 - BANQUETTE
ELEVATION
SCALE: 3/4"=1'-0" ARCH REF.: A2/A603

PROJECT:
SAMPLE DRAWINGS

PROJECT ADDRESS:
ORANGE AVE, NASHVILLE, TN

ARCHITECT:
FREDDY C.

G.C.:
PAOLO P.

	QCP	YES <input checked="" type="checkbox"/>	NO <input type="checkbox"/>
	LEED	YES <input type="checkbox"/>	NO <input checked="" type="checkbox"/>
	FSC	YES <input type="checkbox"/>	NO <input checked="" type="checkbox"/>
	NAUF	YES <input type="checkbox"/>	NO <input checked="" type="checkbox"/>

FINISHES:
PLASTIC LAMINATE


KEY	COLOR
PL2	WILSONART - WALNUT HEIGHT, 7965K-12K
KEY	VENEER
KEY	COLOR
WD1	VENEER TO MATCH PL2

PM:	ERW
DRAWN BY:	TMS
DATE DRAWN:	02/10/2023
REVIEWED BY:	LCT (LOC)


REVISIONS:

No.	DATE:	DESCRIPTIONS:	BY:
△	-	-	-
△	-	-	-
△	-	-	-
△	-	-	-
△	-	-	-
△	-	-	-
△	-	-	-
△	-	-	-


APPROVAL DATE	-
PLOT DATE	07/11/2024
PROJECT NUMBER	P-5567446
ROOM NAME	LOUNGE A103
SHEET NUMBER	101.02

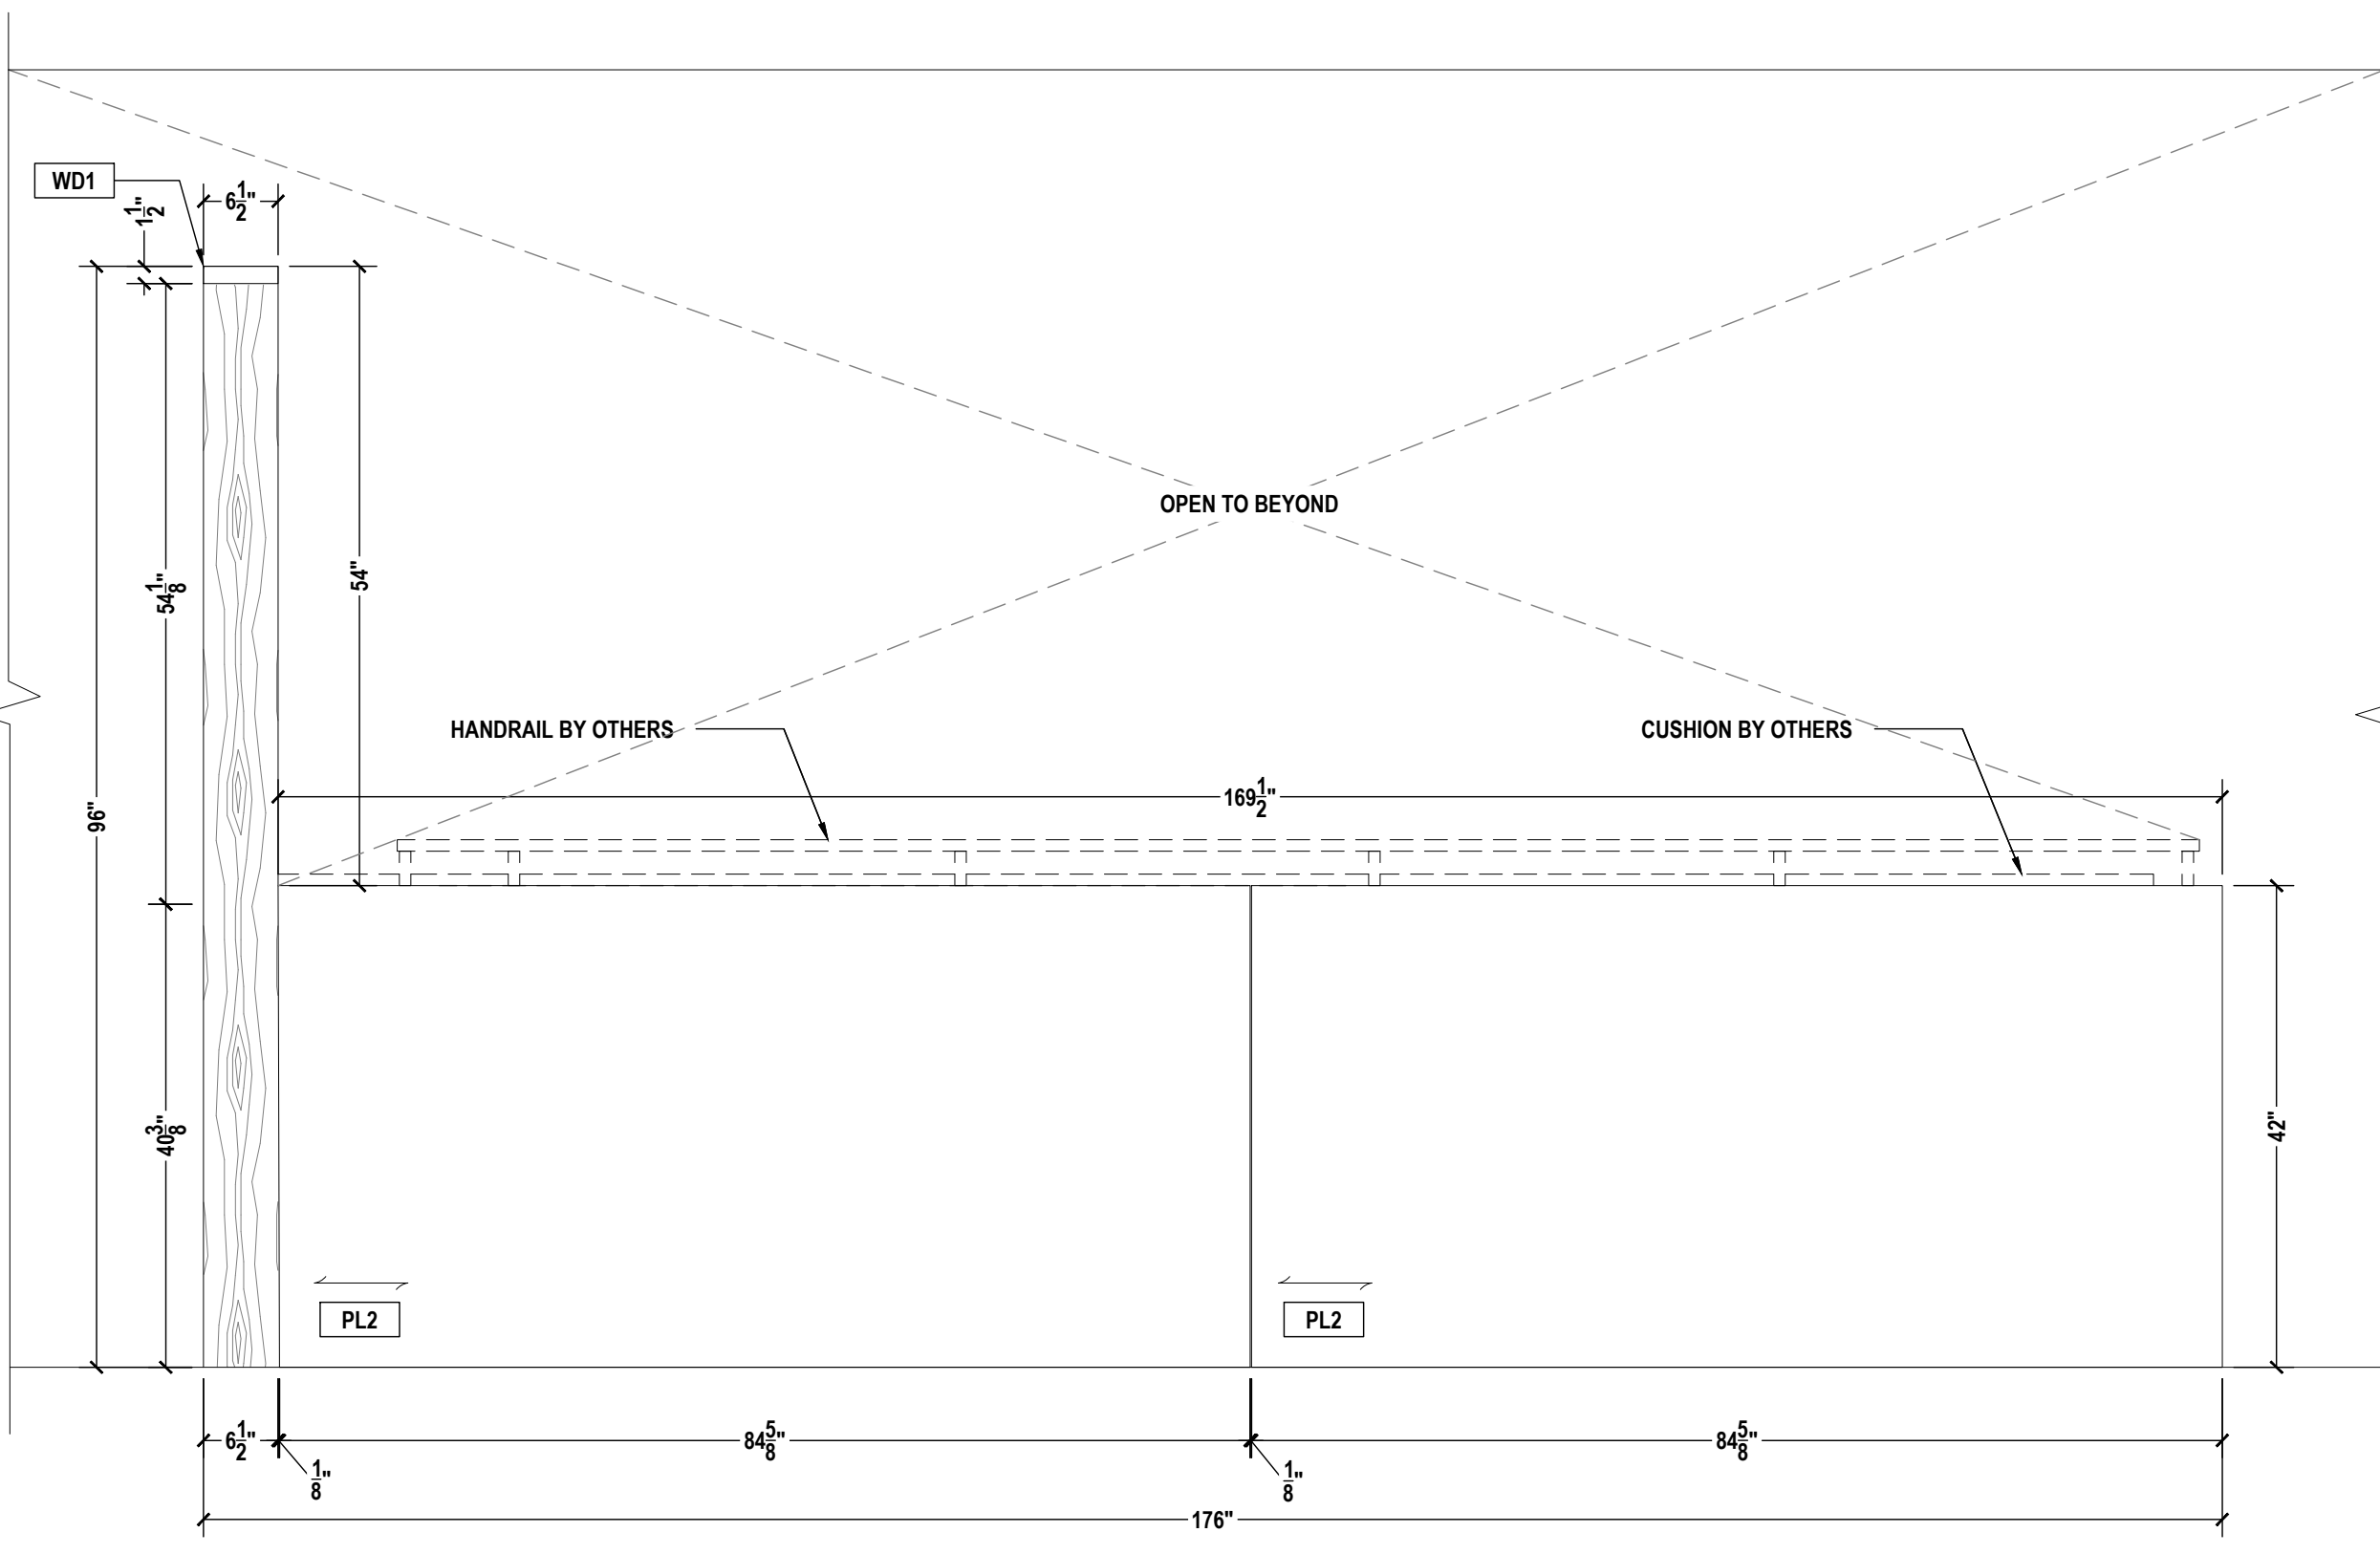

03 LOUNGE A103 - BANQUETTE
ELEVATION
SCALE: 3/4"=1'-0" ARCH REF.: A3/A603

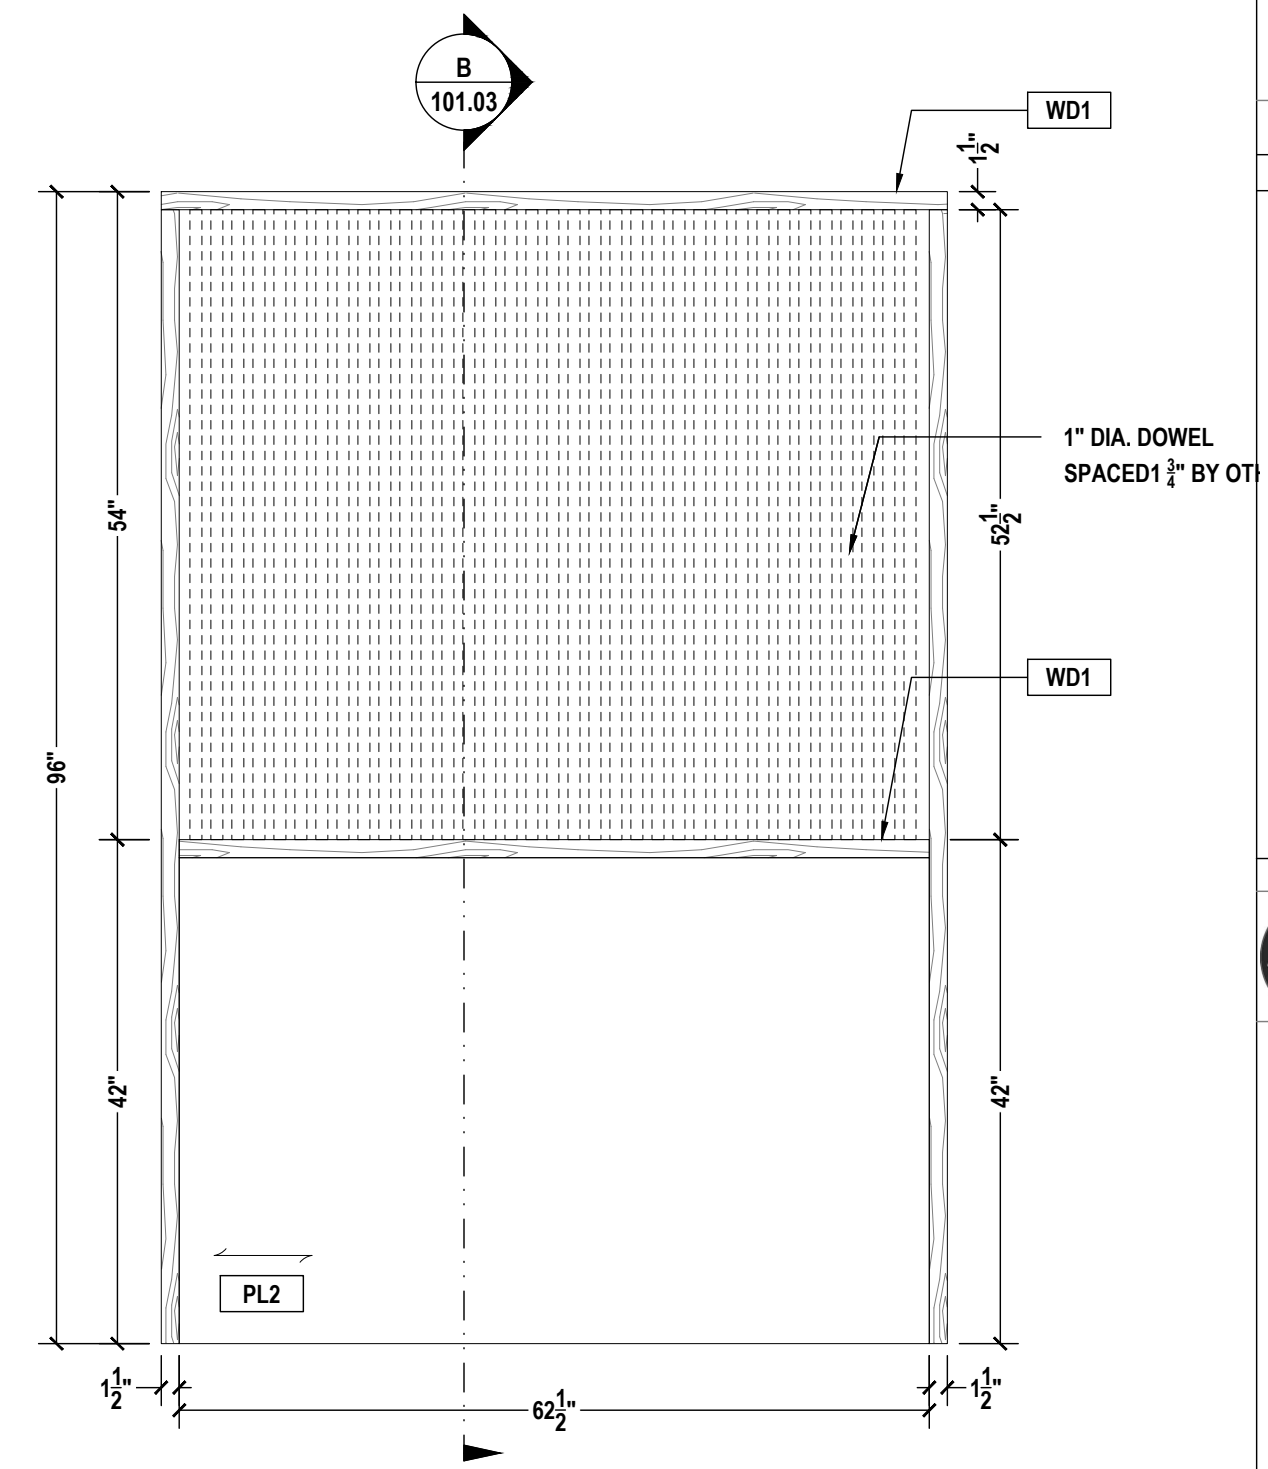

04 LOUNGE A103 - BANQUETTE
ELEVATION
SCALE: 3/4"=1'-0" ARCH REF.: A4/A603

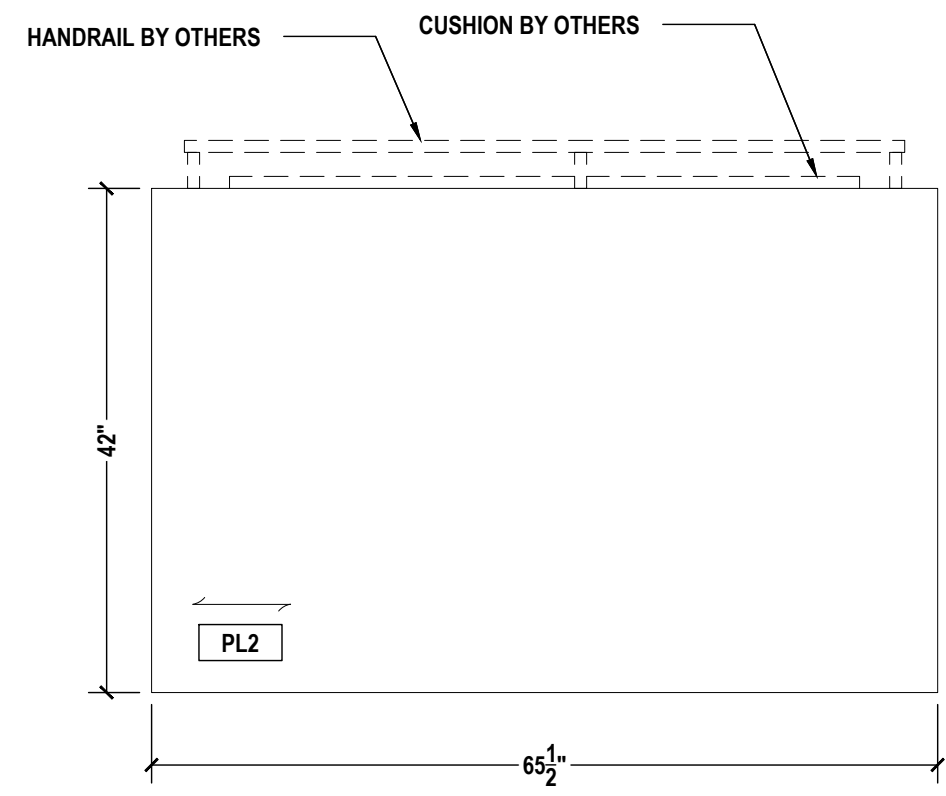

05 LOUNGE A103 - BANQUETTE
ELEVATION
SCALE: 3/4"=1'-0" ARCH REF.: A5/A603

PROJECT:
SAMPLE DRAWINGS

PROJECT ADDRESS:
ORANGE AVE, NASHVILLE, TN

ARCHITECT:
FREDDY C.

G.C.:
PAOLO P.

	QCP	YES <input checked="" type="checkbox"/>	NO <input type="checkbox"/>
	LEED	YES <input type="checkbox"/>	NO <input checked="" type="checkbox"/>
	FSC	YES <input type="checkbox"/>	NO <input checked="" type="checkbox"/>
	NAUF	YES <input type="checkbox"/>	NO <input checked="" type="checkbox"/>

FINISHES:


PLASTIC LAMINATE	
KEY	COLOR
PL2	WILSONART - WALNUT HEIGHT, 7965K-12K
VENEER	
KEY	COLOR
WD1	VENEER TO MATCH PL2

PM:	ERW
DRAWN BY:	TMS
DATE DRAWN:	02/10/2023
REVIEWED BY:	LCT (LOC)


REVISIONS:

No.	DATE:	DESCRIPTIONS:	BY:
△	-	-	-
△	-	-	-
△	-	-	-
△	-	-	-
△	-	-	-
△	-	-	-
△	-	-	-
△	-	-	-


APPROVAL DATE	-
PLOT DATE	07/11/2024
PROJECT NUMBER	P-5567446
ROOM NAME	LOUNGE A103
SHEET NUMBER	101.03

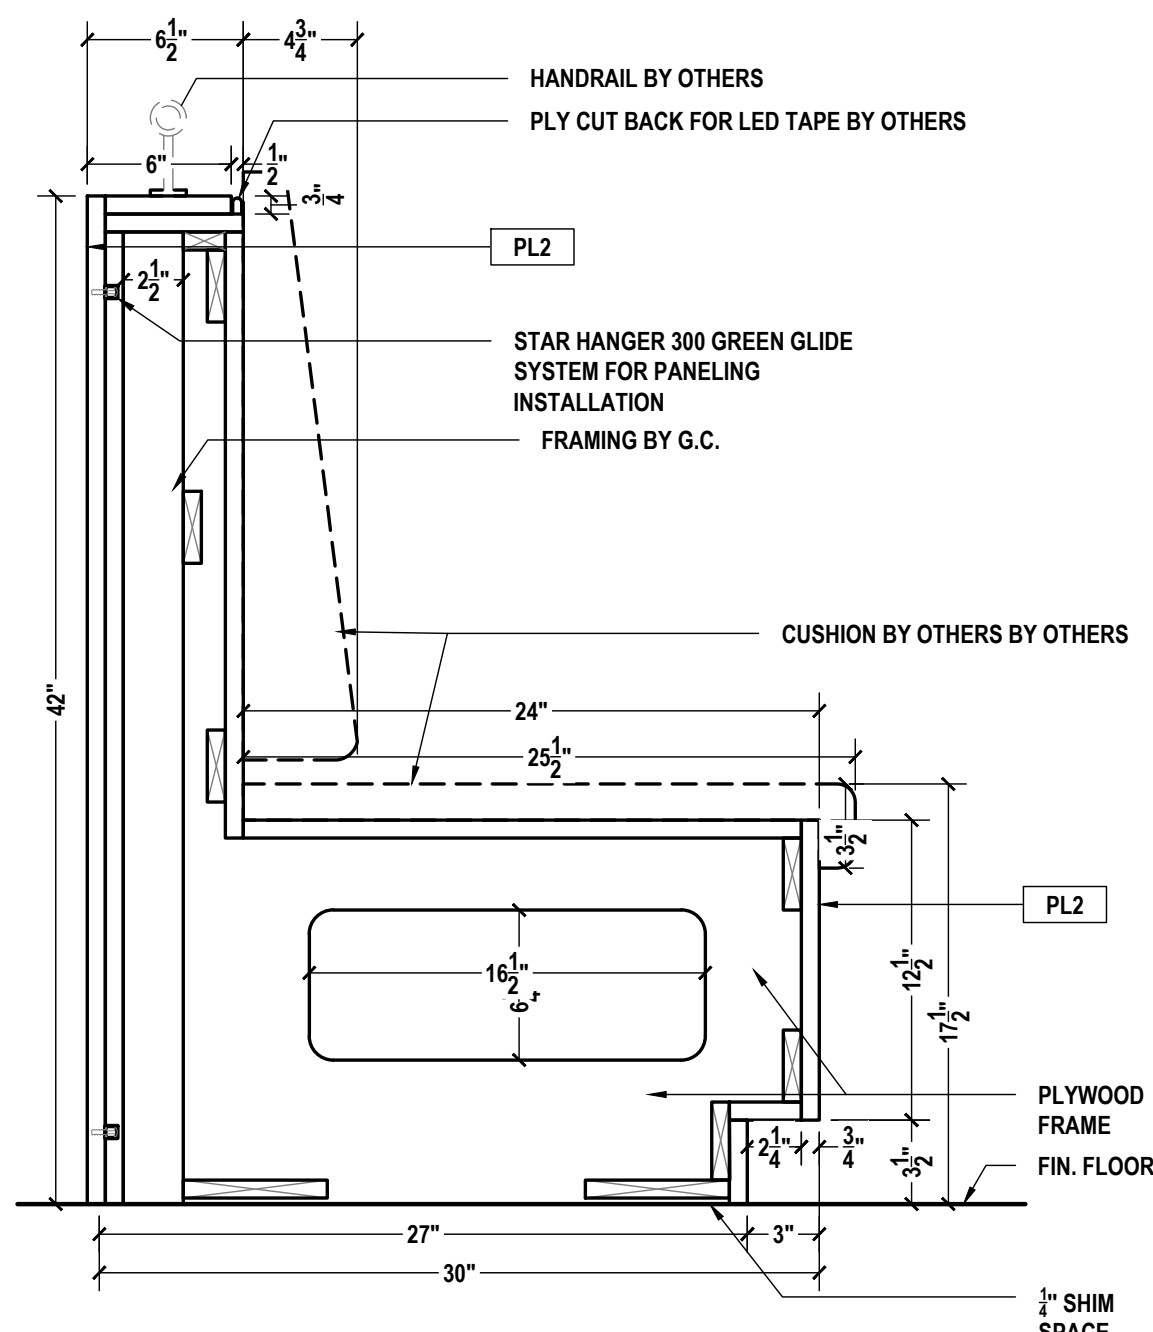

A LOUNGE A103 - BANQUETTE SECTION
SCALE: 1-1/2"=1'-0" ARCH REF.: 12/A604B

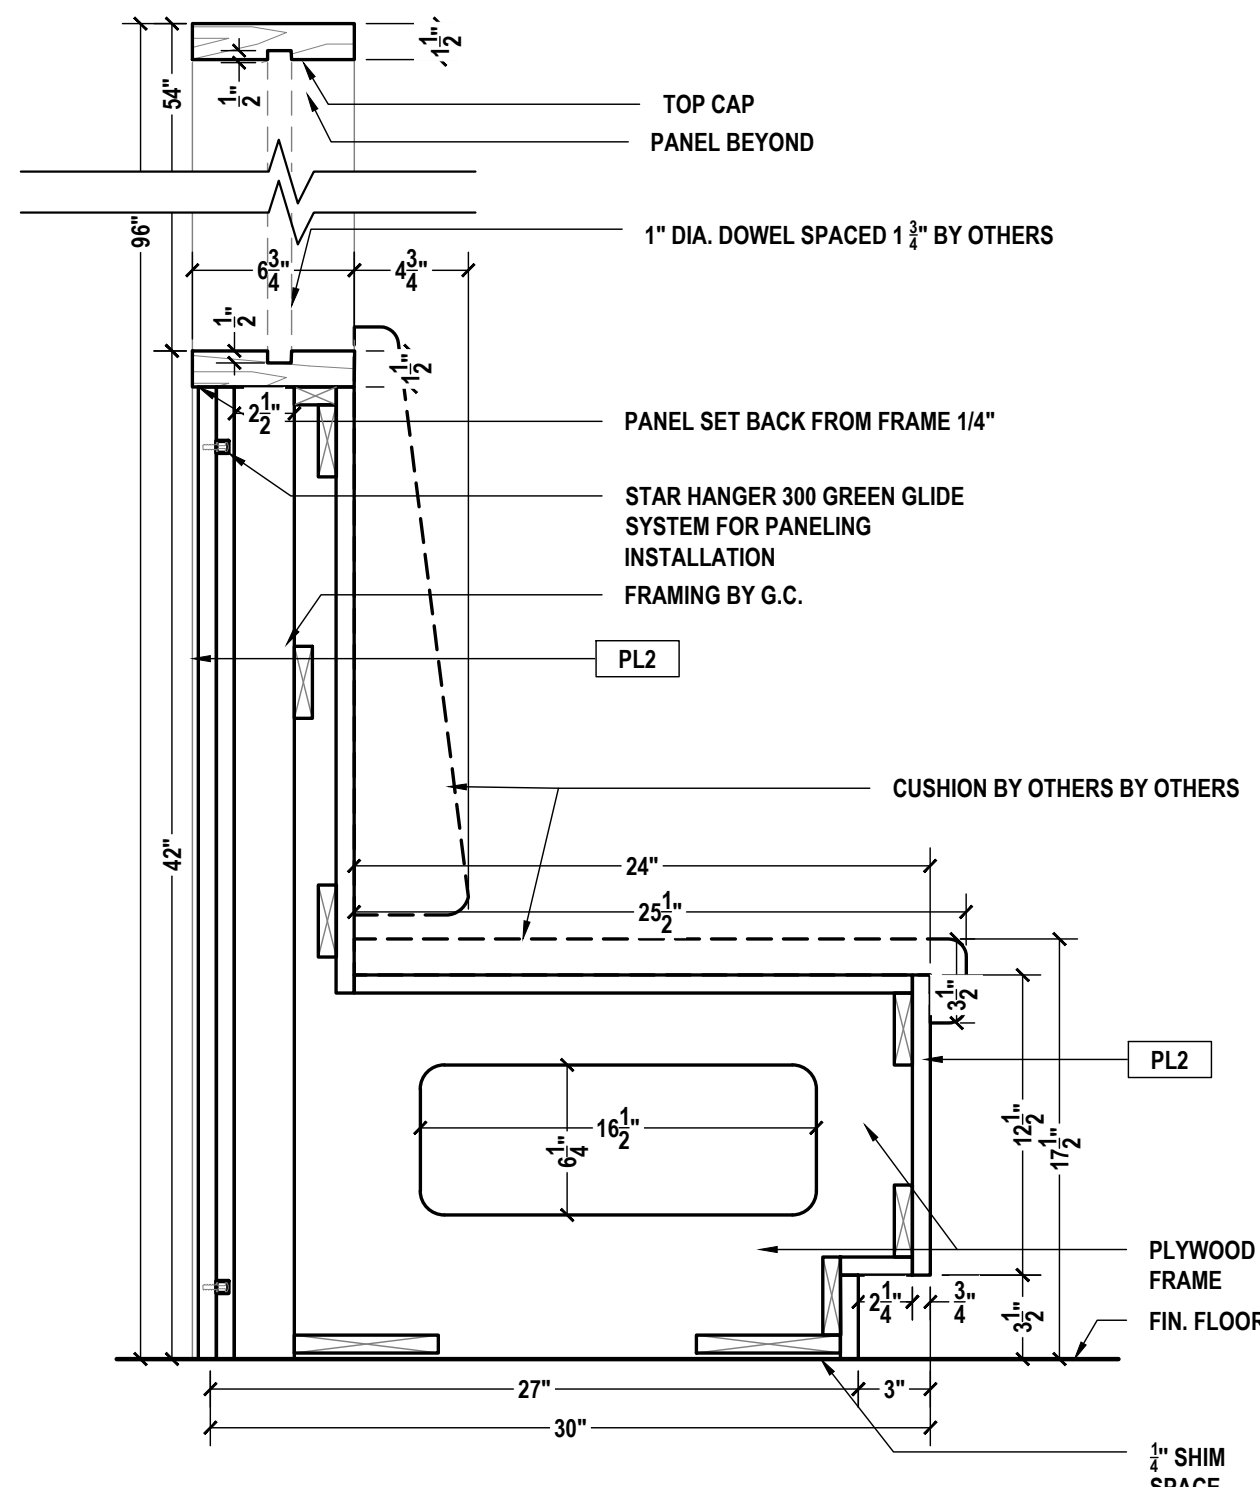

B LOUNGE A103 - BANQUETTE SECTION
SCALE: 1-1/2"=1'-0" ARCH REF.: 13/A604B

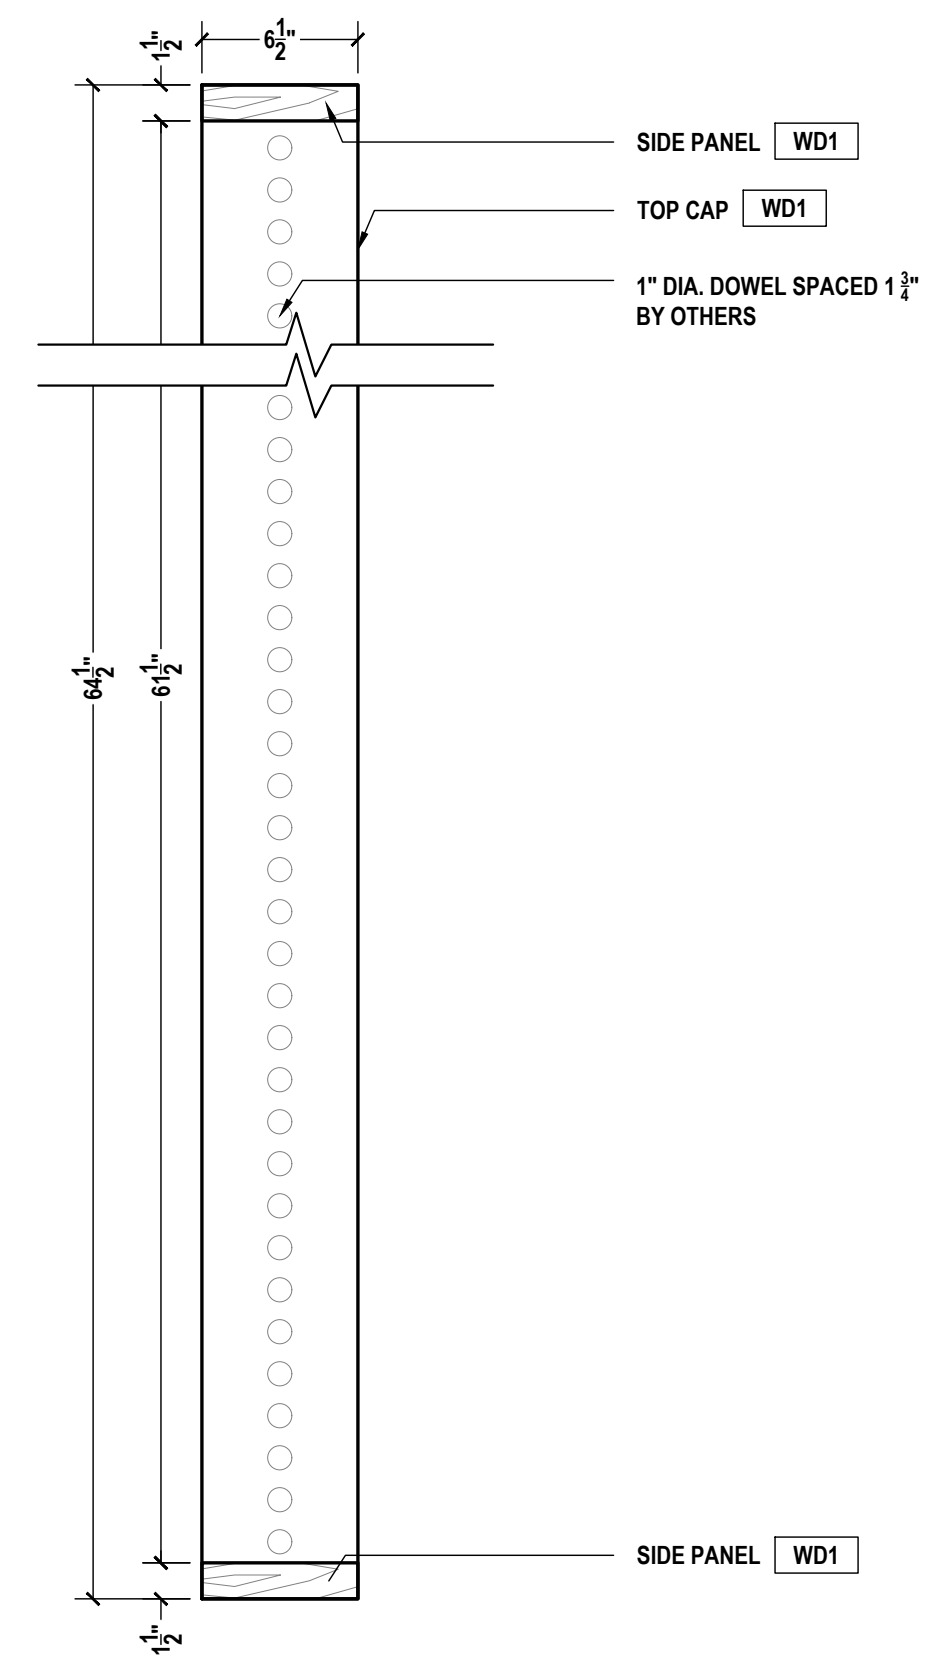

C LOUNGE A103 - BANQUETTE SECTION
SCALE: 1-1/2"=1'-0" ARCH REF.: 14/A604B

PROJECT:
SAMPLE DRAWINGS

PROJECT ADDRESS:
ORANGE AVE, NASHVILLE, TN

ARCHITECT:
FREDDY C.

G.C.:
PAOLO P.

	QCP	YES <input checked="" type="checkbox"/>	NO <input type="checkbox"/>
	LEED	YES <input type="checkbox"/>	NO <input checked="" type="checkbox"/>
	FSC	YES <input type="checkbox"/>	NO <input checked="" type="checkbox"/>
	NAUF	YES <input type="checkbox"/>	NO <input checked="" type="checkbox"/>

FINISHES:


PLASTIC LAMINATE	
KEY	COLOR
PL2	WILSONART - WALNUT HEIGHT, 7965K-12K
VENEER	
KEY	COLOR
WD1	VENEER TO MATCH PL2

PM:	ERW
DRAWN BY:	TMS
DATE DRAWN:	02/10/2023
REVIEWED BY:	LCT (LOC)

REVISIONS:

No.	DATE	DESCRIPTIONS	BY:
△	-	-	-
△	-	-	-
△	-	-	-
△	-	-	-
△	-	-	-
△	-	-	-
△	-	-	-
△	-	-	-

APPROVAL DATE	-
PLOT DATE	07/11/2024
PROJECT NUMBER	P-5567446
ROOM NAME	LOUNGE A103
SHEET NUMBER	101.04

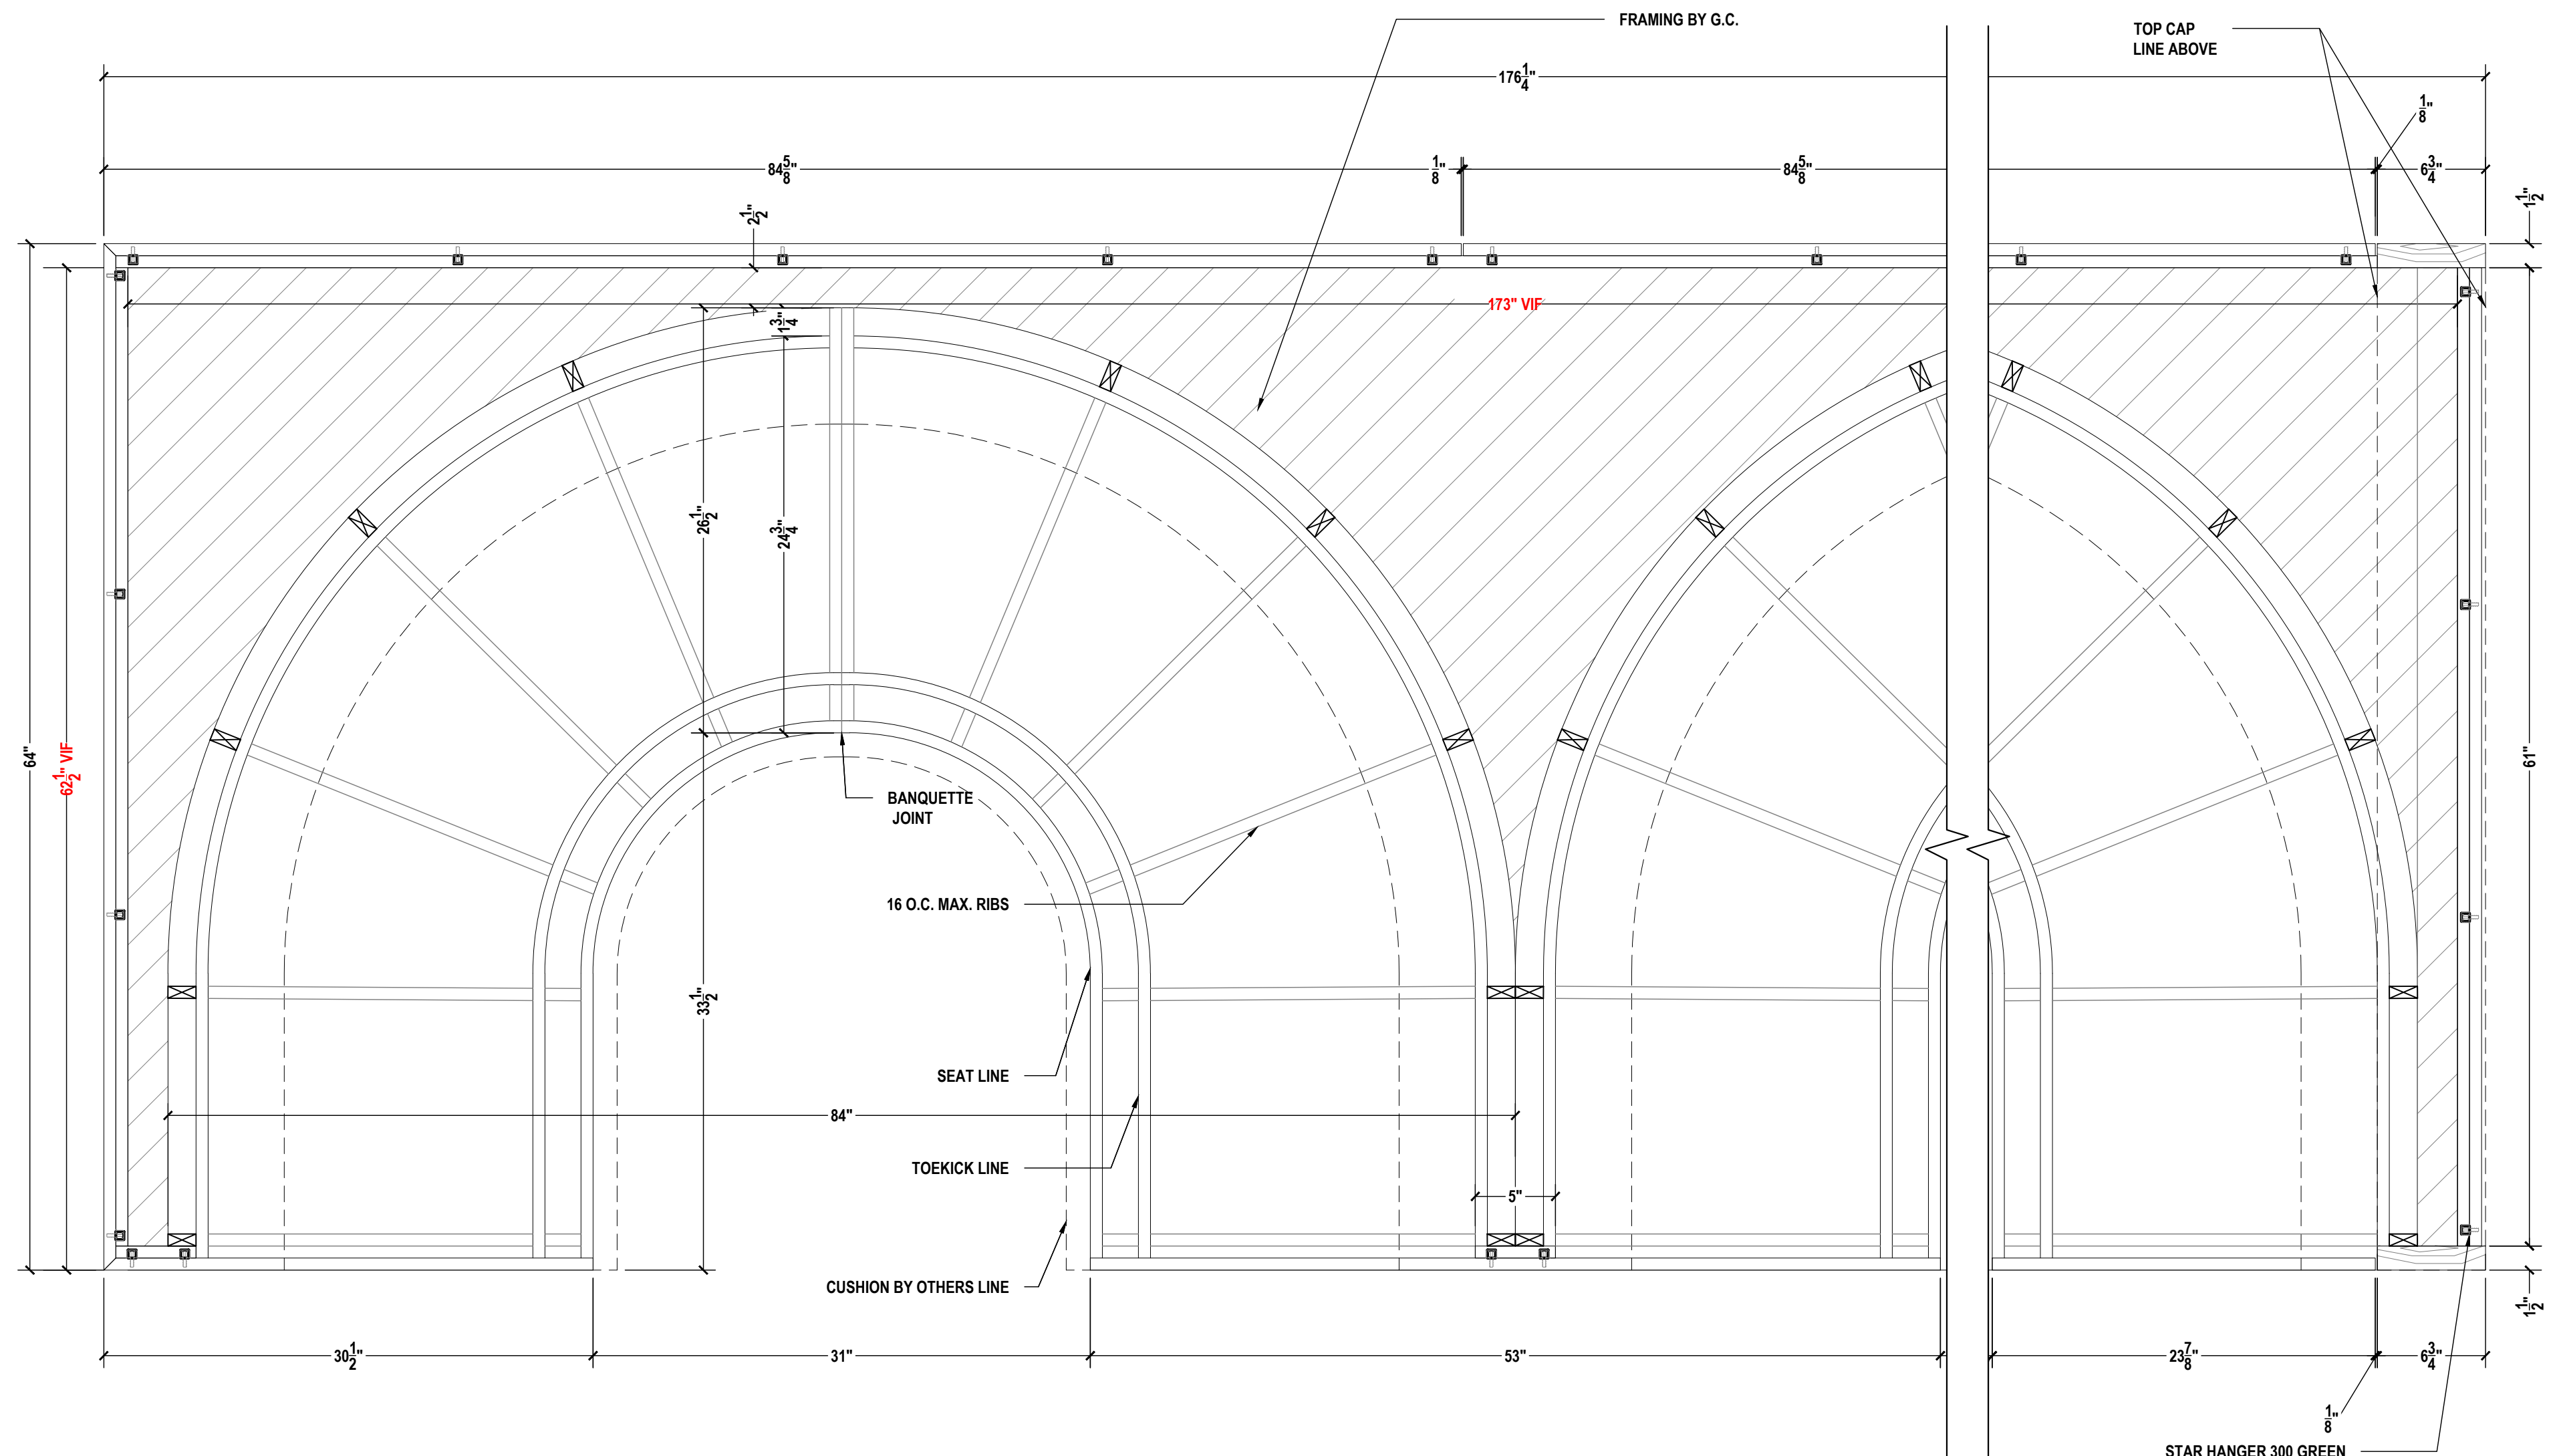

D LOUNGE A103 - BANQUETTE
PLAN SECTION
SCALE: 1-1/2"=1'-0" ARCH REF.: N/A

PROJECT:
SAMPLE DRAWINGS

PROJECT ADDRESS:
ORANGE AVE, NASHVILLE, TN

ARCHITECT:
FREDDY C.

G.C.:
PAOLO P.

	QCP	YES <input checked="" type="checkbox"/>	NO <input type="checkbox"/>
	LEED	YES <input type="checkbox"/>	NO <input checked="" type="checkbox"/>
	FSC	YES <input type="checkbox"/>	NO <input checked="" type="checkbox"/>
	NAUF	YES <input type="checkbox"/>	NO <input checked="" type="checkbox"/>

FINISHES:


KEY	VENEER	COLOR
WD1	VENEER TO MATCH PL2	
WD2	WHITE OAK, PROFILE T318 RUBIO MONOCOAR	

PM:	ERW
DRAWN BY:	TMS
DATE DRAWN:	02/10/2023
REVIEWED BY:	LCT (LOC)


REVISIONS:

No.	DATE	DESCRIPTIONS	BY:
△	-	-	-
△	-	-	-
△	-	-	-
△	-	-	-
△	-	-	-
△	-	-	-
△	-	-	-

APPROVAL DATE	-
PLOT DATE	07/11/2024
PROJECT NUMBER	P-5567446
ROOM NAME	LOBBY A105
SHEET NUMBER	102.01

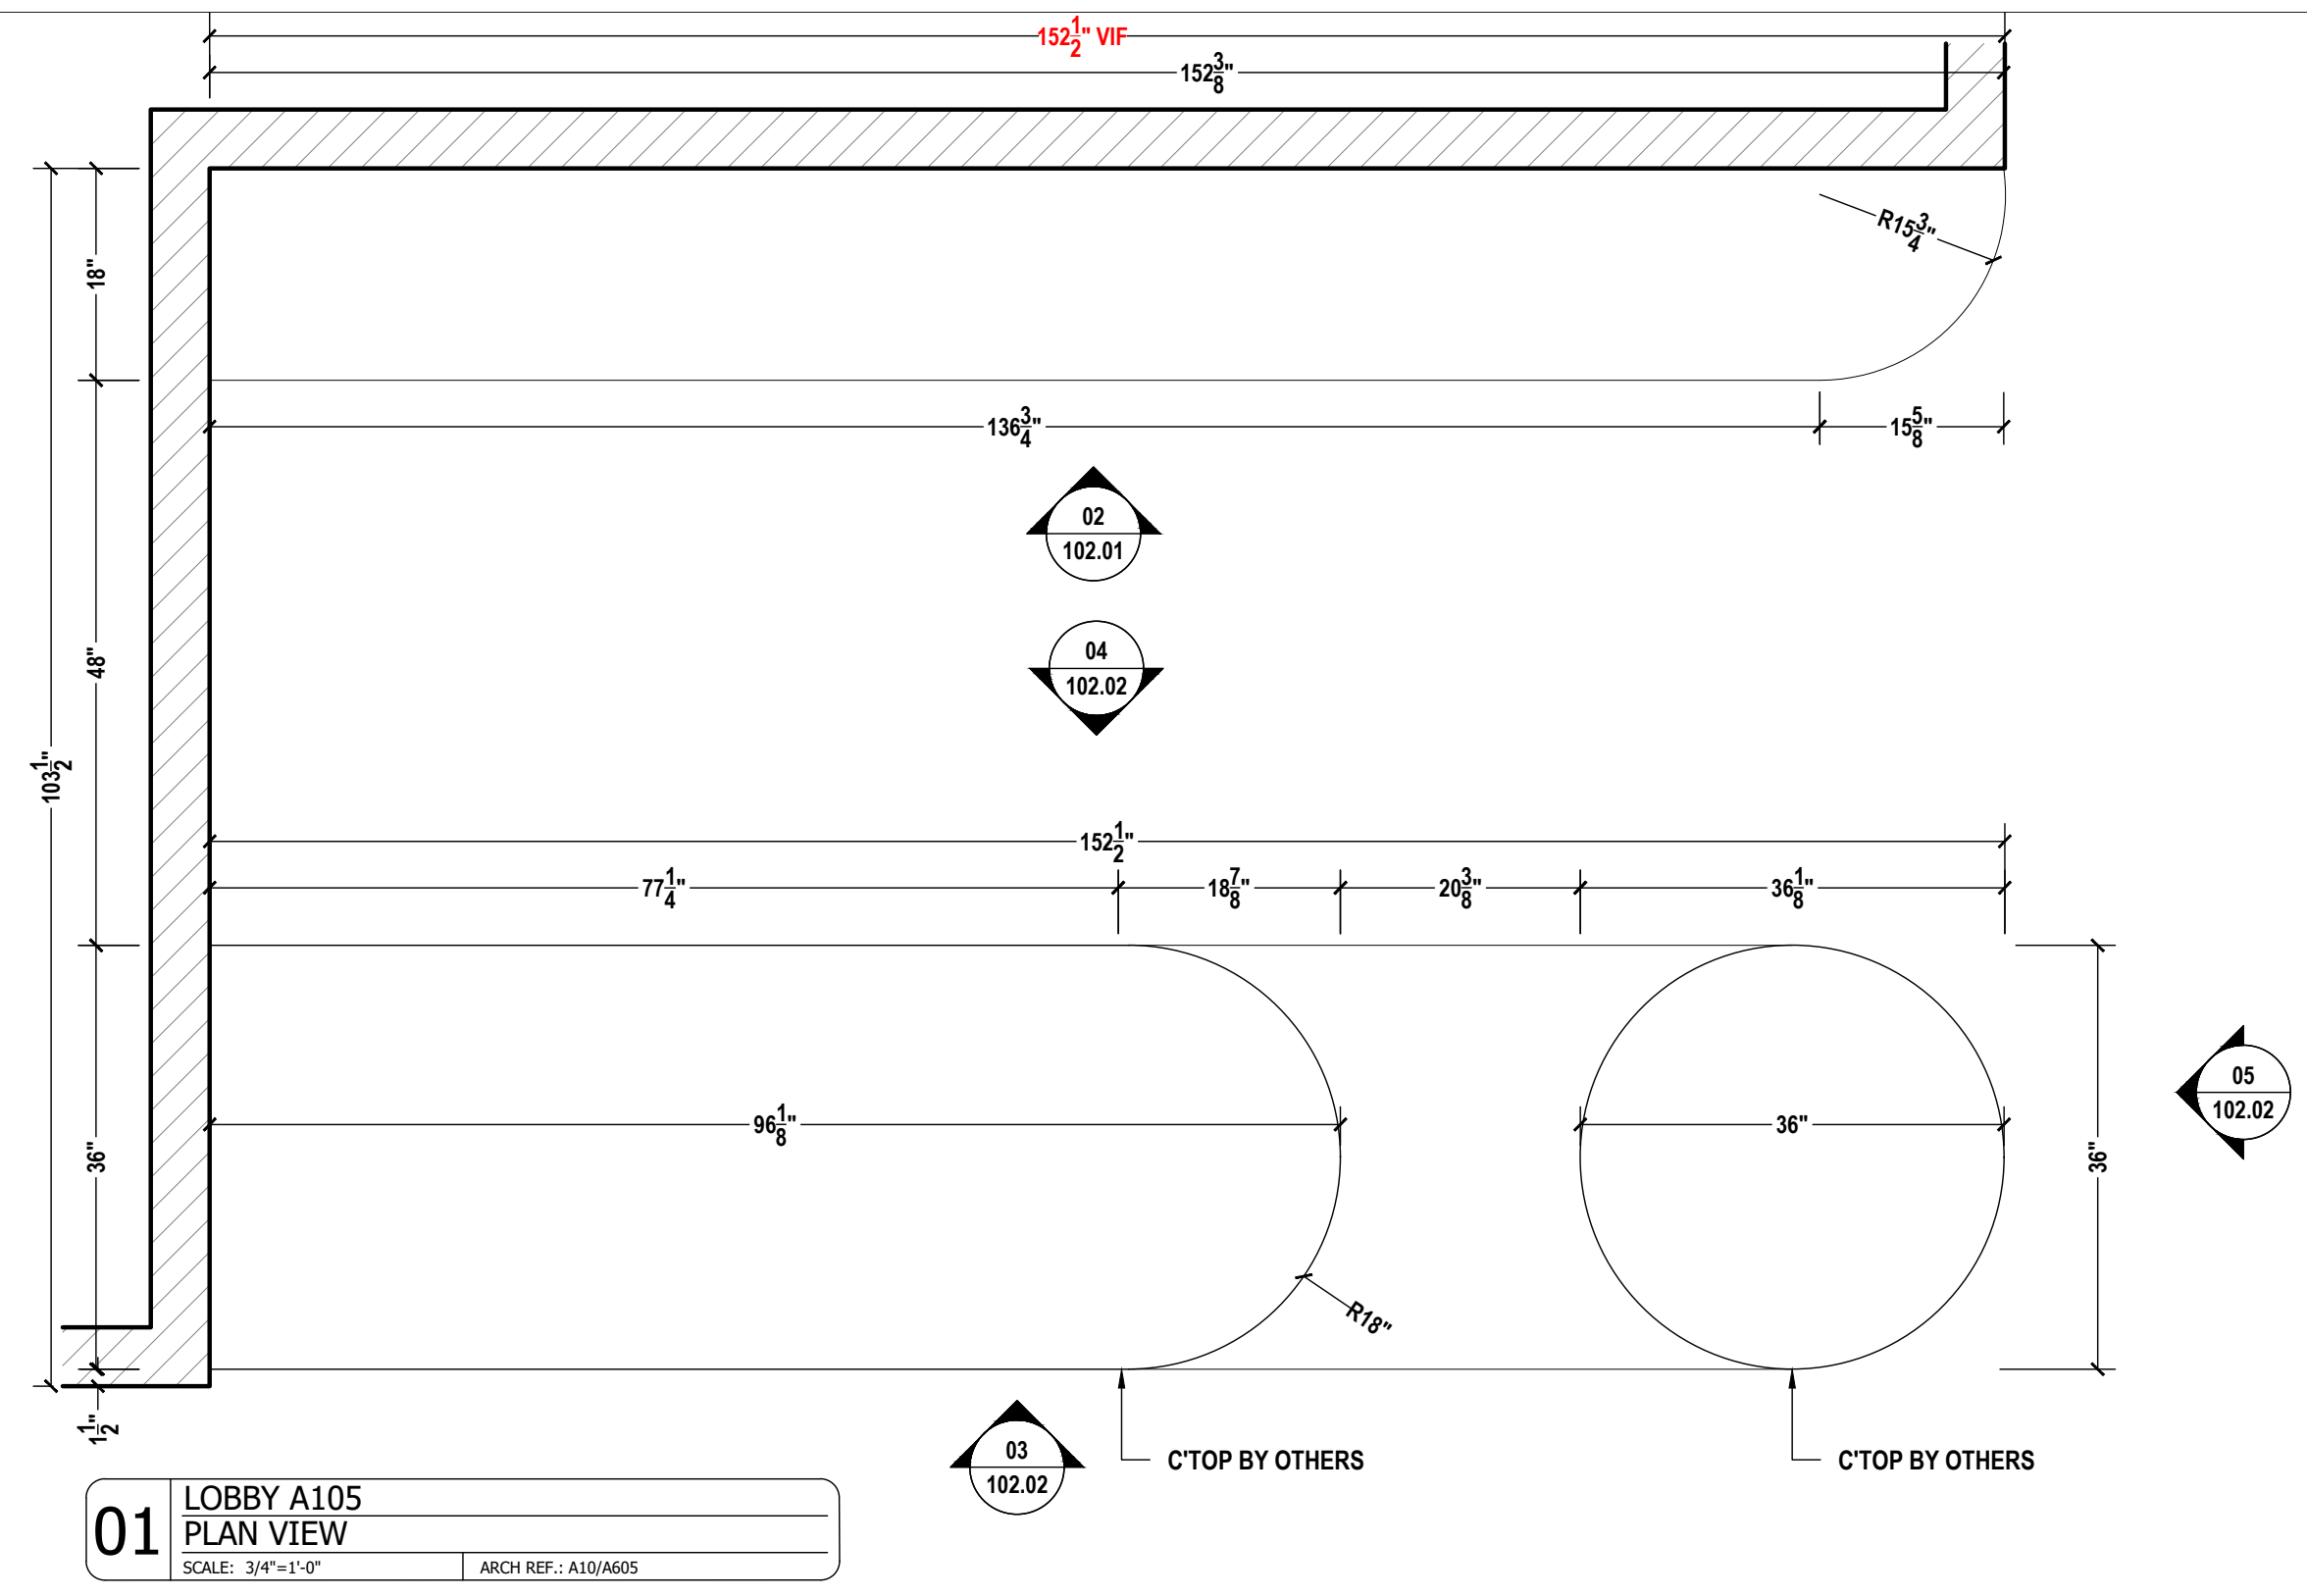

01 LOBBY A105
PLAN VIEW
SCALE: 3/4"=1'-0" ARCH REF.: A10/A605

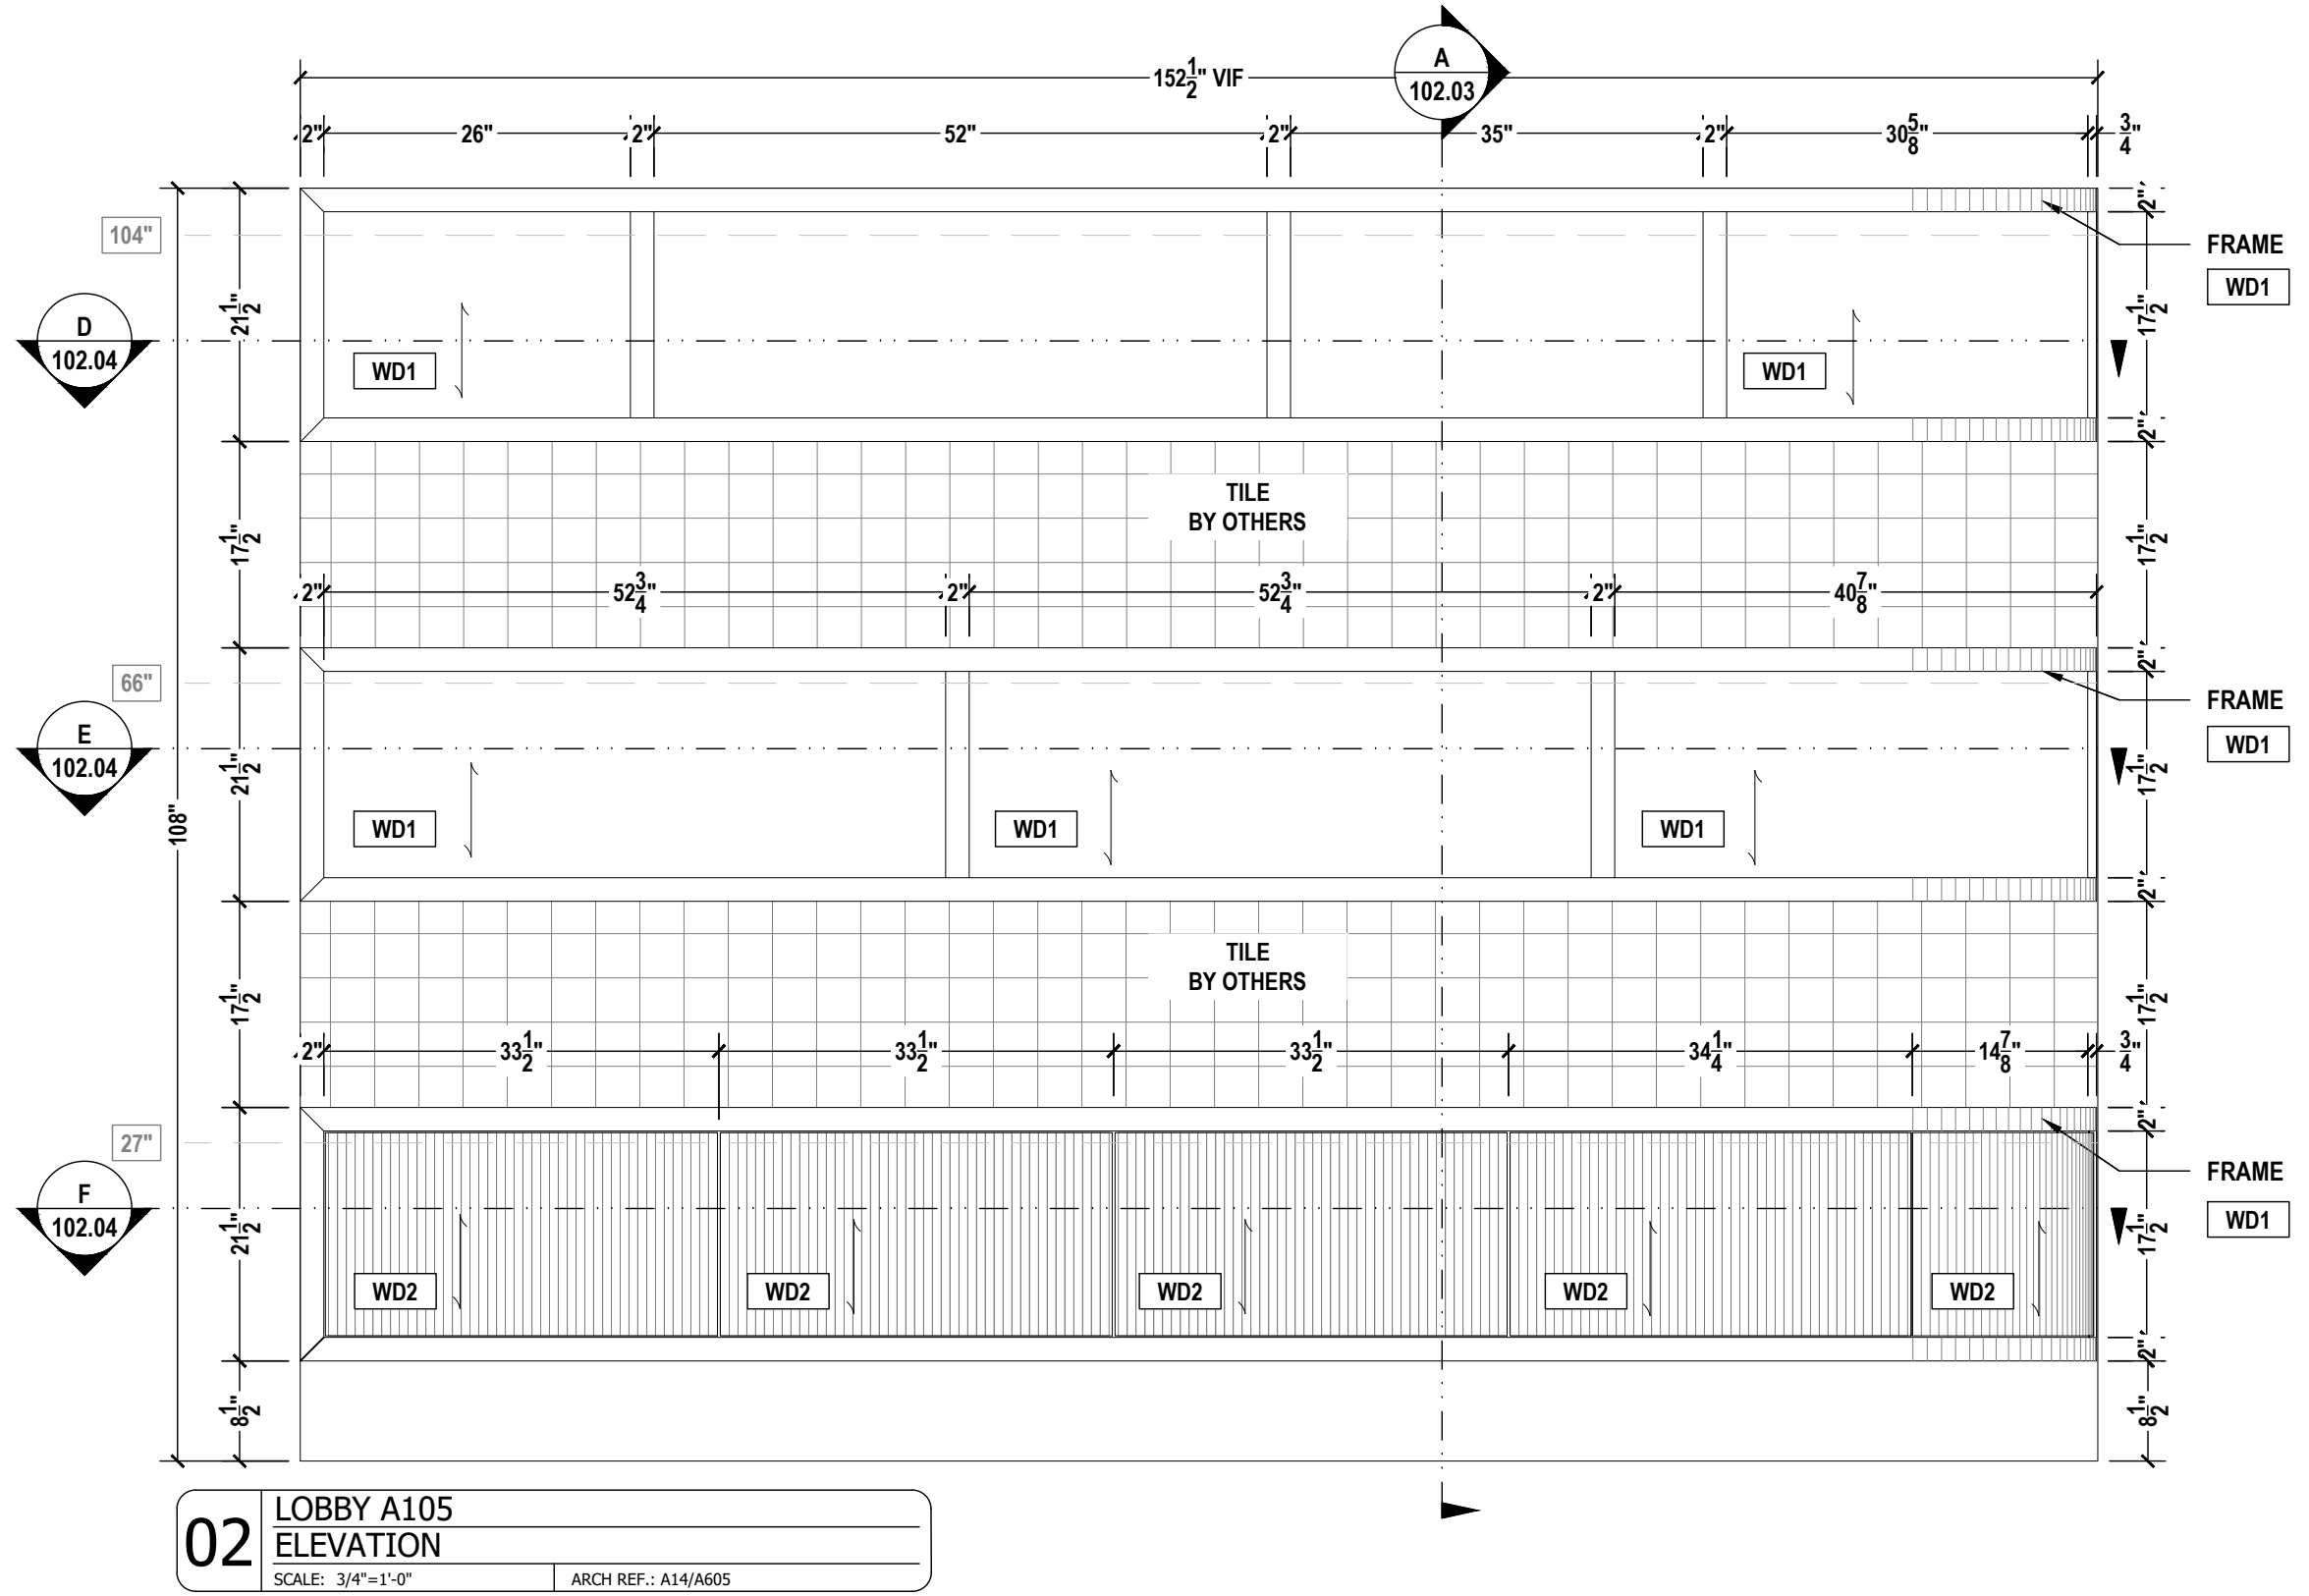

02 LOBBY A105
ELEVATION
SCALE: 3/4"=1'-0" ARCH REF.: A14/A605

**** NOTE TO ARCH AND G.C. ****
 REFERENCE RFI LIST ON SHEET 1CS.02
 PLEASE PROVIDE WD2 SPECIFICATIONS.



678 Orange Ave Orlando, FL 32804
 www.themillworkstudio.com

PROJECT:
SAMPLE DRAWINGS

PROJECT ADDRESS:
 ORANGE AVE, NASHVILLE, TN

ARCHITECT:
 FREDDY C.

G.C.:
 PAOLO P.

	QCP	YES <input checked="" type="checkbox"/>	NO <input type="checkbox"/>
	LEED	YES <input type="checkbox"/>	NO <input checked="" type="checkbox"/>
	FSC	YES <input type="checkbox"/>	NO <input checked="" type="checkbox"/>
	NAUF	YES <input type="checkbox"/>	NO <input checked="" type="checkbox"/>

FINISHES:


KEY	VENEER	COLOR
WD1	VENEER TO MATCH PL2	
WD2	WHITE OAK, PROFILE T318 RUBIO MONOCOAR	

PM:	ERW
DRAWN BY:	TMS
DATE DRAWN:	02/10/2023
REVIEWED BY:	LCT (LOC)


REVISIONS:

No.	DATE:	DESCRIPTIONS:	BY:
△	-	-	-
△	-	-	-
△	-	-	-
△	-	-	-
△	-	-	-
△	-	-	-
△	-	-	-
△	-	-	-


APPROVAL DATE	-
PLOT DATE	07/11/2024
PROJECT NUMBER	P-5567446
ROOM NAME	LOBBY A105
SHEET NUMBER	102.02

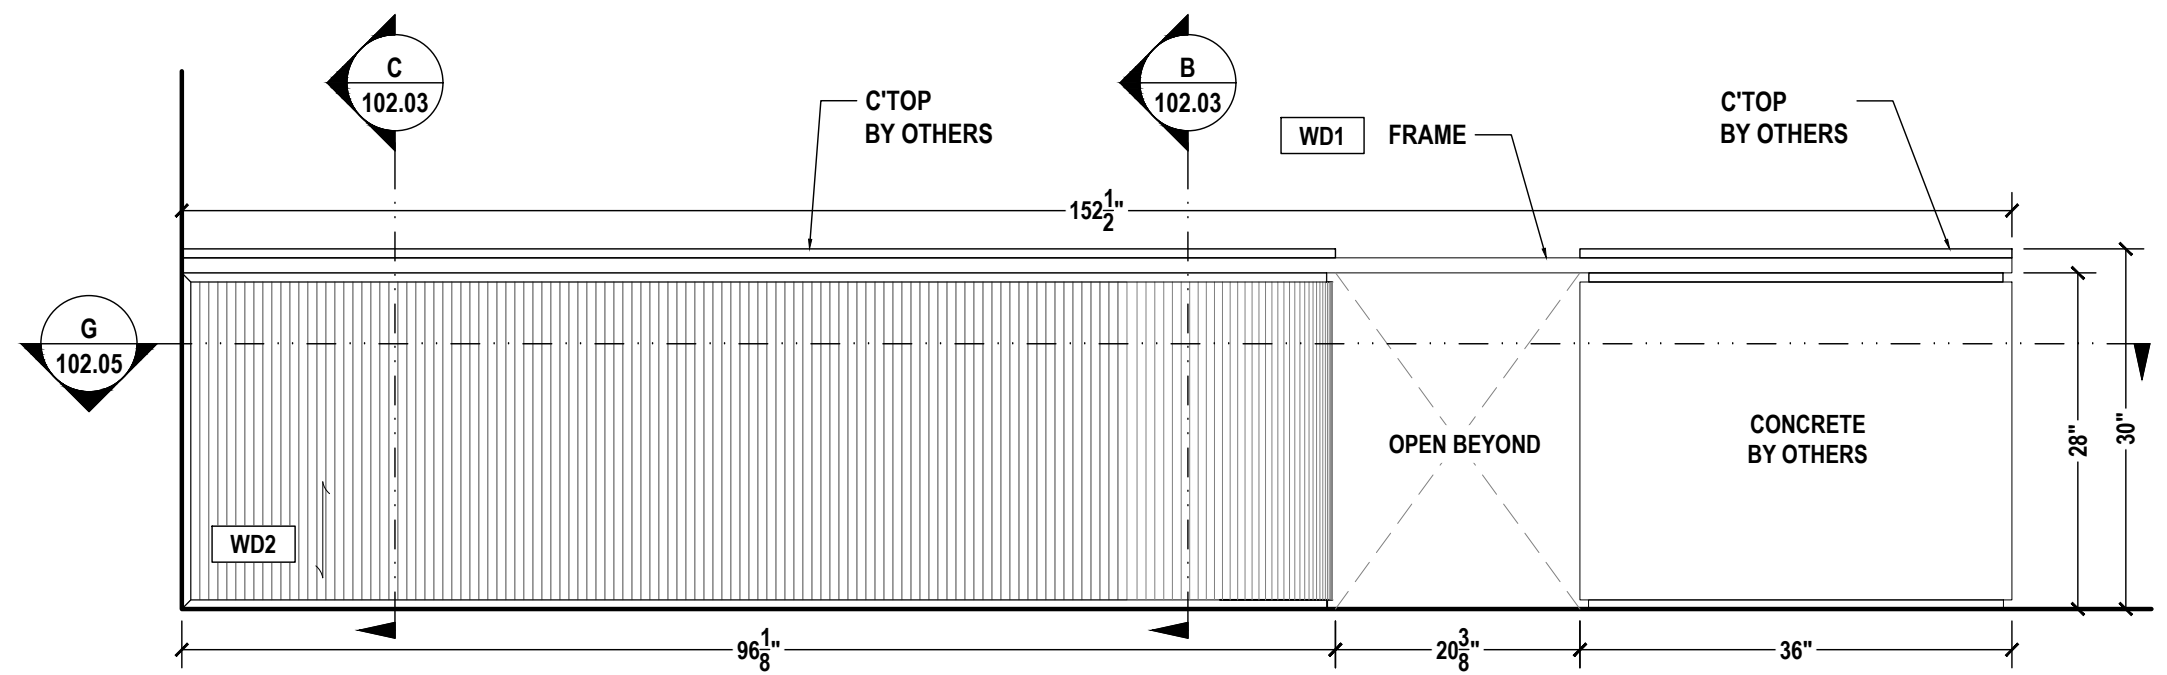

03 LOBBY A105
 PLAN VIEW
 SCALE: 3/4"=1'-0" ARCH REF.: A11/A605

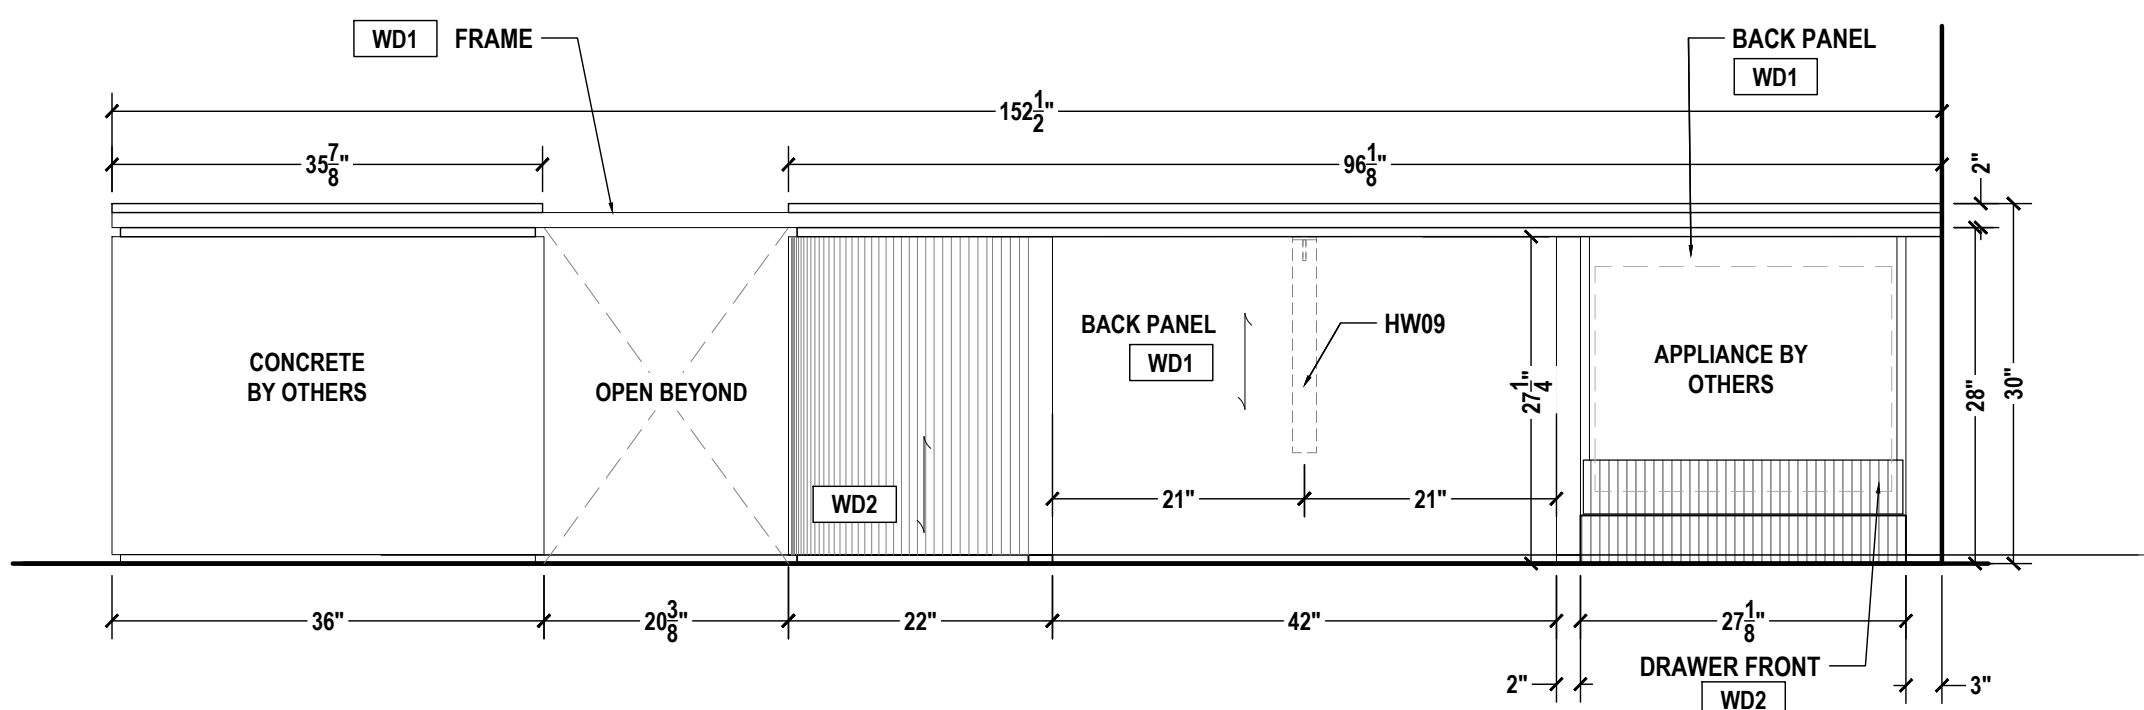

04 LOBBY A105
 PLAN VIEW
 SCALE: 3/4"=1'-0" ARCH REF.: A13/A605

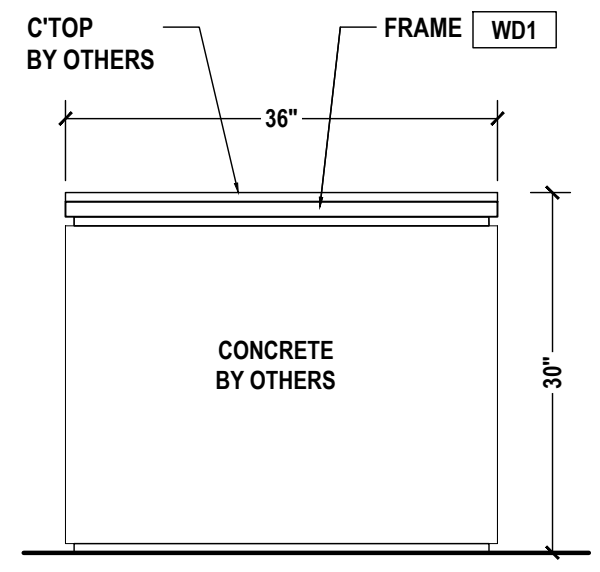

05 LOBBY A105
 PLAN VIEW
 SCALE: 3/4"=1'-0" ARCH REF.: A12/A605

PROJECT:
SAMPLE DRAWINGS

PROJECT ADDRESS:
ORANGE AVE, NASHVILLE, TN

ARCHITECT:
FREDDY C.

G.C.:
PAOLO P.

	QCP	YES <input checked="" type="checkbox"/>	NO <input type="checkbox"/>
	LEED	YES <input type="checkbox"/>	NO <input checked="" type="checkbox"/>
	FSC	YES <input type="checkbox"/>	NO <input checked="" type="checkbox"/>
	NAUF	YES <input type="checkbox"/>	NO <input checked="" type="checkbox"/>

FINISHES:


KEY	VENEER	COLOR
WD1	VENEER TO MATCH PL2	
WD2	WHITE OAK, PROFILE 1518 RUBIO MONOCOAR	

PM:	ERW
DRAWN BY:	TMS
DATE DRAWN:	02/10/2023
REVIEWED BY:	LCT (LOC)


REVISIONS:

No.	DATE:	DESCRIPTIONS:	BY:
△	-	-	-
△	-	-	-
△	-	-	-
△	-	-	-
△	-	-	-
△	-	-	-
△	-	-	-


APPROVAL DATE	-
PLOT DATE	07/11/2024
PROJECT NUMBER	P-5567446
ROOM NAME	LOBBY A105
SHEET NUMBER	102.03

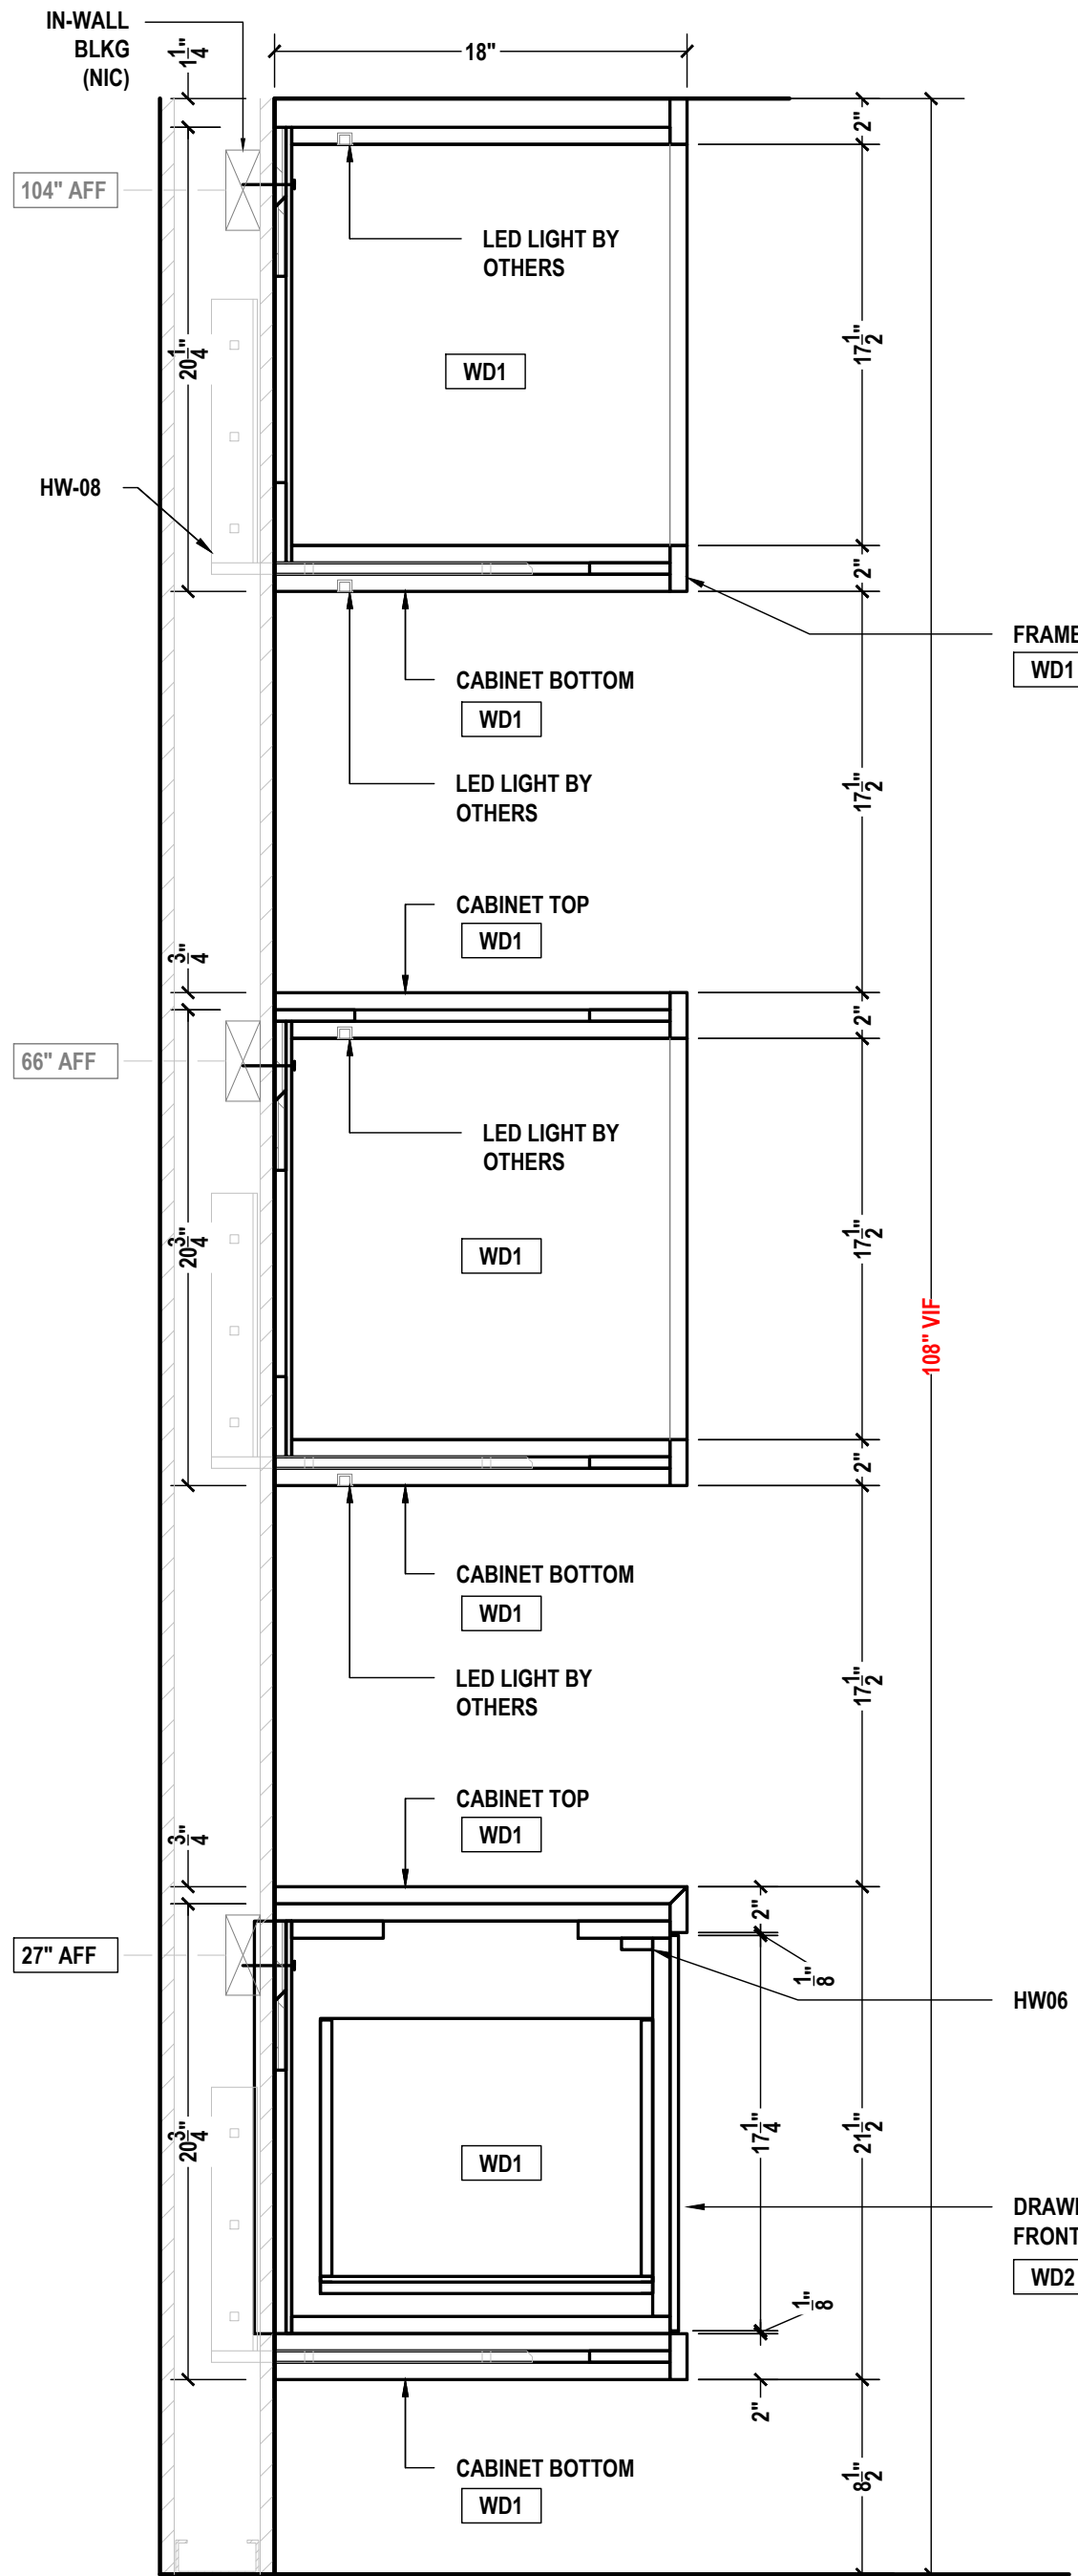

A LOBBY A105 SECTION
SCALE: 1-1/2"=1'-0" ARCH REF.: 15/A604B

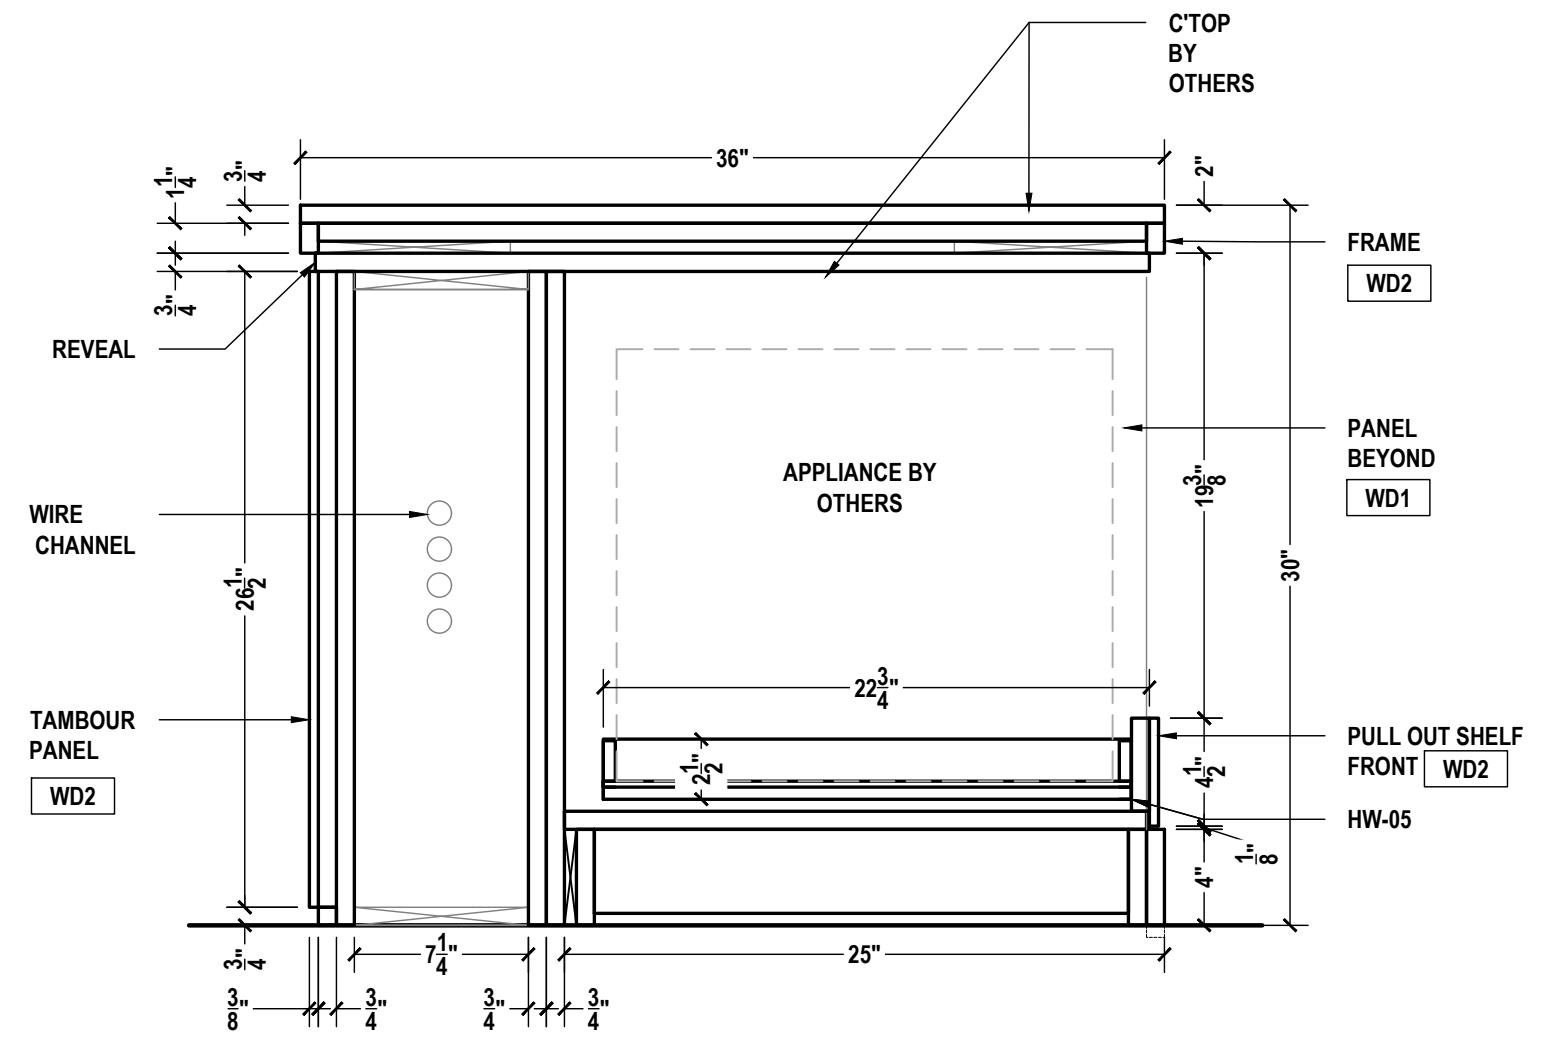

C LOBBY A105 SECTION
SCALE: 1-1/2"=1'-0" ARCH REF.: 17/A604B

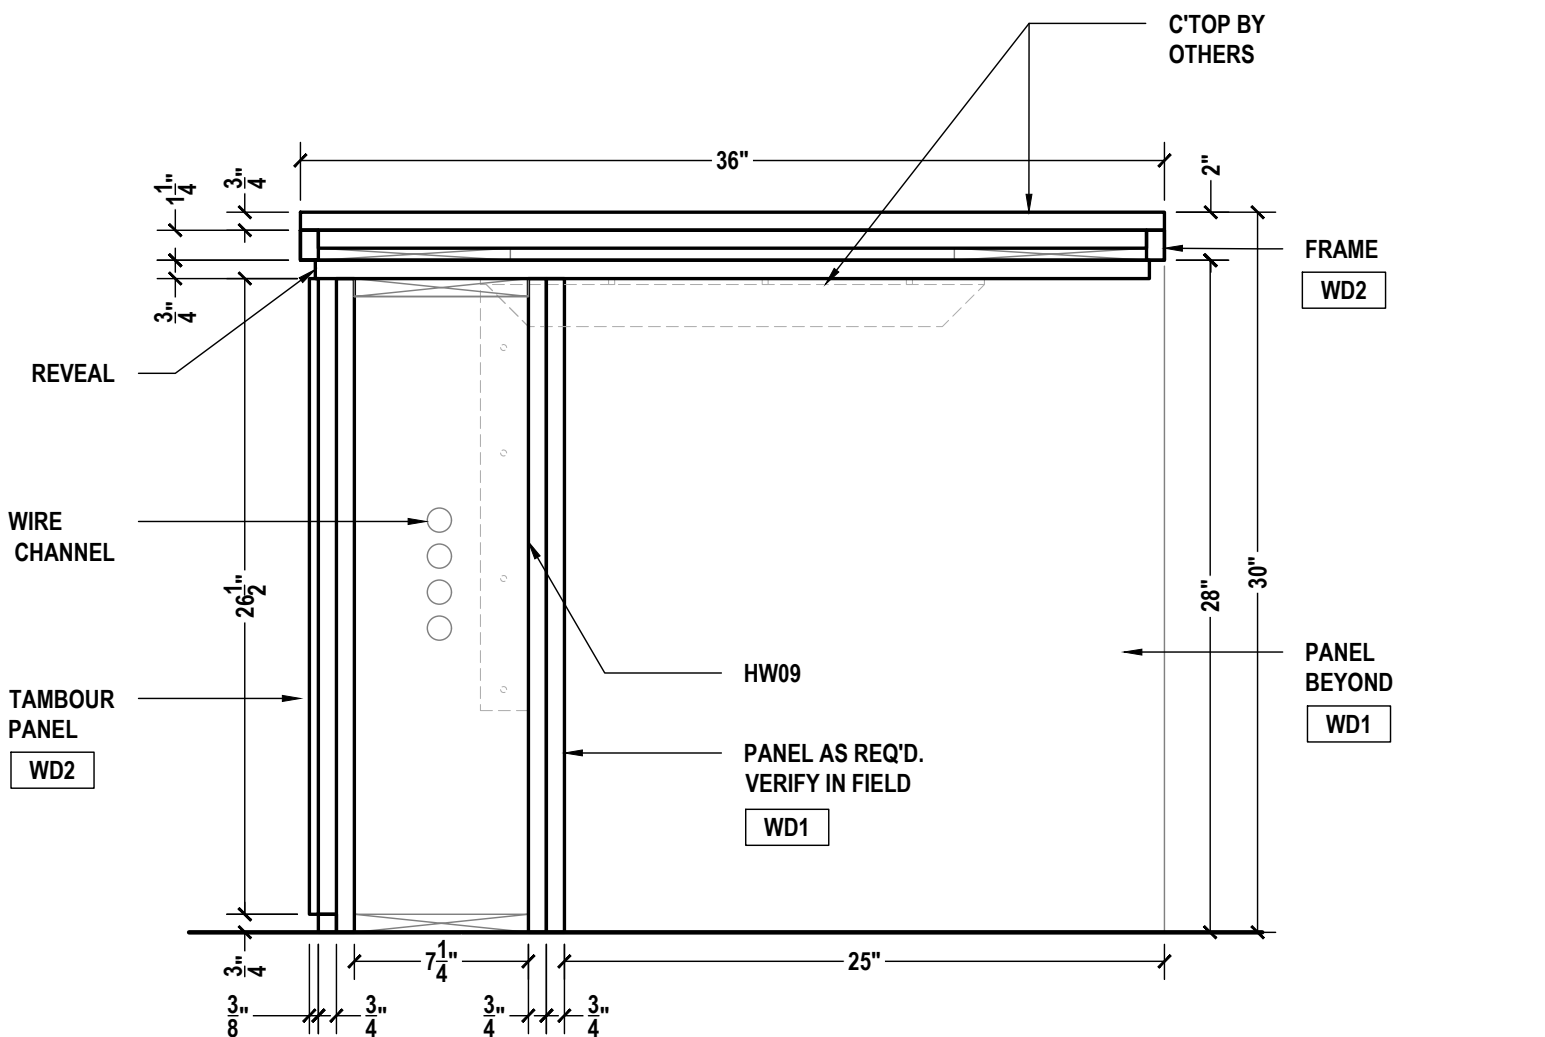

B LOBBY A105 SECTION
SCALE: 1-1/2"=1'-0" ARCH REF.: 16/A604B

PROJECT:
SAMPLE DRAWINGS

PROJECT ADDRESS:
ORANGE AVE, NASHVILLE, TN

ARCHITECT:
FREDDY C.

G.C.:
PAOLO P.

	QCP	YES <input checked="" type="checkbox"/>	NO <input type="checkbox"/>
	LEED	YES <input type="checkbox"/>	NO <input checked="" type="checkbox"/>
	FSC	YES <input type="checkbox"/>	NO <input checked="" type="checkbox"/>
	NAUF	YES <input type="checkbox"/>	NO <input checked="" type="checkbox"/>

FINISHES:


KEY	VENEER	COLOR
WD1	VENEER TO MATCH PL2	
WD2	WHITE OAK, PROFILE T318 RUBIO MONOCOR.	

PM:	ERW
DRAWN BY:	TMS
DATE DRAWN:	02/10/2023
REVIEWED BY:	LCT (LOC)


REVISIONS:

No.	DATE	DESCRIPTIONS	BY:
△	-	-	-
△	-	-	-
△	-	-	-
△	-	-	-
△	-	-	-
△	-	-	-
△	-	-	-


APPROVAL DATE	-
PLOT DATE	07/11/2024
PROJECT NUMBER	P-5567446
ROOM NAME	LOBBY A105
SHEET NUMBER	102.04

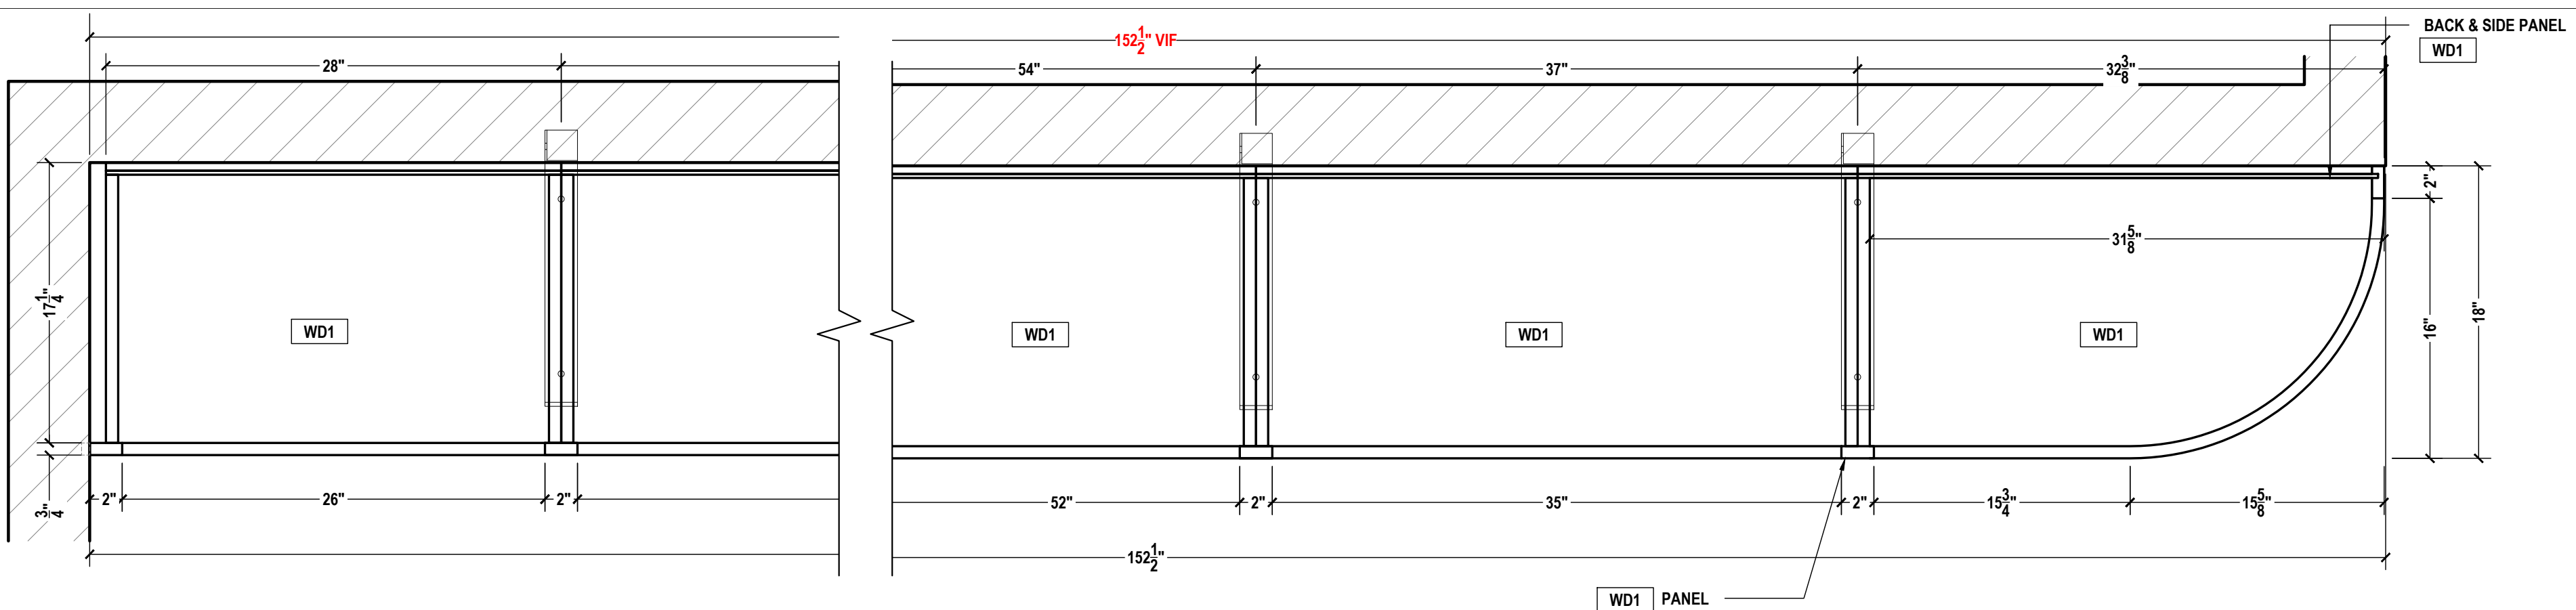

D LOBBY A105
HORIZONTAL SECTION
SCALE: 1-1/2"=1'-0" ARCH REF.: N/A

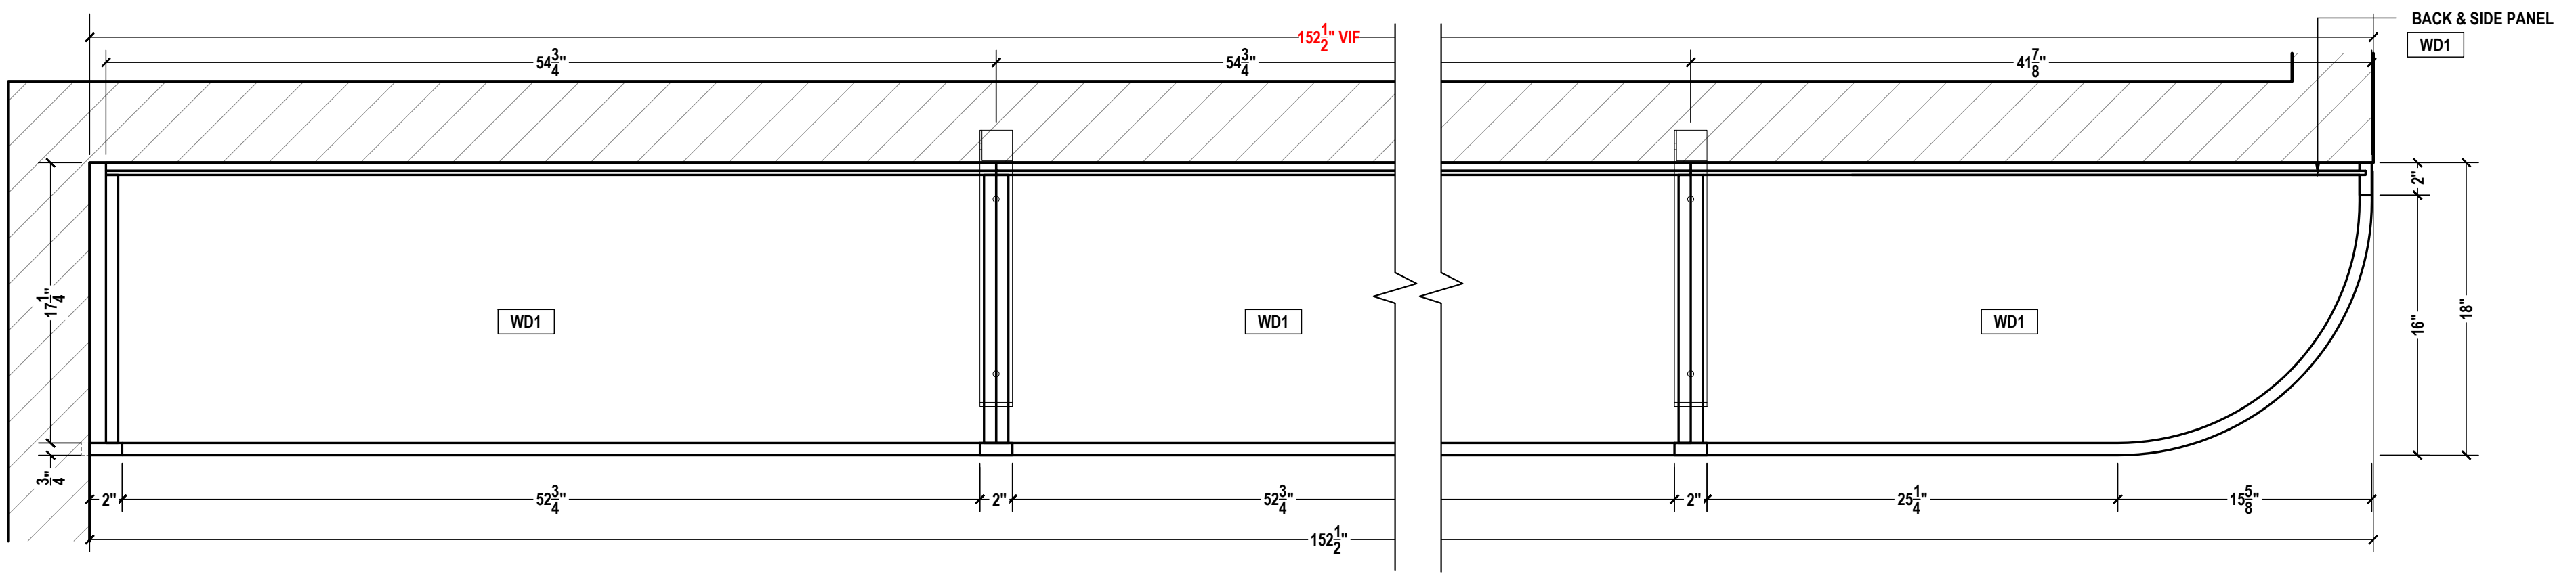

E LOBBY A105
HORIZONTAL SECTION
SCALE: 1-1/2"=1'-0" ARCH REF.: N/A

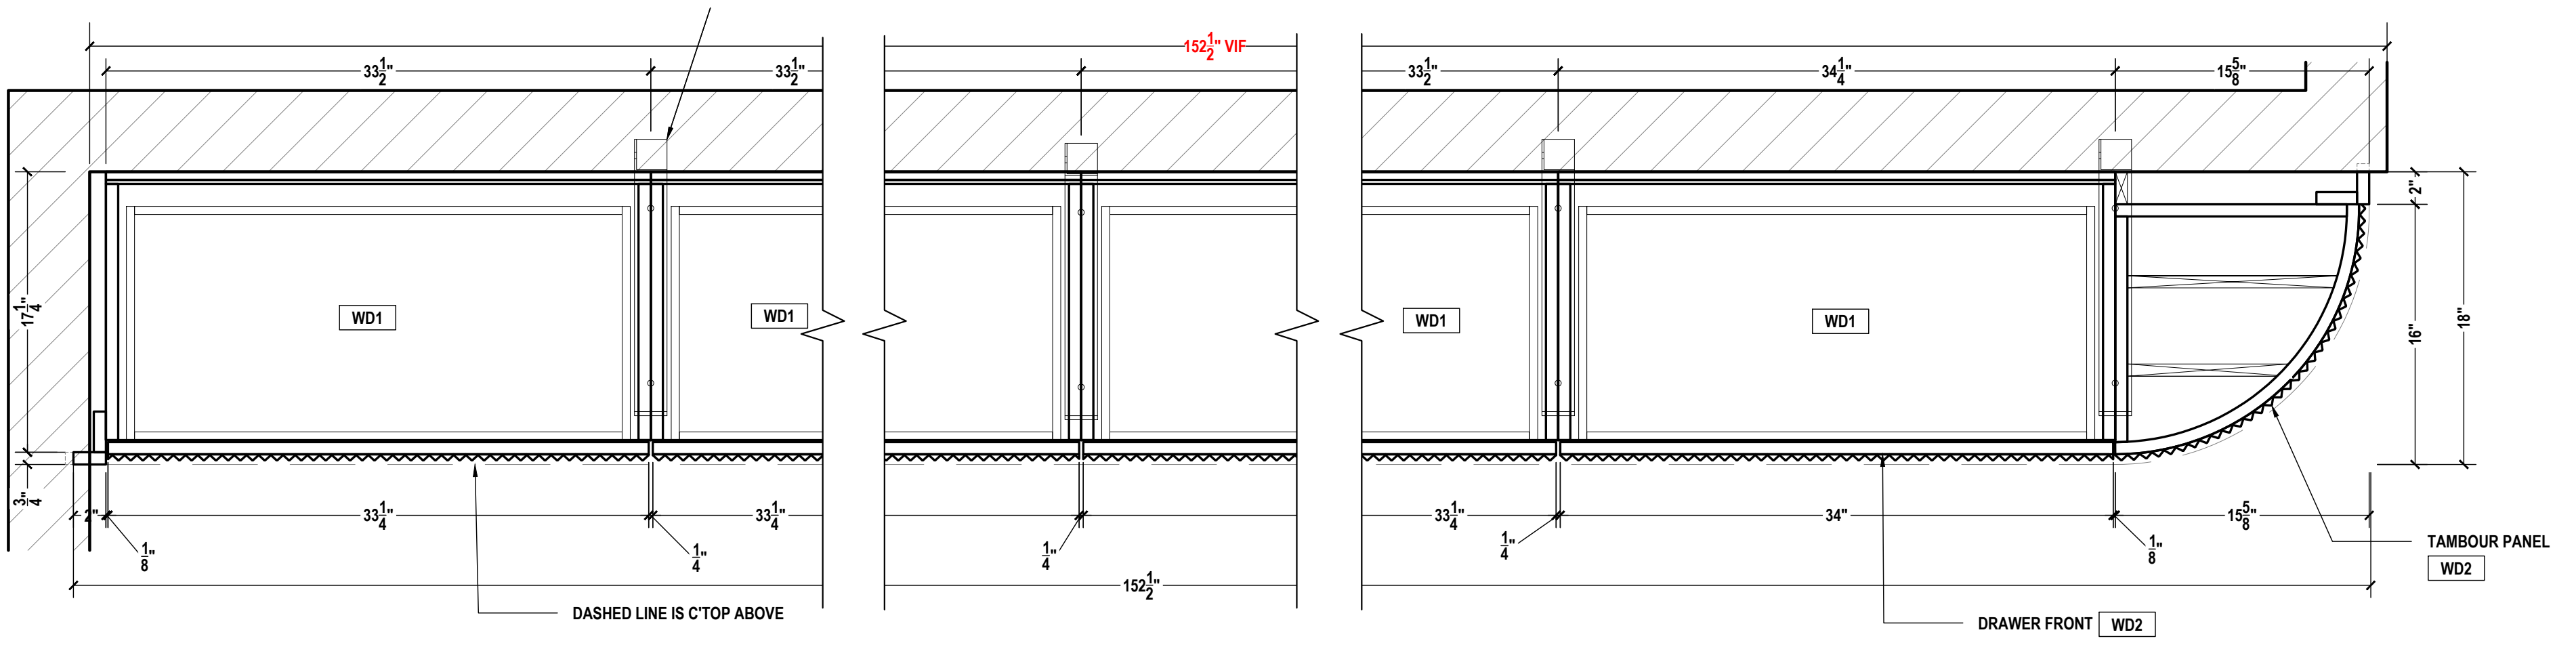

F LOBBY A105
HORIZONTAL SECTION
SCALE: 1-1/2"=1'-0" ARCH REF.: N/A

PROJECT:
SAMPLE DRAWINGS

PROJECT ADDRESS:
ORANGE AVE, NASHVILLE, TN

ARCHITECT:
FREDDY C.

G.C.:
PAOLO P.

	QCP	YES <input checked="" type="checkbox"/>	NO <input type="checkbox"/>
	LEED	YES <input type="checkbox"/>	NO <input checked="" type="checkbox"/>
	FSC	YES <input type="checkbox"/>	NO <input checked="" type="checkbox"/>
	NAUF	YES <input type="checkbox"/>	NO <input checked="" type="checkbox"/>

FINISHES:


KEY	VENEER	COLOR
WD1	VENEER TO MATCH PL2	
WD2	WHITE OAK, PROFILE T318 RUBIO MONOCOAR	

PM:	ERW
DRAWN BY:	TMS
DATE DRAWN:	02/10/2023
REVIEWED BY:	LCT (LOC)

REVISIONS:

No.	DATE:	DESCRIPTIONS:	BY:
△	-	-	-
△	-	-	-
△	-	-	-
△	-	-	-
△	-	-	-
△	-	-	-
△	-	-	-
△	-	-	-

APPROVAL DATE	-
PLOT DATE	07/11/2024
PROJECT NUMBER	P-5567446
ROOM NAME	LOBBY A105
SHEET NUMBER	102.05

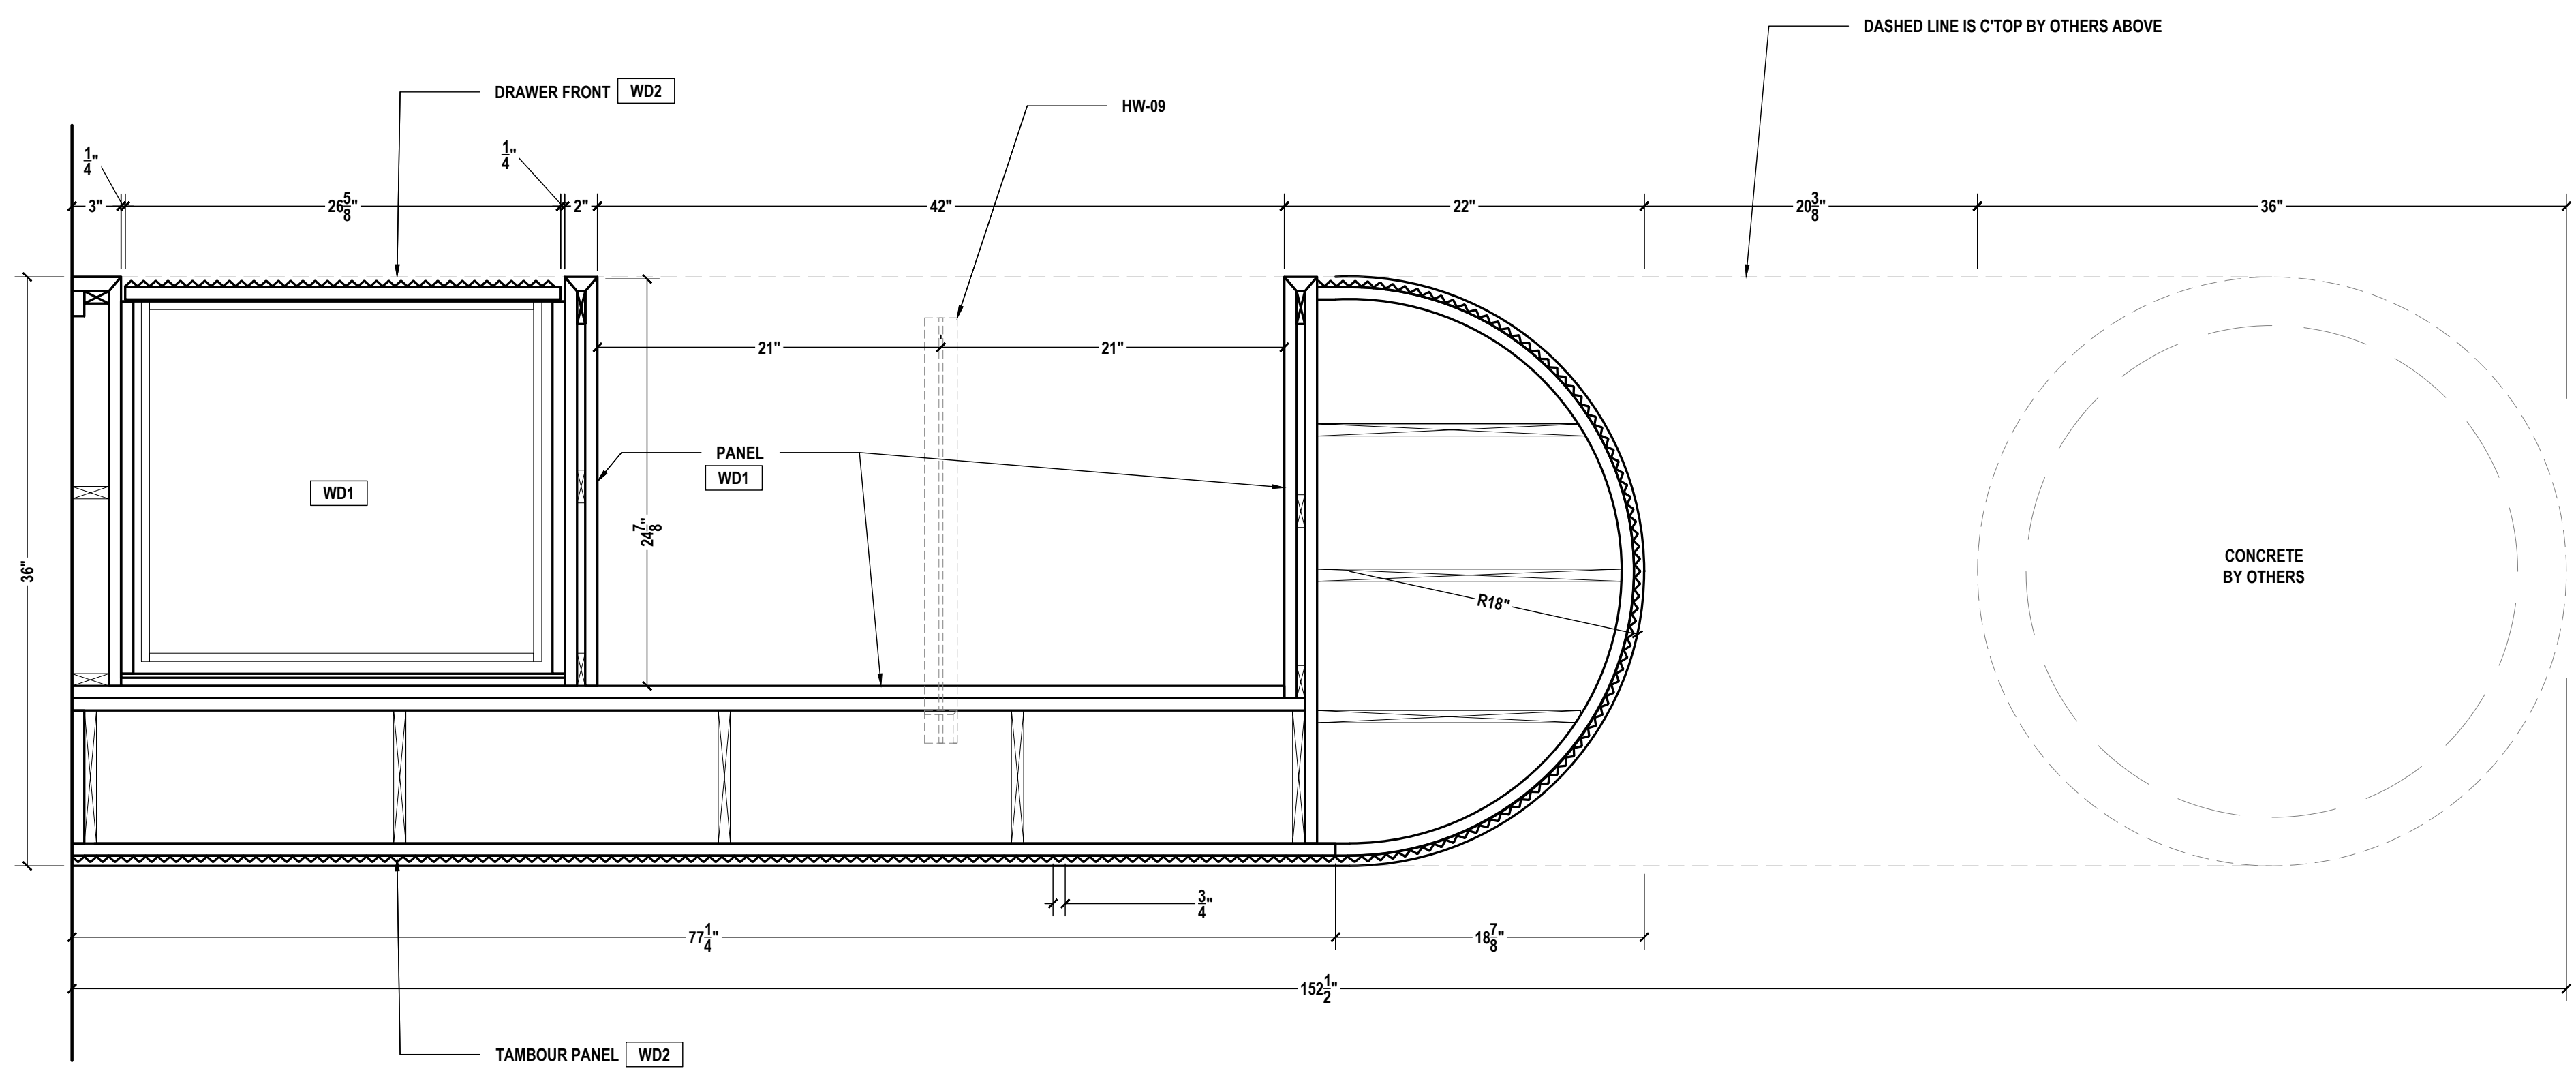

G LOBBY A105
HORIZONTAL SECTION
SCALE: 1-1/2"=1'-0" ARCH REF.: N/A

PROJECT:
SAMPLE DRAWINGS

PROJECT ADDRESS:
ORANGE AVE, NASHVILLE, TN

ARCHITECT:
FREDDY C.

G.C.:
PAOLO P.

	QCP	YES <input checked="" type="checkbox"/>	NO <input type="checkbox"/>
	LEED	YES <input type="checkbox"/>	NO <input checked="" type="checkbox"/>
	FSC	YES <input type="checkbox"/>	NO <input checked="" type="checkbox"/>
	NAUF	YES <input type="checkbox"/>	NO <input checked="" type="checkbox"/>

FINISHES:


PLASTIC LAMINATE		
KEY	COLOR	
PL1	CARBON, TRUMATTE, BLACK	
STONE		
KEY	COLOR	
ST1	CAESARSTONE 5121 LAYATILE	
INTERIOR FINISHES		
KEY	COLOR	
WELL	WHITE MELAMINE	

PM:	ERW
DRAWN BY:	TMS
DATE DRAWN:	02/10/2023
REVIEWED BY:	LCT (LOC)


REVISIONS:

No.	DATE	DESCRIPTIONS	BY:
△	-	-	-
△	-	-	-
△	-	-	-
△	-	-	-
△	-	-	-
△	-	-	-
△	-	-	-
△	-	-	-

APPROVAL DATE	-
PLOT DATE	07/11/2024
PROJECT NUMBER	P-5567446
ROOM NAME	RESTROOMS A402
SHEET NUMBER	103.01

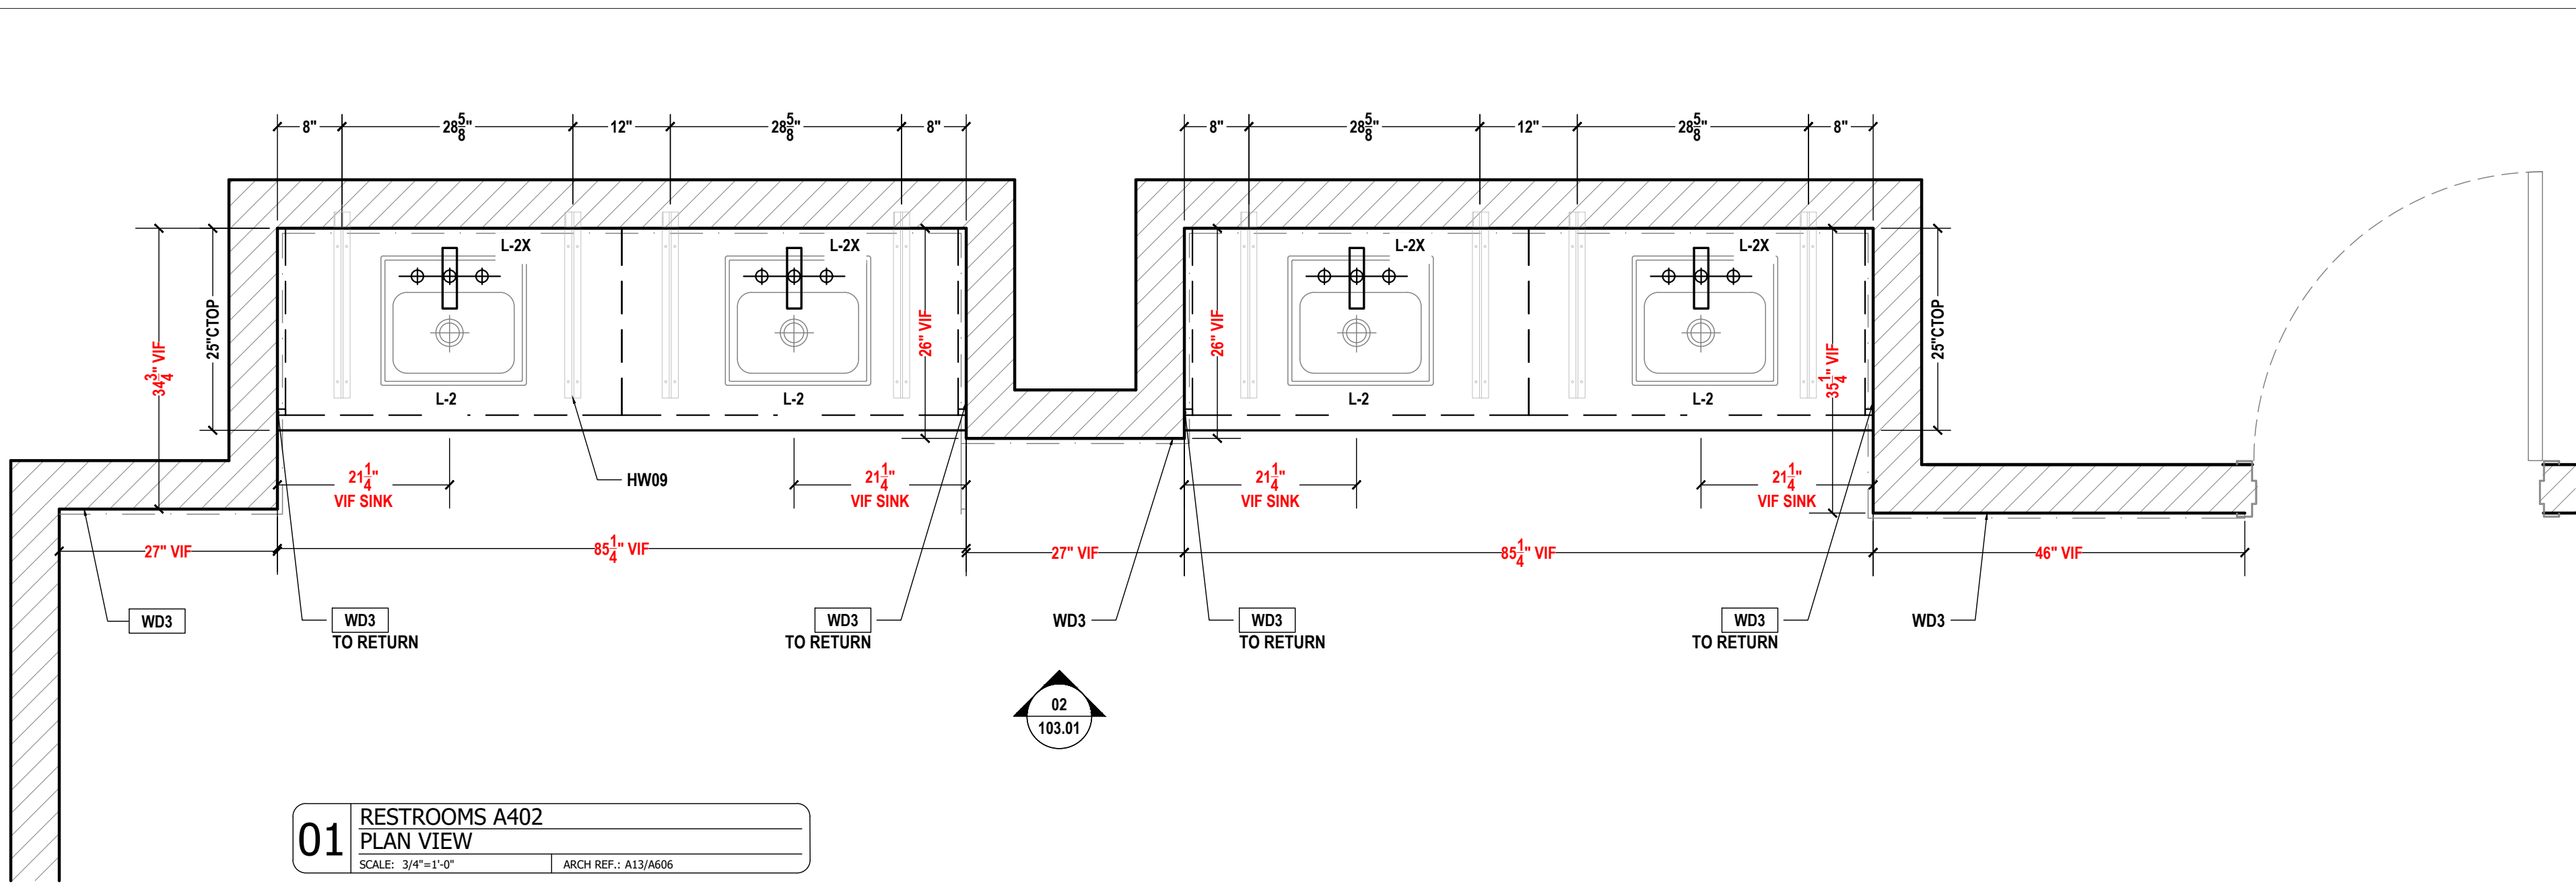

01 RESTROOMS A402
PLAN VIEW
SCALE: 3/4"=1'-0" ARCH REF.: A13/A606

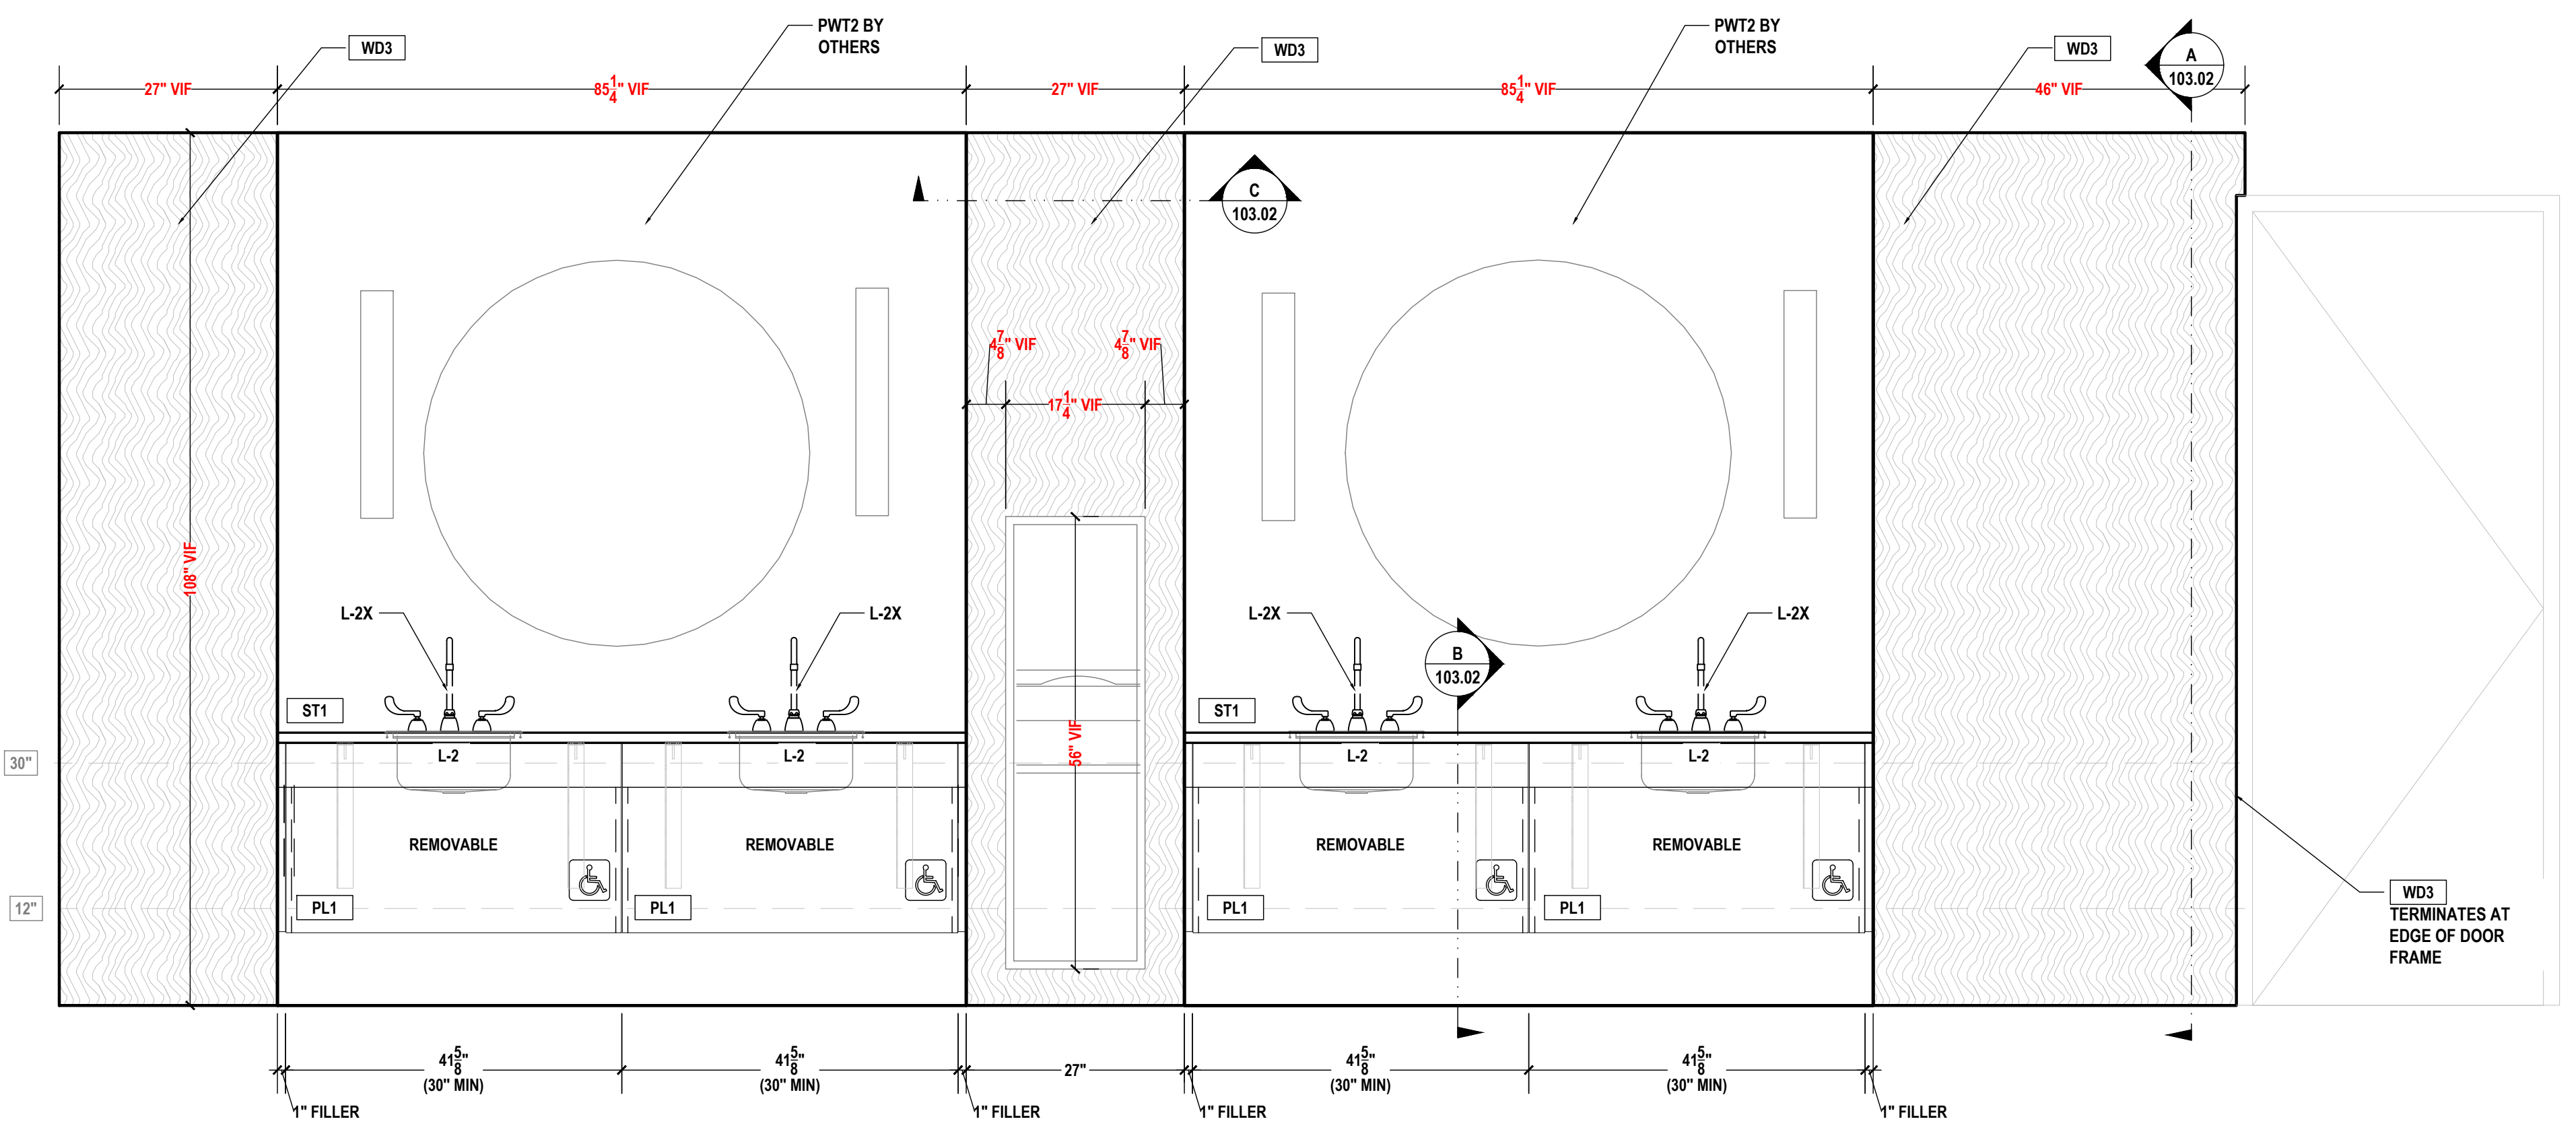

02 RESTROOMS A402
ELEVATION
SCALE: 3/4"=1'-0" ARCH REF.: A14/A606

WD3
TERMINATES AT
EDGE OF DOOR
FRAME

PROJECT:
SAMPLE DRAWINGS

PROJECT ADDRESS:
ORANGE AVE, NASHVILLE, TN

ARCHITECT:
FREDDY C.

G.C.:
PAOLO P.

	QCP	YES <input checked="" type="checkbox"/>	NO <input type="checkbox"/>
	LEED	YES <input type="checkbox"/>	NO <input checked="" type="checkbox"/>
	FSC	YES <input type="checkbox"/>	NO <input checked="" type="checkbox"/>
	NAUF	YES <input type="checkbox"/>	NO <input checked="" type="checkbox"/>

FINISHES:



PLASTIC LAMINATE	
KEY	COLOR
PL1	CARBON, TRUMATTE, BLACK
STONE	
KEY	COLOR
ST1	CAESARSTONE 5121 LAYATILE
INTERIOR FINISHES	
KEY	COLOR
MEL1	WHITE MELAMINE

PM:	ERW
DRAWN BY:	TMS
DATE DRAWN:	02/10/2023
REVIEWED BY:	LCT (LOC)


REVISIONS:

No.	DATE	DESCRIPTIONS	BY:
△	-	-	-
△	-	-	-
△	-	-	-
△	-	-	-
△	-	-	-
△	-	-	-
△	-	-	-

APPROVAL DATE	-
PLOT DATE	07/11/2024
PROJECT NUMBER	P-5567446
ROOM NAME	RESTROOMS A402
SHEET NUMBER	103.02

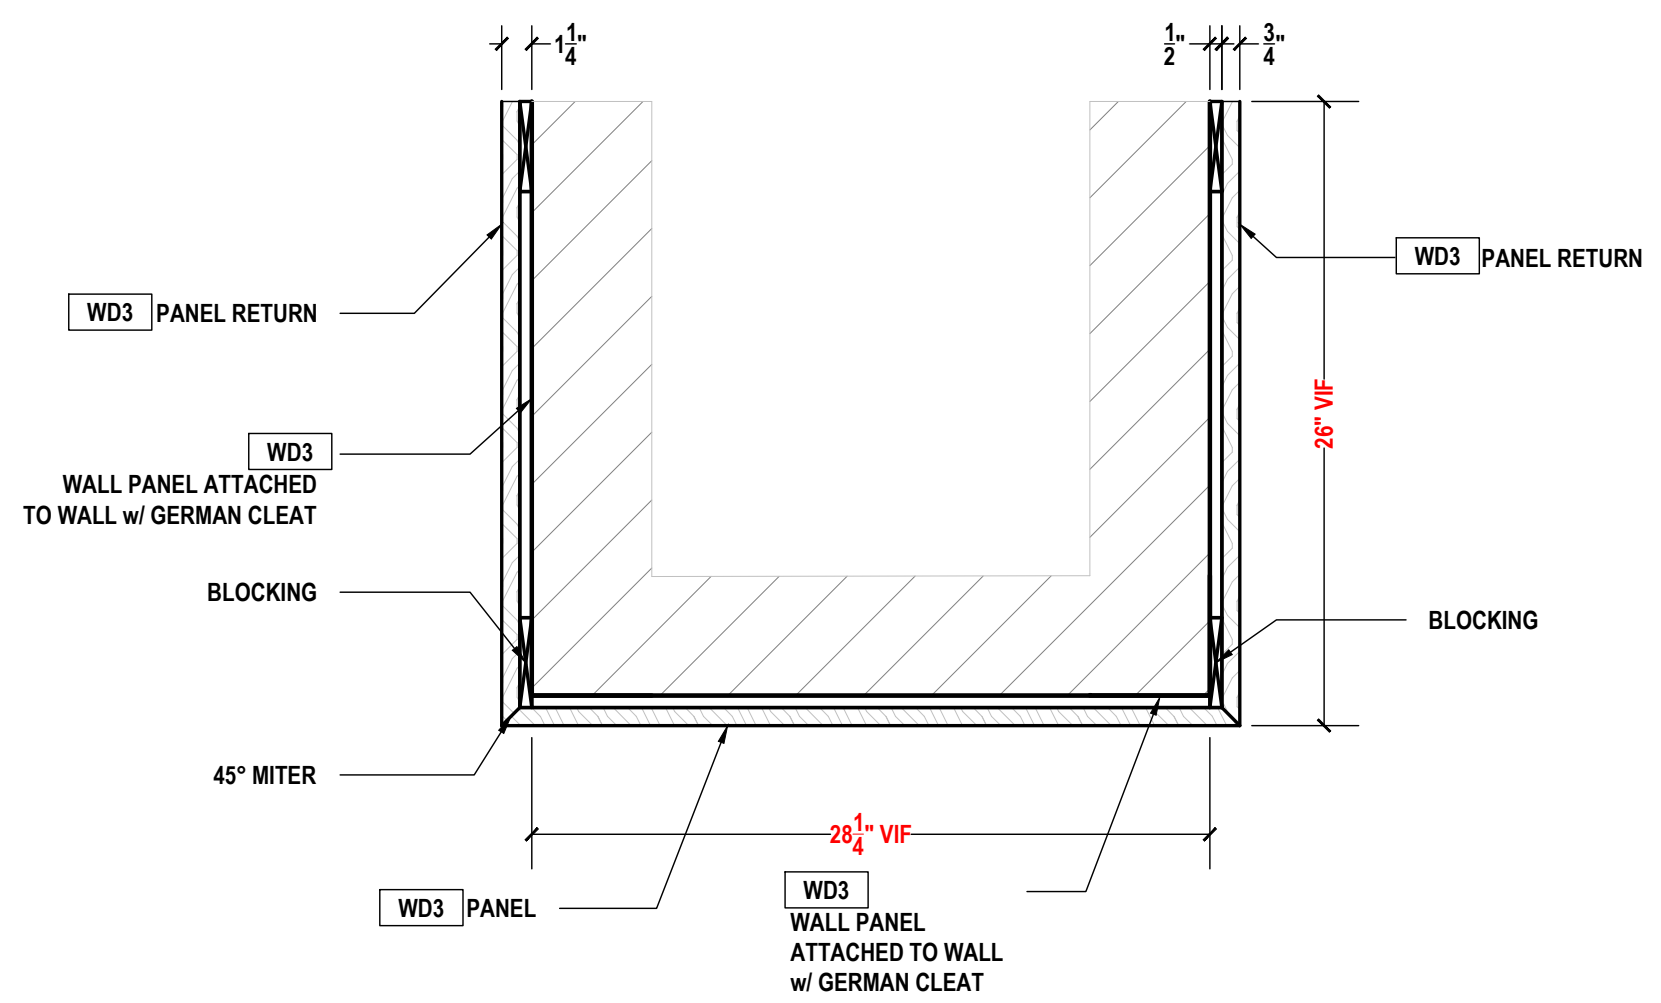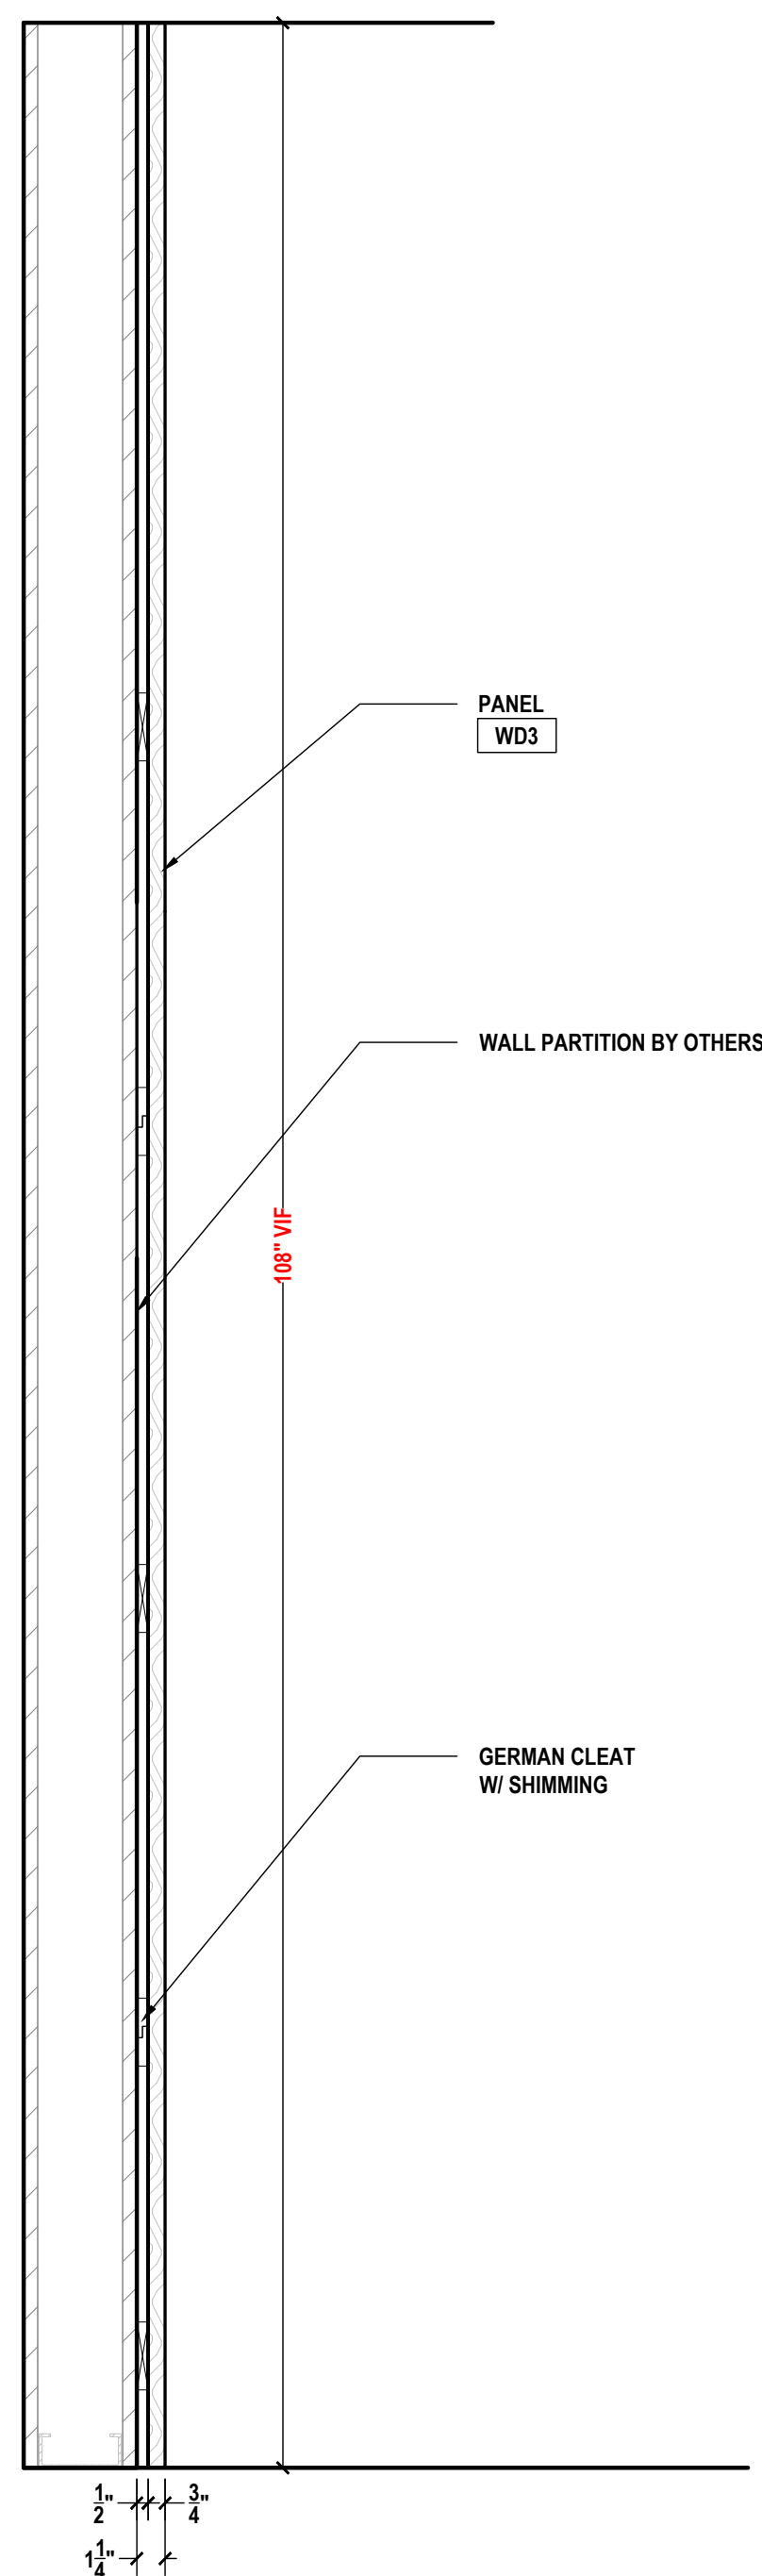

C RESTROOMS A402
HORIZONTAL SECTION
SCALE: 1-1/2"=1'-0" ARCH REF.: 20/A604B

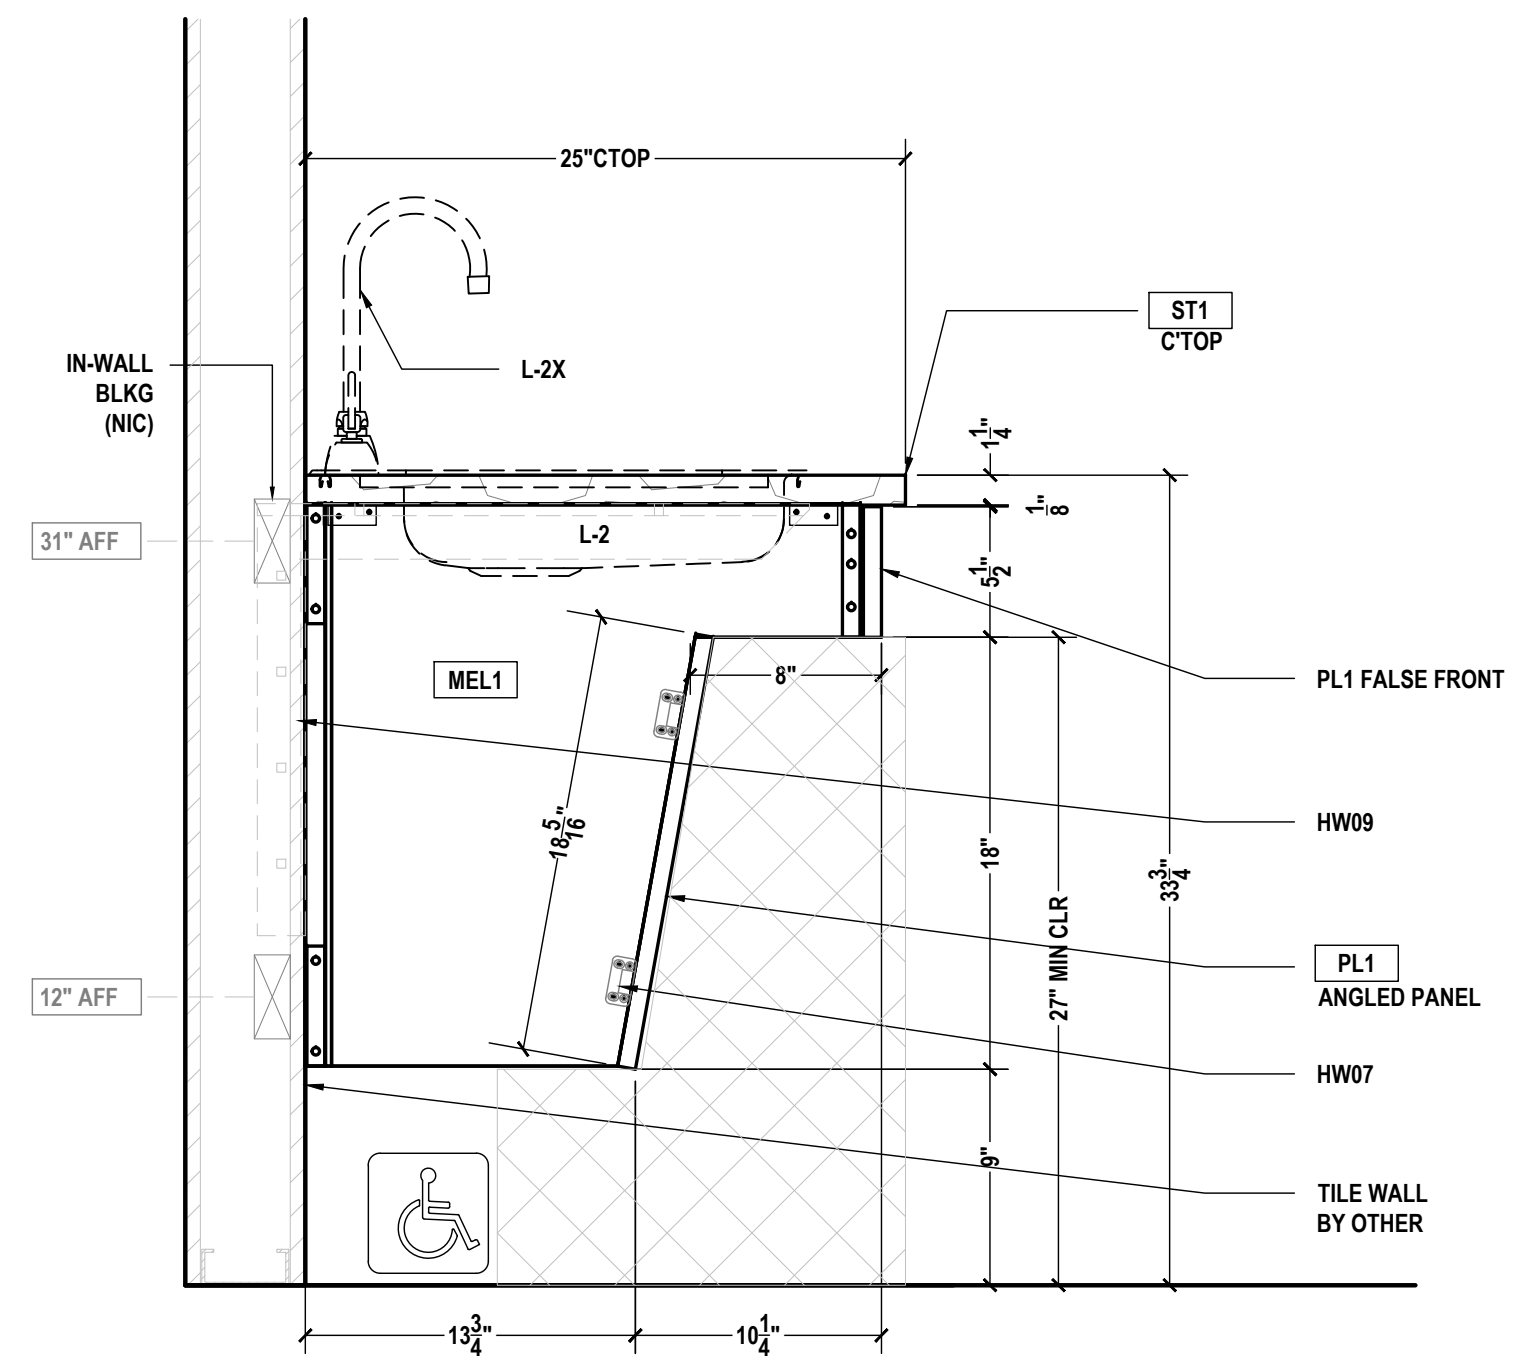

B RESTROOMS A402
SECTION
SCALE: 1-1/2"=1'-0" ARCH REF.: 19/A604B

A RESTROOMS A402
SECTION
SCALE: 1-1/2"=1'-0" ARCH REF.: 18/A604B

PROJECT:
SAMPLE DRAWINGS

PROJECT ADDRESS:
ORANGE AVE, NASHVILLE, TN

ARCHITECT:
FREDDY C.

G.C.:
PAOLO P.

	QCP	YES <input checked="" type="checkbox"/>	NO <input type="checkbox"/>
	LEED	YES <input type="checkbox"/>	NO <input checked="" type="checkbox"/>
	FSC	YES <input type="checkbox"/>	NO <input checked="" type="checkbox"/>
	NAUF	YES <input type="checkbox"/>	NO <input checked="" type="checkbox"/>

FINISHES:


PLASTIC LAMINATE	
KEY	COLOR
PL1	CARBON, TRUMATTE, BLACK
STONE	
KEY	COLOR
ST1	CAESARSTONE 5121 LAYATILE
INTERIOR FINISHES	
KEY	COLOR
MEL1	WHITE MELAMINE

PM:	ERW
DRAWN BY:	TMS
DATE DRAWN:	02/10/2023
REVIEWED BY:	LCT (LOC)

REVISIONS:

No.	DATE:	DESCRIPTIONS:	BY:
△	-	-	-
△	-	-	-
△	-	-	-
△	-	-	-
△	-	-	-
△	-	-	-
△	-	-	-
△	-	-	-

APPROVAL DATE	-
PLOT DATE	07/11/2024
PROJECT NUMBER	P-5567446
ROOM NAME	WORKING RM A108
SHEET NUMBER	104.01

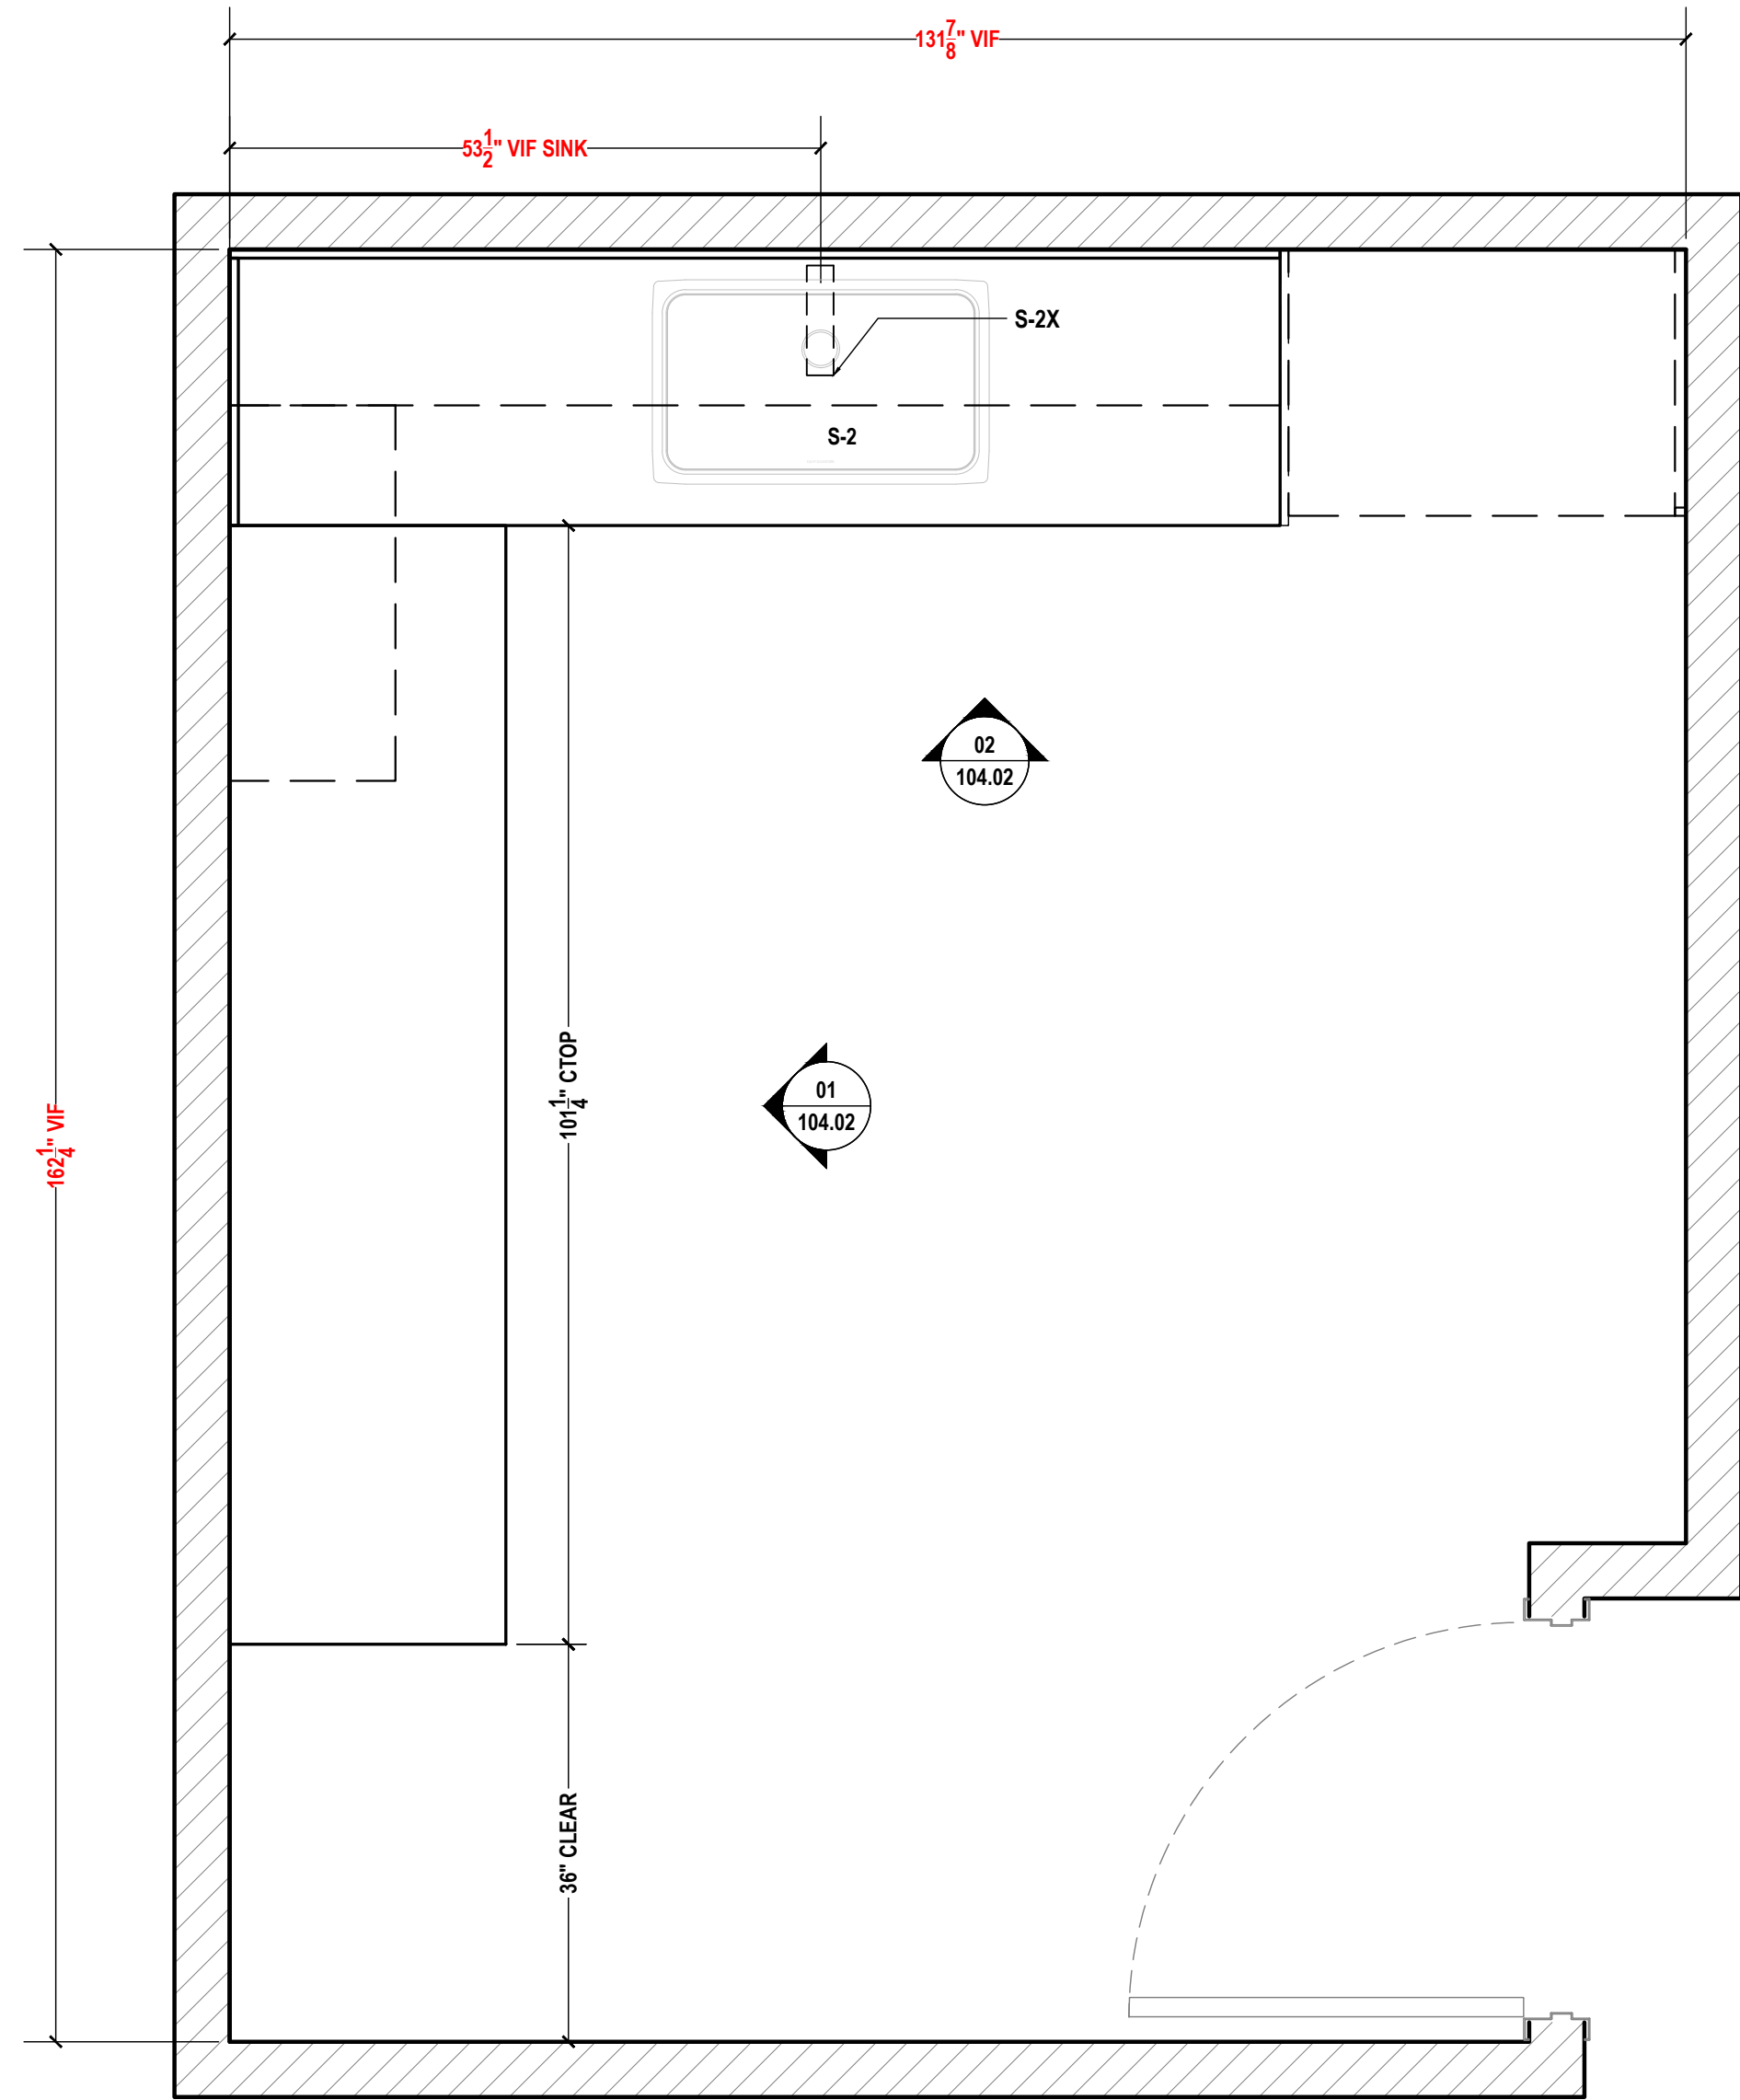

01 WORKING ROOM A108
PLAN VIEW
SCALE: 3/4"=1'-0" ARCH REF.: A1/A607

PROJECT:
SAMPLE DRAWINGS

PROJECT ADDRESS:
ORANGE AVE, NASHVILLE, TN

ARCHITECT:
FREDDY C.

G.C.:
PAOLO P.

	QCP	YES <input checked="" type="checkbox"/>	NO <input type="checkbox"/>
	LEED	YES <input type="checkbox"/>	NO <input checked="" type="checkbox"/>
	FSC	YES <input type="checkbox"/>	NO <input checked="" type="checkbox"/>
	NAUF	YES <input type="checkbox"/>	NO <input checked="" type="checkbox"/>

FINISHES:


PLASTIC LAMINATE	
KEY	COLOR
PL1	CARBON, TRUMATTE, BLACK
STONE	
KEY	COLOR
ST1	CAESARSTONE 5121 LAYATILE
INTERIOR FINISHES	
KEY	COLOR
MEL1	WHITE MELAMINE

PM:	ERW
DRAWN BY:	TMS
DATE DRAWN:	02/10/2023
REVIEWED BY:	LCT (LOC)


REVISIONS:

No.	DATE:	DESCRIPTIONS:	BY:
△	-	-	-
△	-	-	-
△	-	-	-
△	-	-	-
△	-	-	-
△	-	-	-
△	-	-	-
△	-	-	-

APPROVAL DATE	-
PLOT DATE	07/11/2024
PROJECT NUMBER	P-5567446
ROOM NAME	WORKING RM A108
SHEET NUMBER	104.02

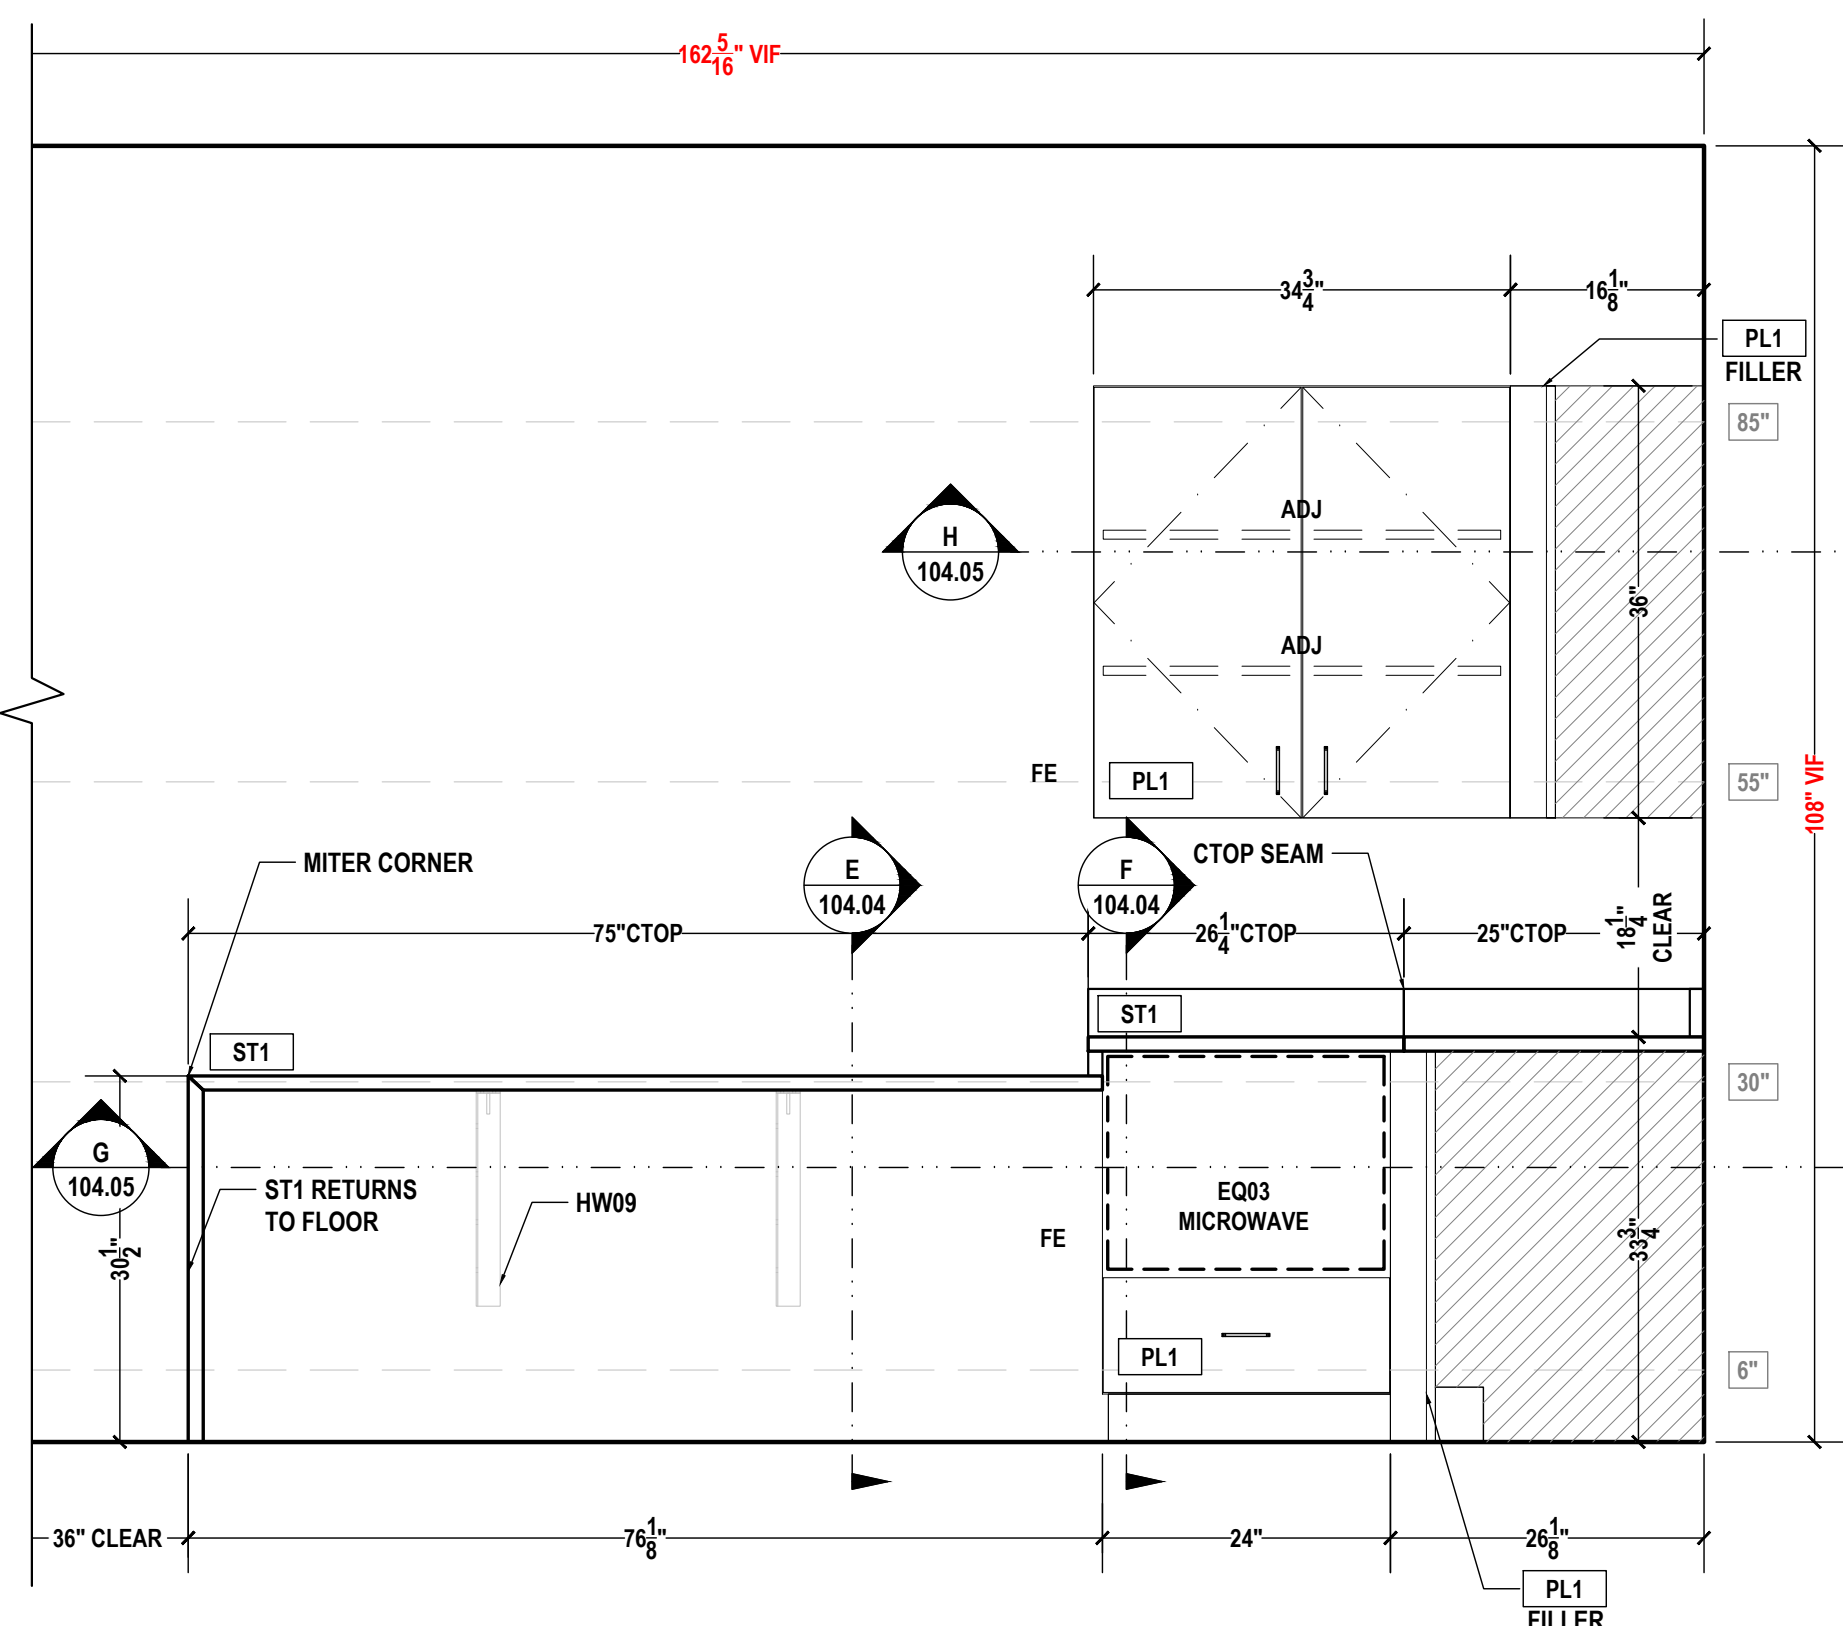

01 WORKING ROOM A108
ELEVATION
SCALE: 3/4"=1'-0" ARCH REF.: A3/A607

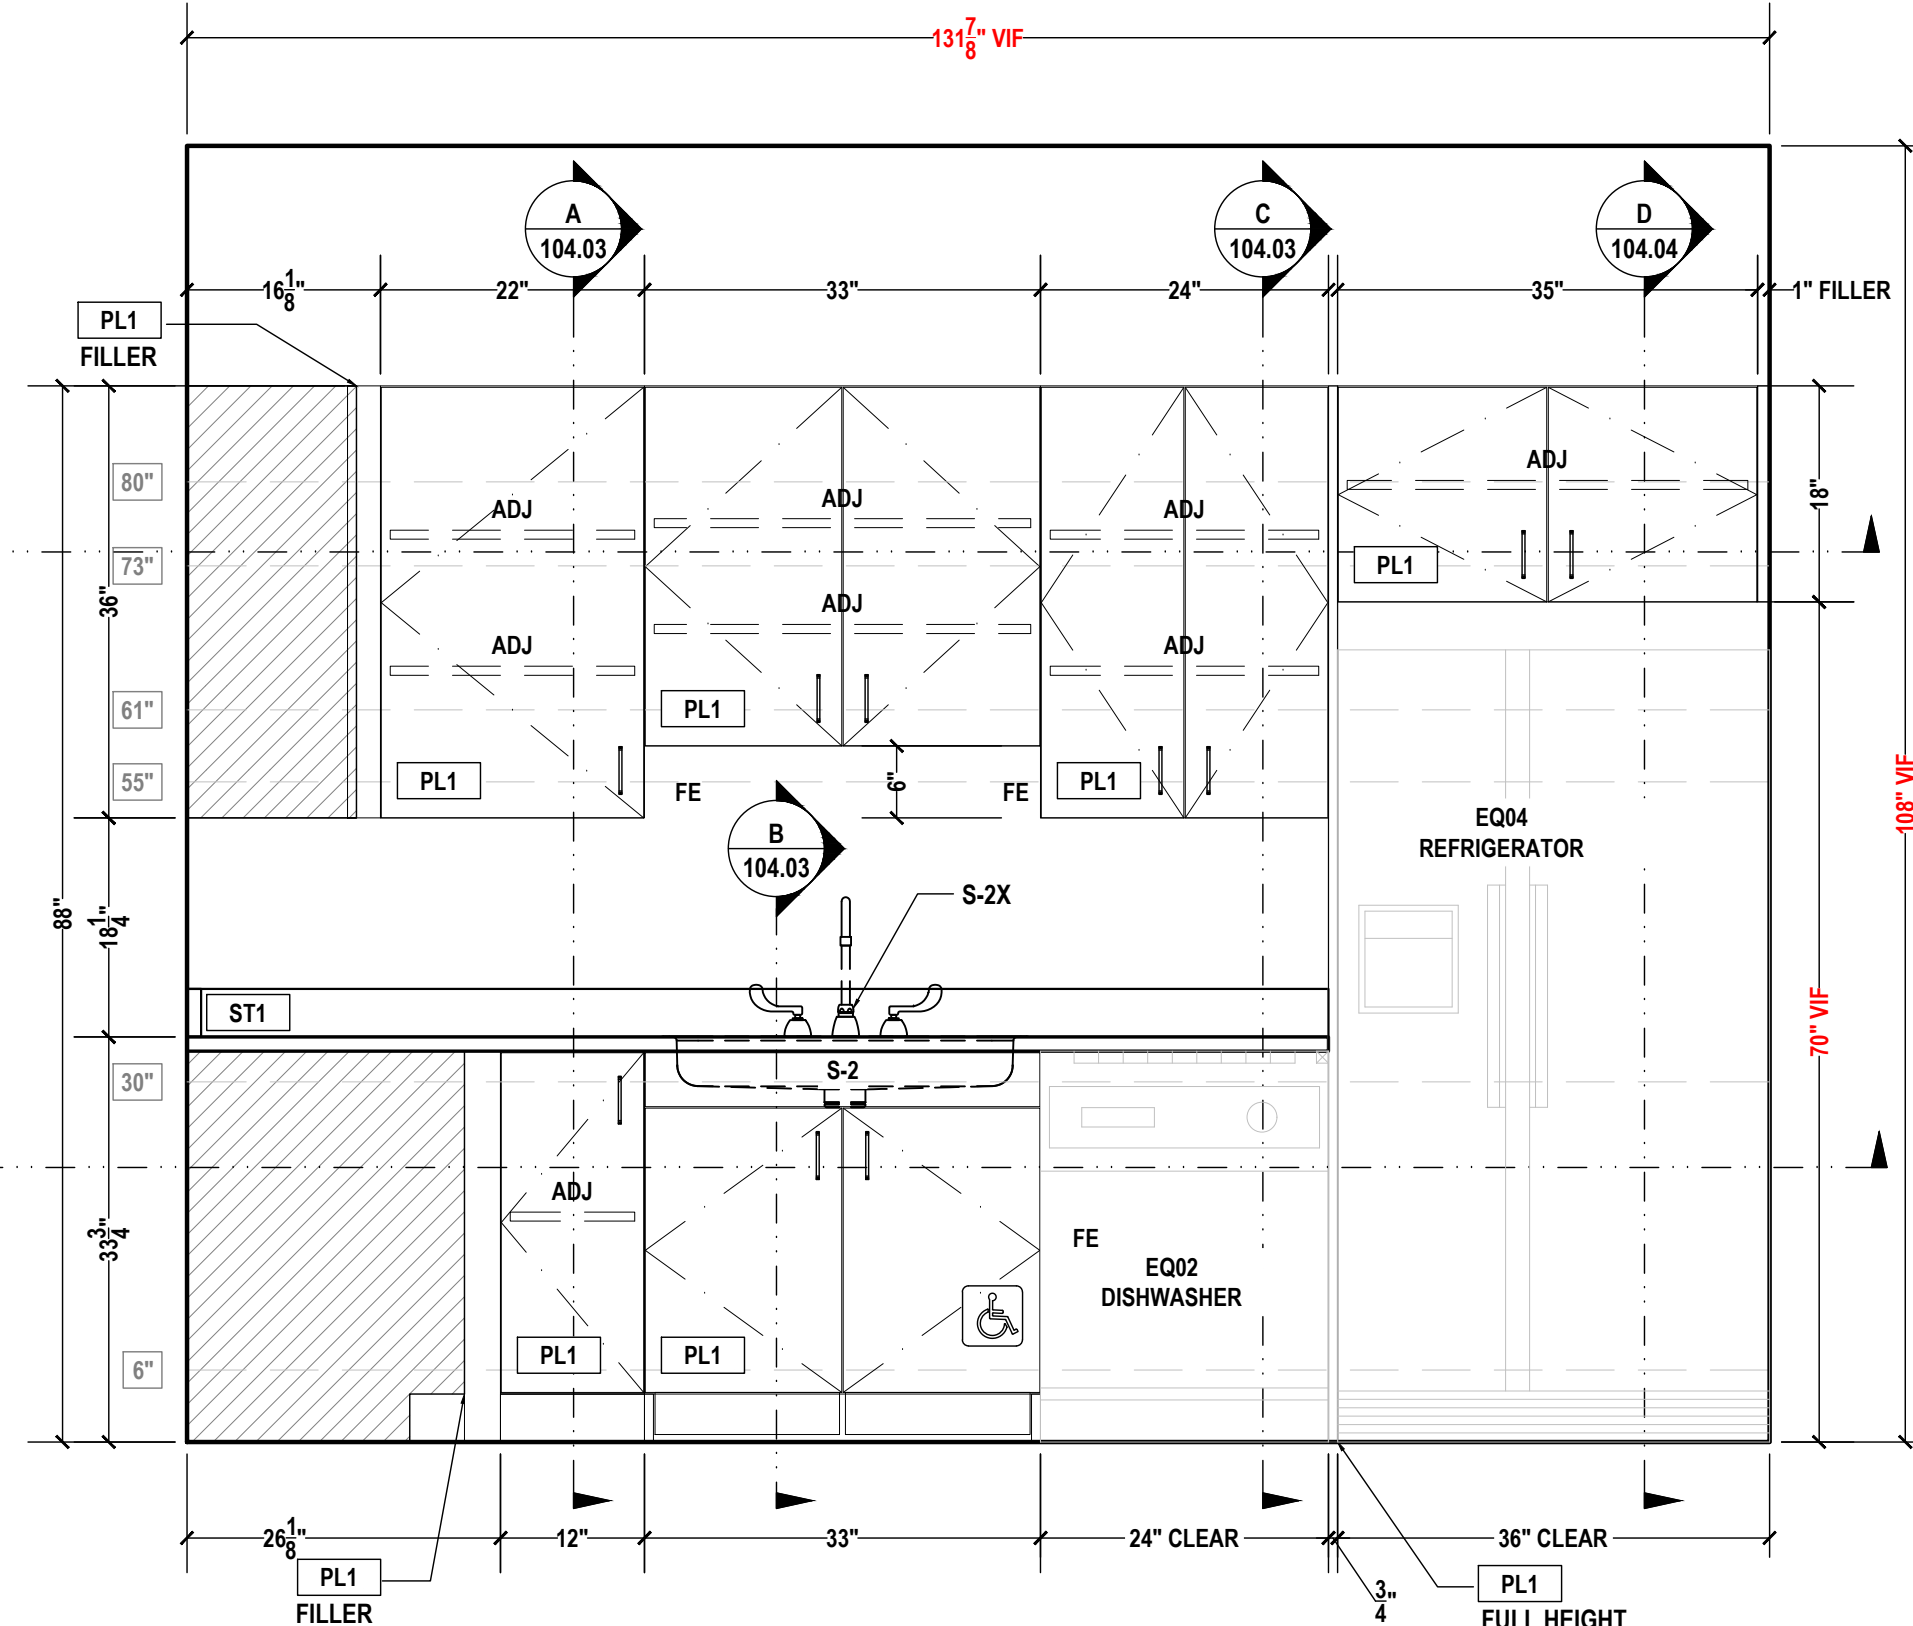

02 WORKING ROOM A108
ELEVATION
SCALE: 3/4"=1'-0" ARCH REF.: A2/A607

PROJECT:
SAMPLE DRAWINGS

PROJECT ADDRESS:
ORANGE AVE, NASHVILLE, TN

ARCHITECT:
FREDDY C.

G.C.:
PAOLO P.

	QCP	YES <input checked="" type="checkbox"/>	NO <input type="checkbox"/>
	LEED	YES <input type="checkbox"/>	NO <input checked="" type="checkbox"/>
	FSC	YES <input type="checkbox"/>	NO <input checked="" type="checkbox"/>
	NAUF	YES <input type="checkbox"/>	NO <input checked="" type="checkbox"/>

FINISHES:


PLASTIC LAMINATE	
KEY	COLOR
PL1	CARBON, TRUMATTE, BLACK
STONE	
KEY	COLOR
ST1	CAESARSTONE 5121 LAYATILE
INTERIOR FINISHES	
KEY	COLOR
MEL1	WHITE MELAMINE

PM:	ERW
DRAWN BY:	TMS
DATE DRAWN:	02/10/2023
REVIEWED BY:	LCT (LOC)


REVISIONS:

No.	DATE	DESCRIPTIONS	BY:
△	-	-	-
△	-	-	-
△	-	-	-
△	-	-	-
△	-	-	-
△	-	-	-
△	-	-	-


APPROVAL DATE	-
PLOT DATE	07/11/2024
PROJECT NUMBER	P-5567446
ROOM NAME	WORKING RM A108
SHEET NUMBER	104.03

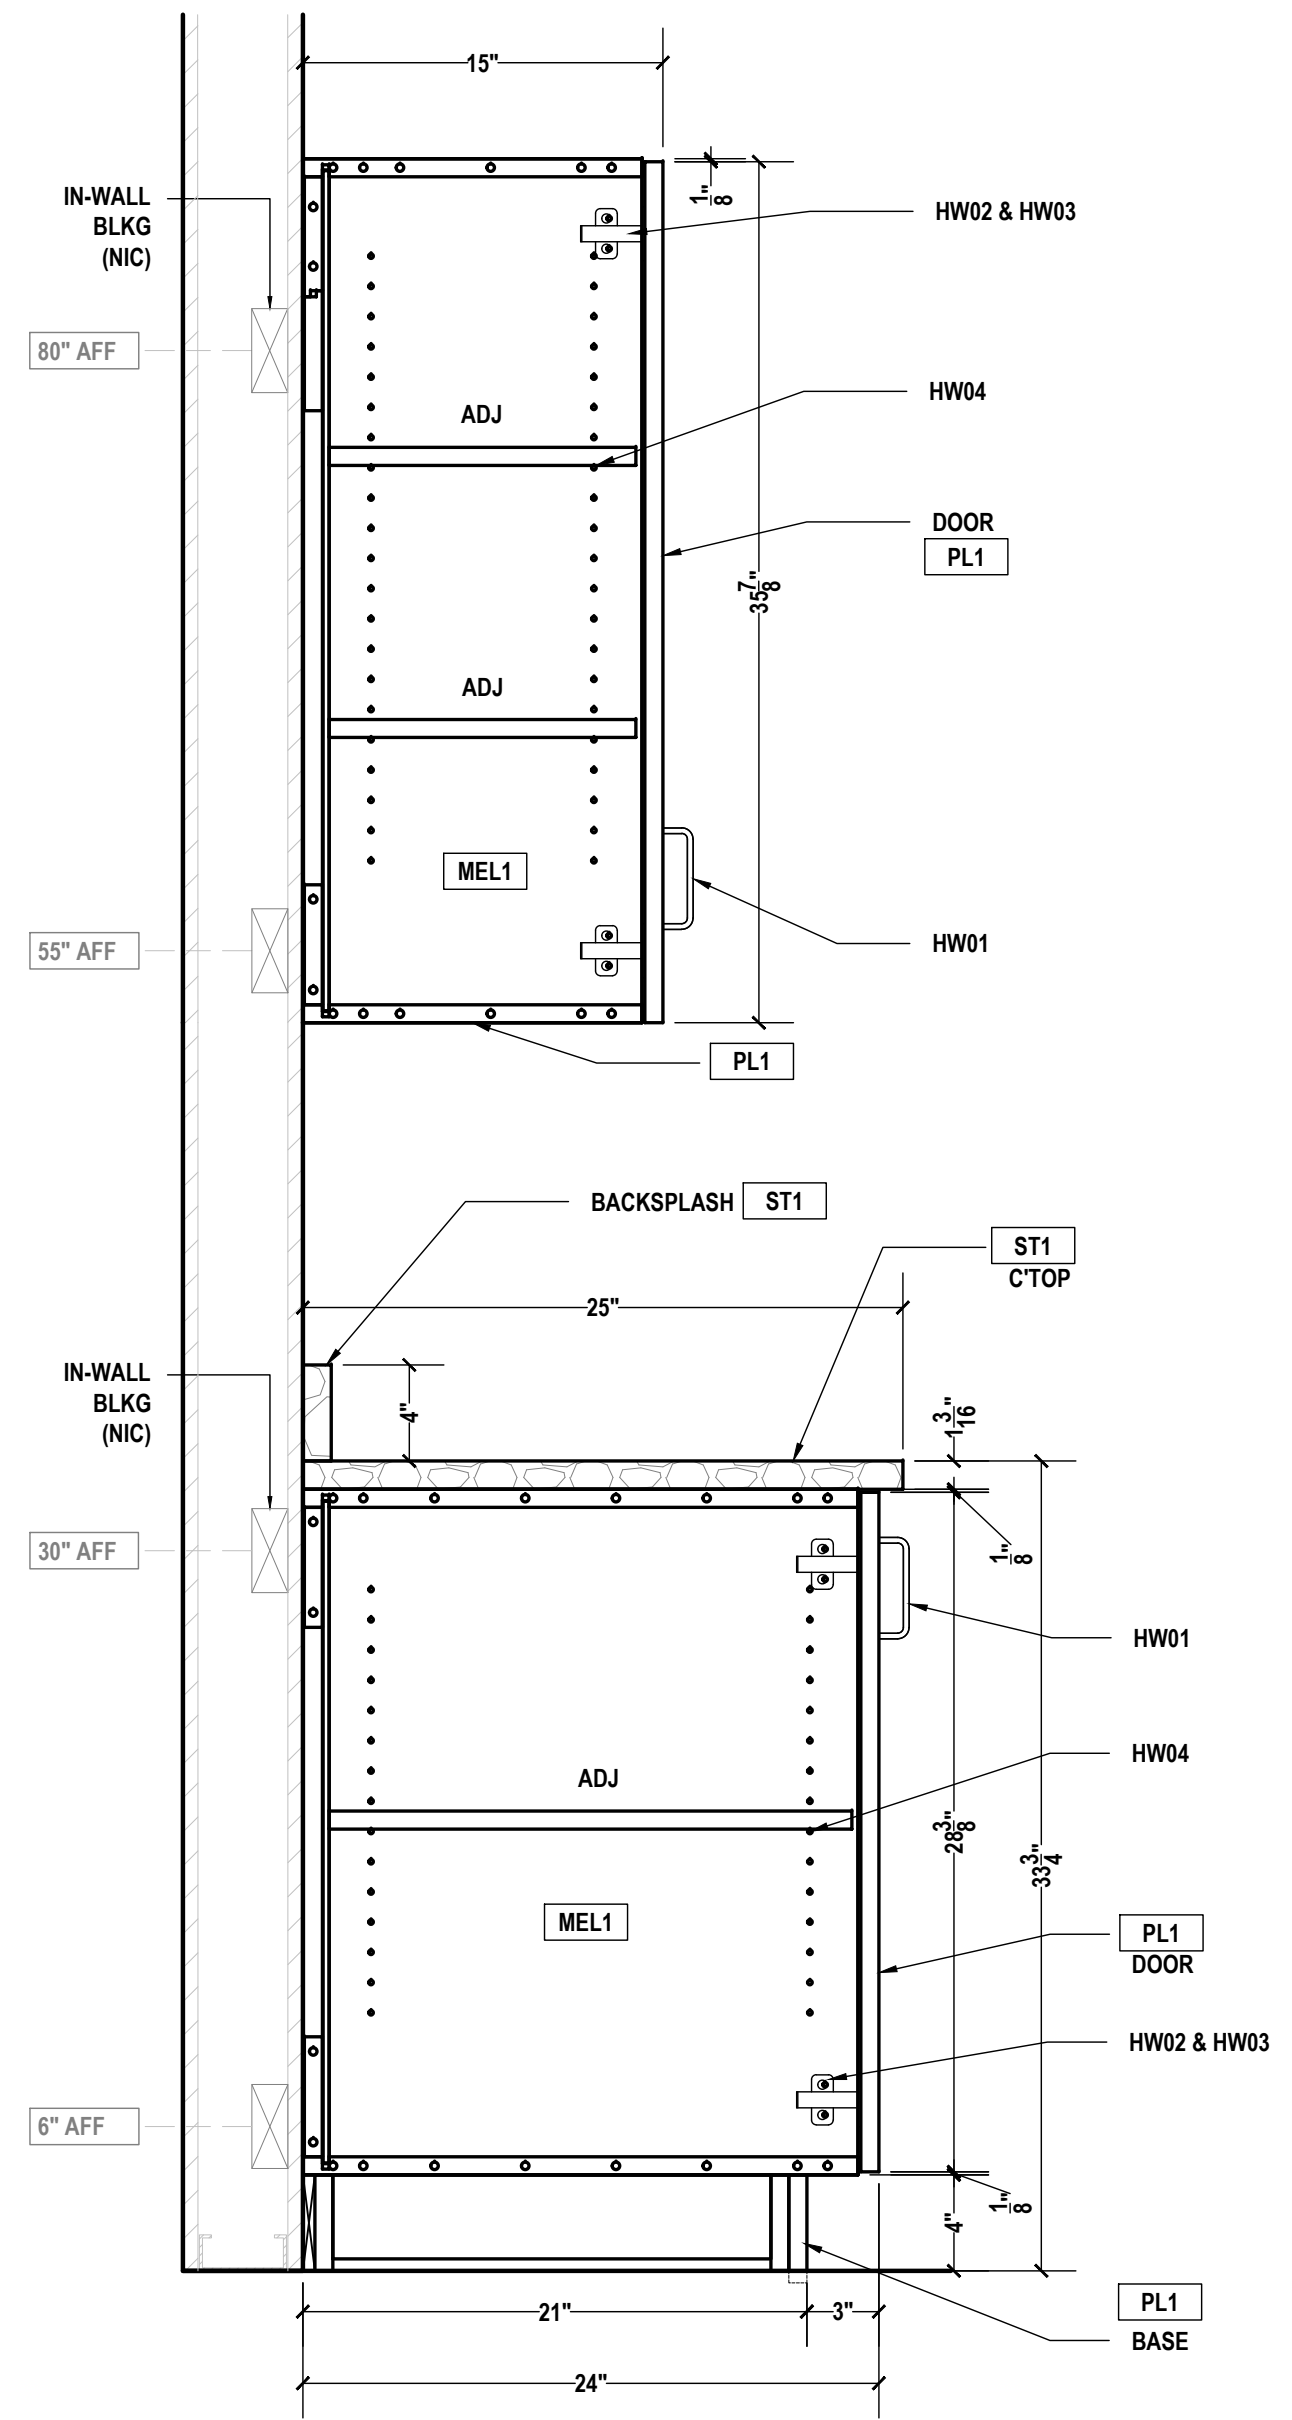

A WORKING ROOM A108
SECTION
SCALE: 1-1/2"=1'-0" ARCH REF.: 21/A604B

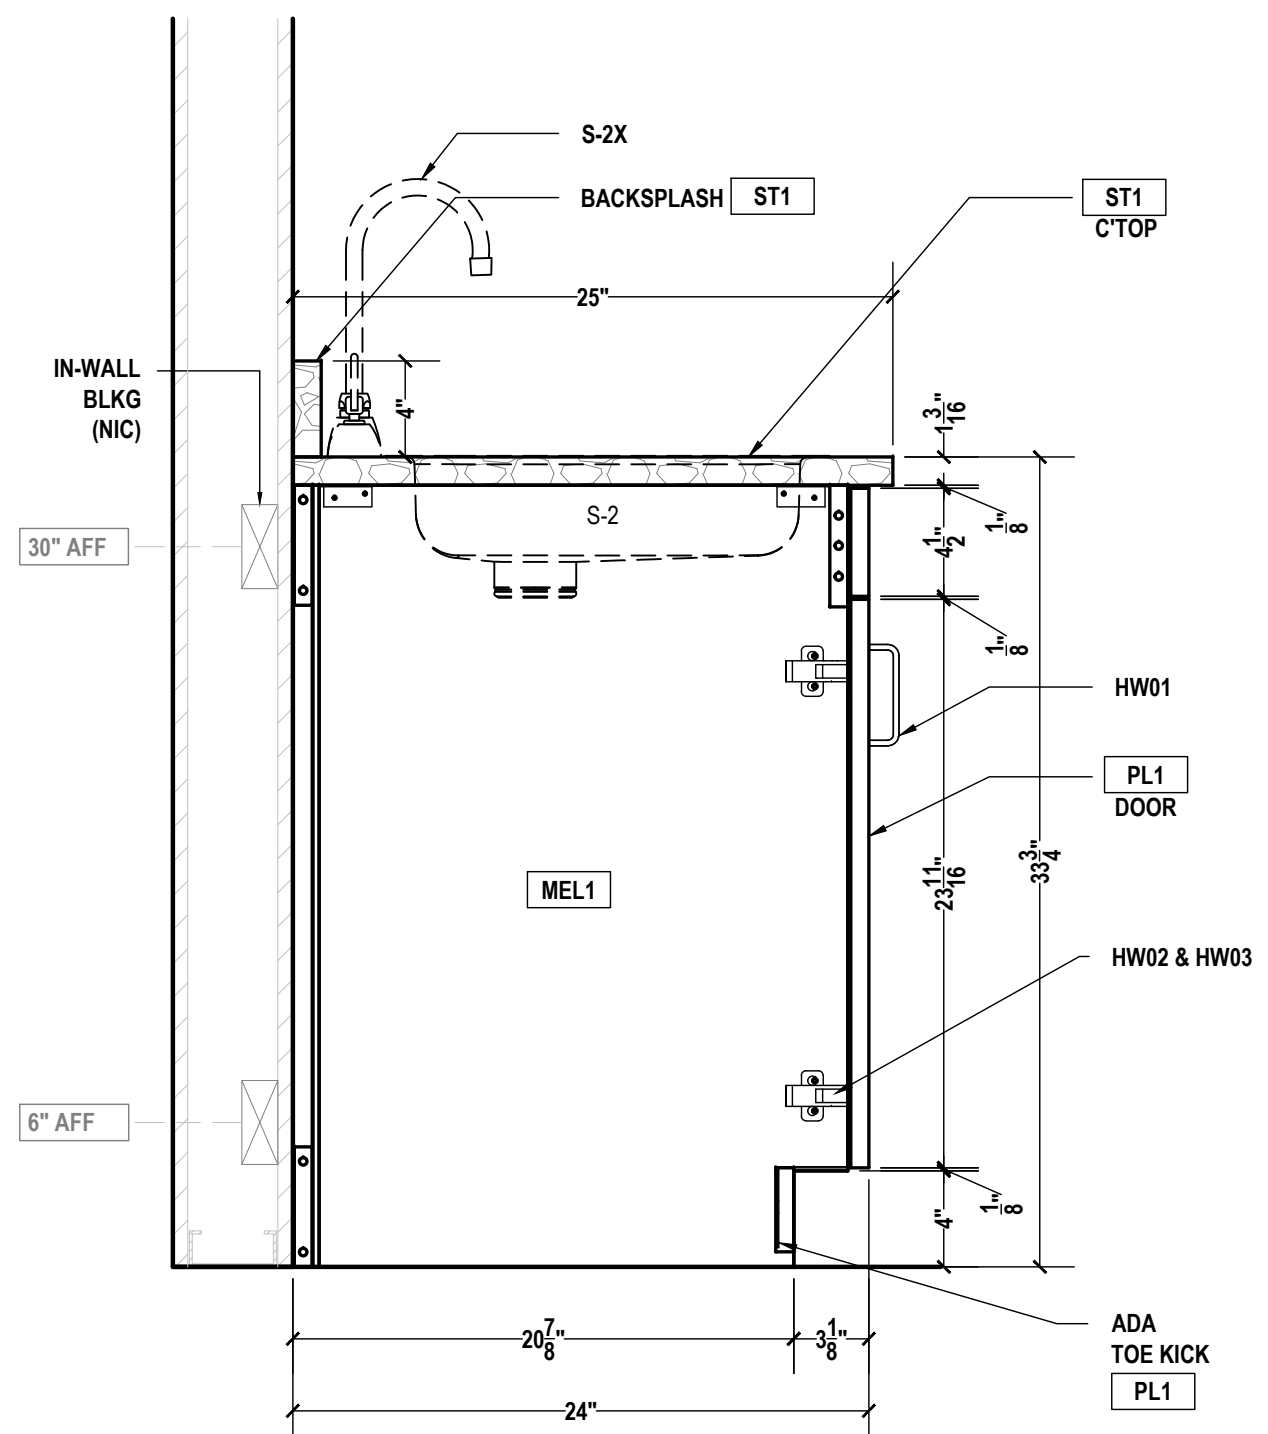

B WORKING ROOM A108
SECTION
SCALE: 1-1/2"=1'-0" ARCH REF.: 22/A604B

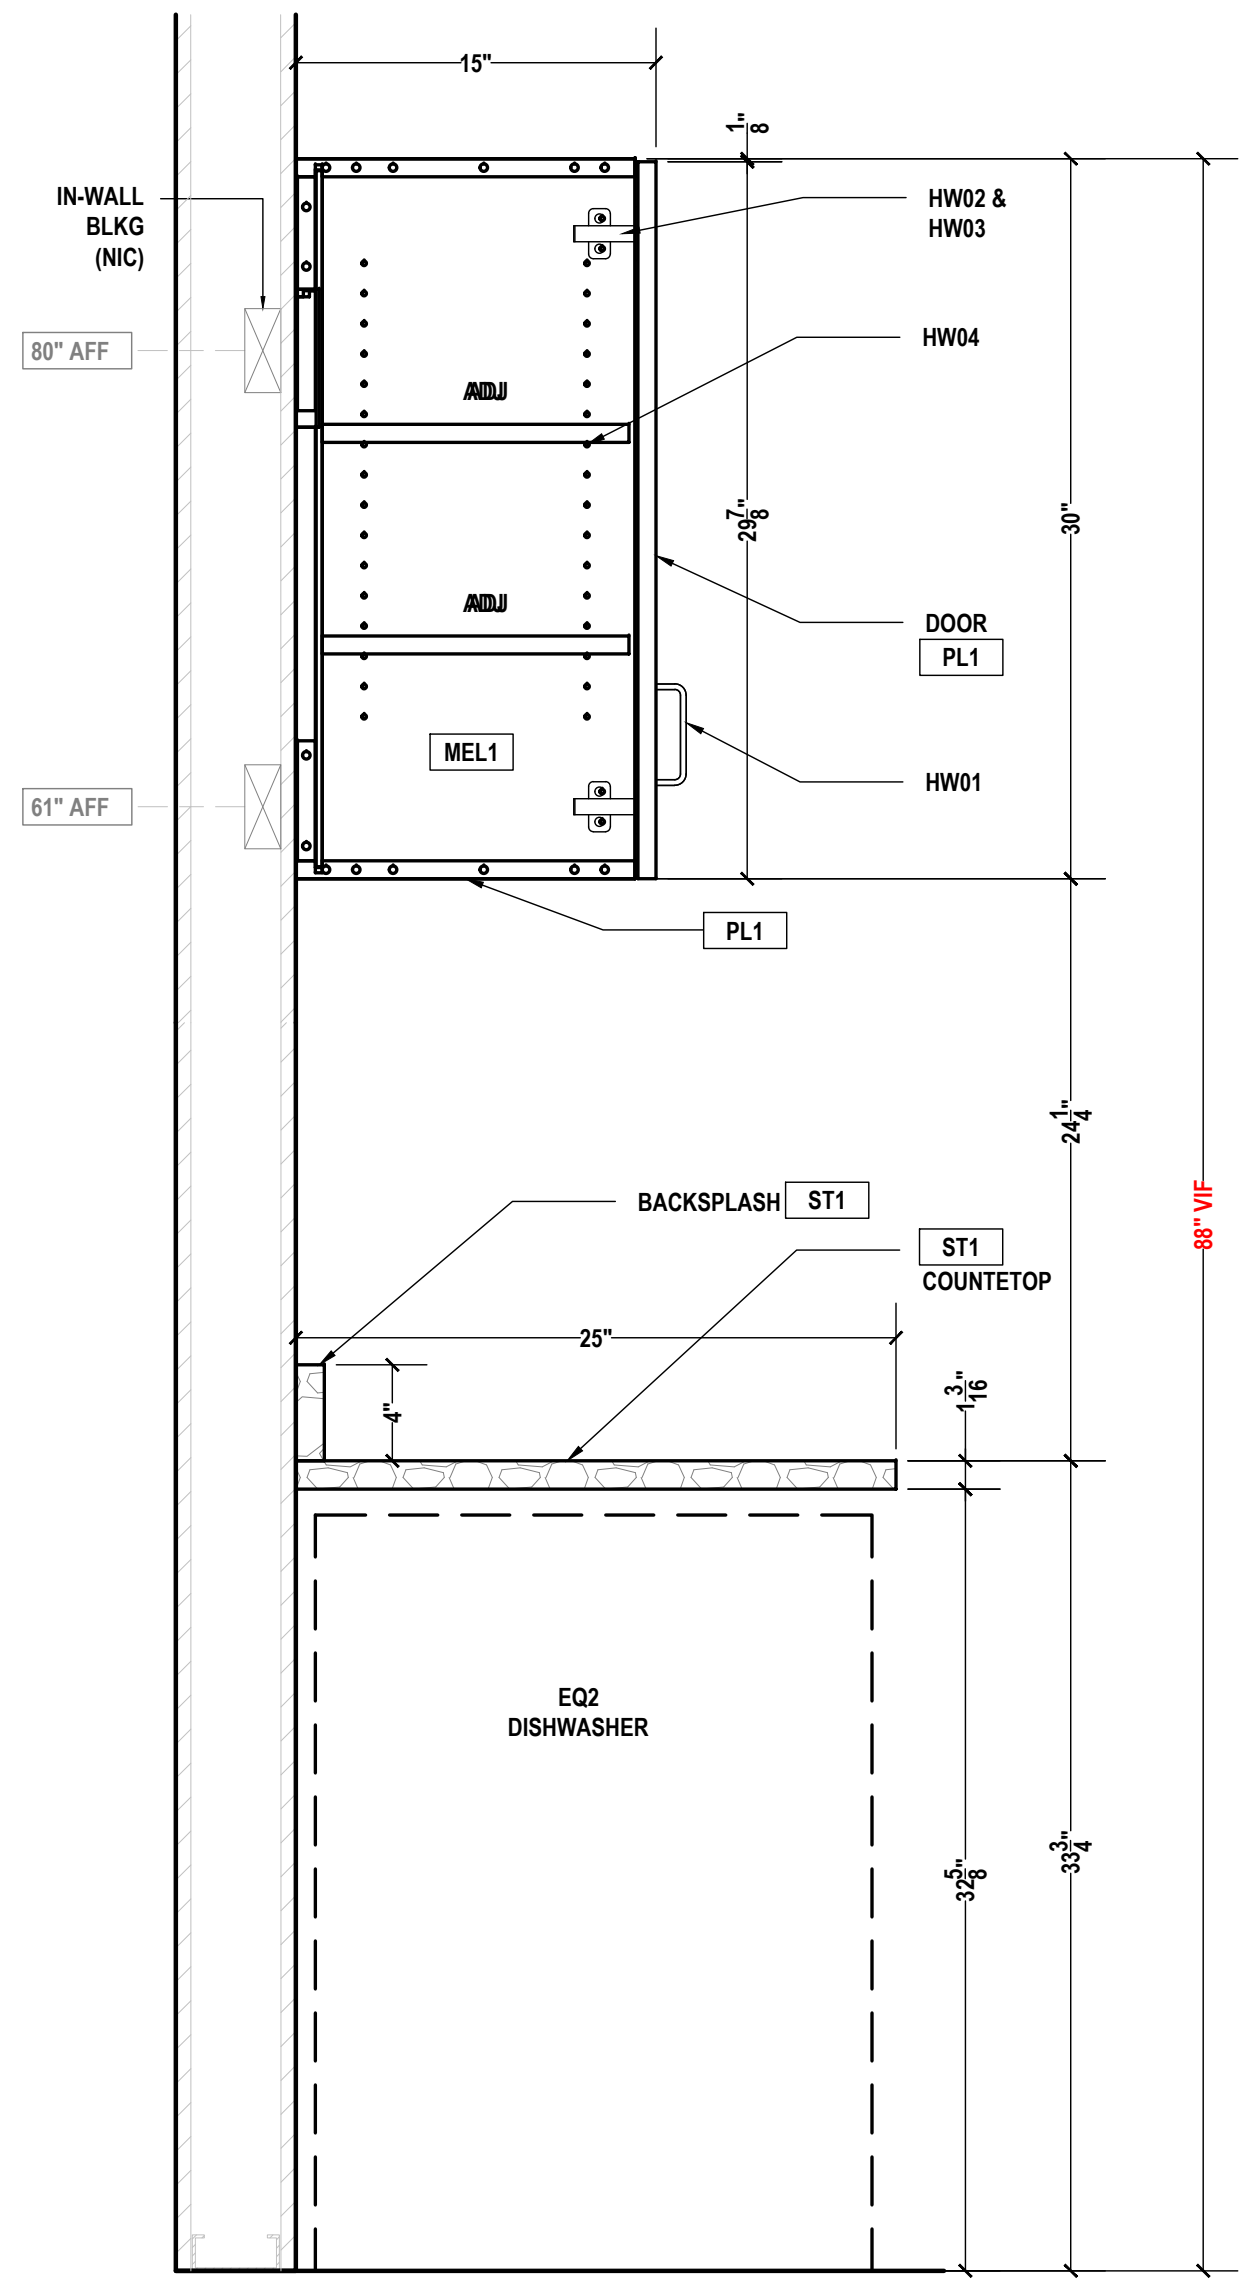

C WORKING ROOM A108
SECTION
SCALE: 1-1/2"=1'-0" ARCH REF.: 23/A604B

88" VIF

PROJECT:
SAMPLE DRAWINGS

PROJECT ADDRESS:
ORANGE AVE, NASHVILLE, TN

ARCHITECT:
FREDDY C.

G.C.:
PAOLO P.

	QCP	YES <input checked="" type="checkbox"/>	NO <input type="checkbox"/>
	LEED	YES <input type="checkbox"/>	NO <input checked="" type="checkbox"/>
	FSC	YES <input type="checkbox"/>	NO <input checked="" type="checkbox"/>
	NAUF	YES <input type="checkbox"/>	NO <input checked="" type="checkbox"/>

FINISHES:

PLASTIC LAMINATE	
KEY	COLOR
PL1	CARBON, TRUMATTE, BLACK
STONE	
KEY	COLOR
ST1	CAESARSTONE 5121 LAYATILE
INTERIOR FINISHES	
KEY	COLOR
MEL1	WHITE MELAMINE


PM:	ERW
DRAWN BY:	TMS
DATE DRAWN:	02/10/2023
REVIEWED BY:	LCT (LOC)

REVISIONS:


No.	DATE	DESCRIPTIONS	BY:
△	-	-	-
△	-	-	-
△	-	-	-
△	-	-	-
△	-	-	-
△	-	-	-
△	-	-	-

APPROVAL DATE	-
PLOT DATE	07/11/2024
PROJECT NUMBER	P-5567446
ROOM NAME	WORKING RM A108
SHEET NUMBER	104.04


NOTE: UPPER CABINET SHOULD BE ALIGN WITH FULL HEIGHT FINISHED PANEL

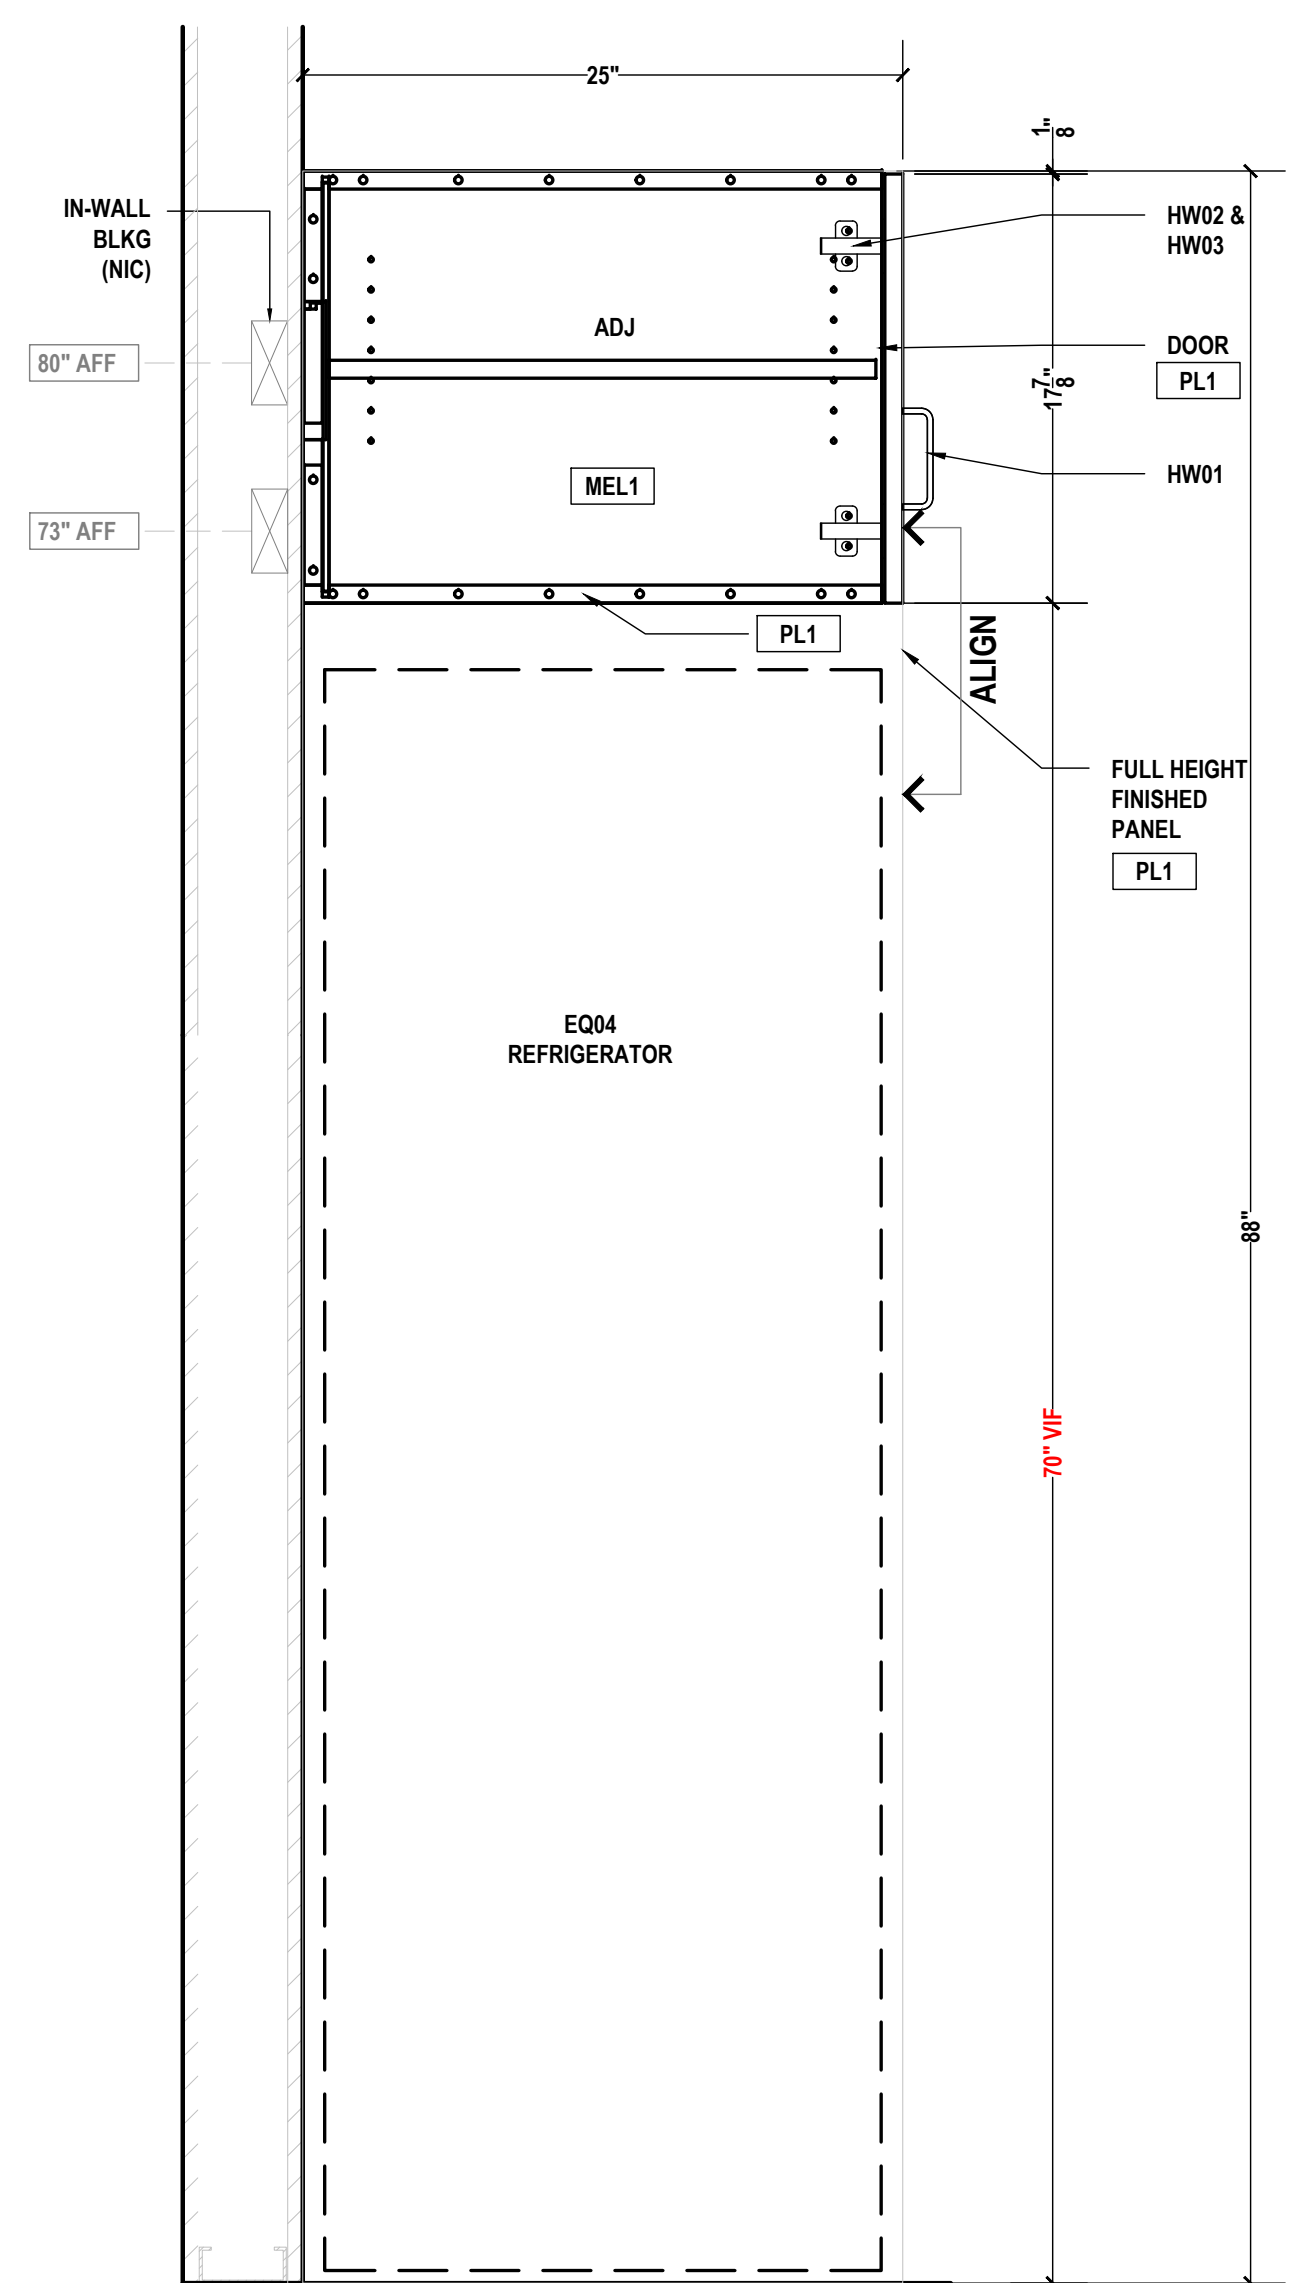

D WORKING ROOM A108 SECTION
SCALE: 1-1/2"=1'-0" ARCH REF.: 24/A604B

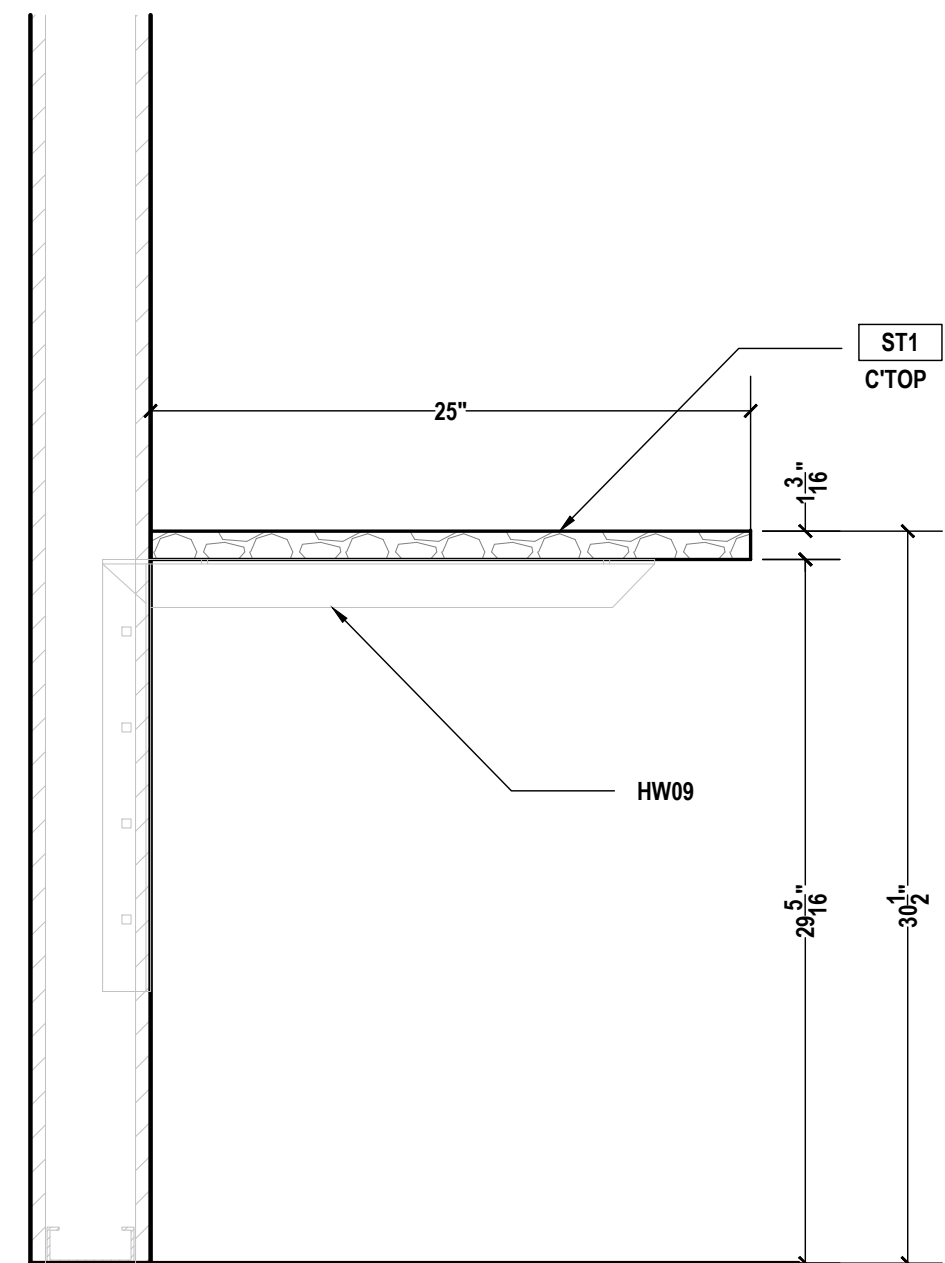

E WORKING ROOM A108 SECTION
SCALE: 1-1/2"=1'-0" ARCH REF.: 25/A604B

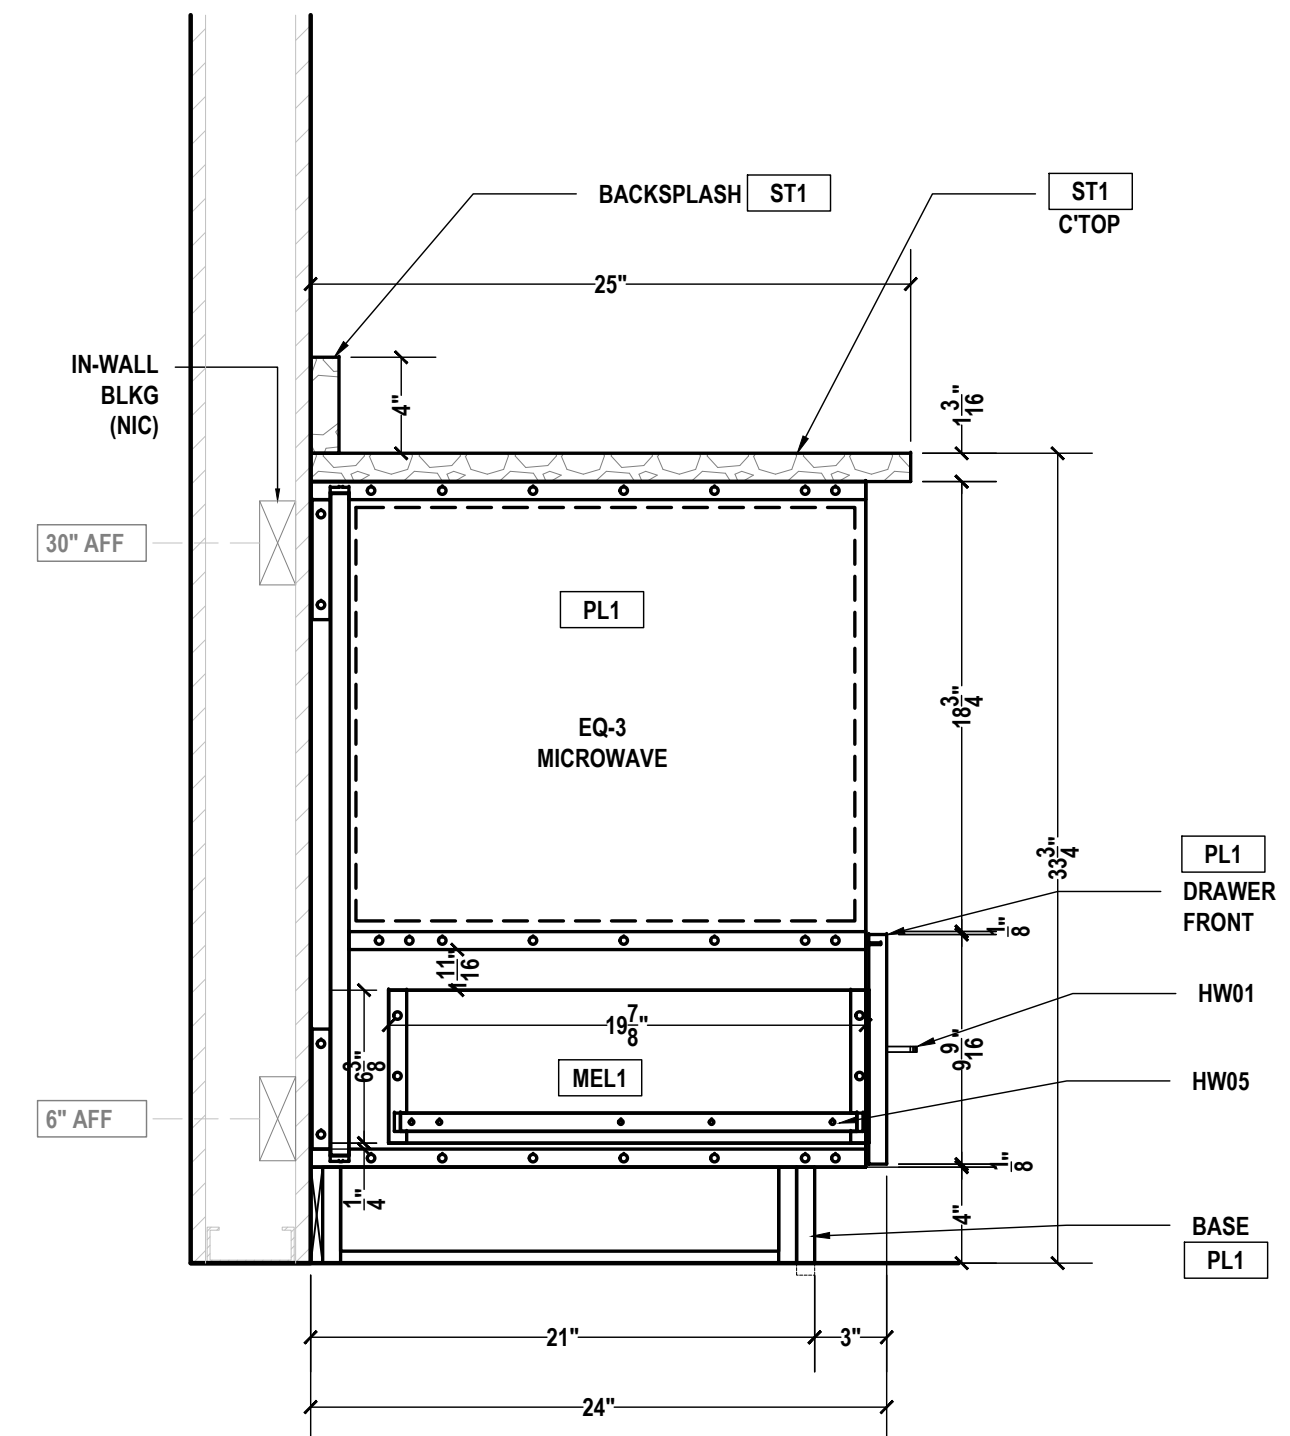

F WORKING ROOM A108 SECTION
SCALE: 1-1/2"=1'-0" ARCH REF.: 26/A604B

PROJECT:
SAMPLE DRAWINGS

PROJECT ADDRESS:
ORANGE AVE, NASHVILLE, TN

ARCHITECT:
FREDDY C.

G.C.:
PAOLO P.

	QCP	YES <input checked="" type="checkbox"/>	NO <input type="checkbox"/>
	LEED	YES <input type="checkbox"/>	NO <input checked="" type="checkbox"/>
	FSC	YES <input type="checkbox"/>	NO <input checked="" type="checkbox"/>
	NAUF	YES <input type="checkbox"/>	NO <input checked="" type="checkbox"/>

FINISHES:


PLASTIC LAMINATE	
KEY	COLOR
PL1	CARBON, TRUMATTE, BLACK
STONE	
KEY	COLOR
ST1	CAESARSTONE 5121 LAYATILE
INTERIOR FINISHES	
KEY	COLOR
MEL1	WHITE MELAMINE

PM:	ERW
DRAWN BY:	TMS
DATE DRAWN:	02/10/2023
REVIEWED BY:	LCT (LOC)


REVISIONS:

No.	DATE	DESCRIPTIONS	BY:
△	-	-	-
△	-	-	-
△	-	-	-
△	-	-	-
△	-	-	-
△	-	-	-
△	-	-	-
△	-	-	-

APPROVAL DATE	-
PLOT DATE	07/11/2024
PROJECT NUMBER	P-5567446
ROOM NAME	WORKING RM A108
SHEET NUMBER	104.05

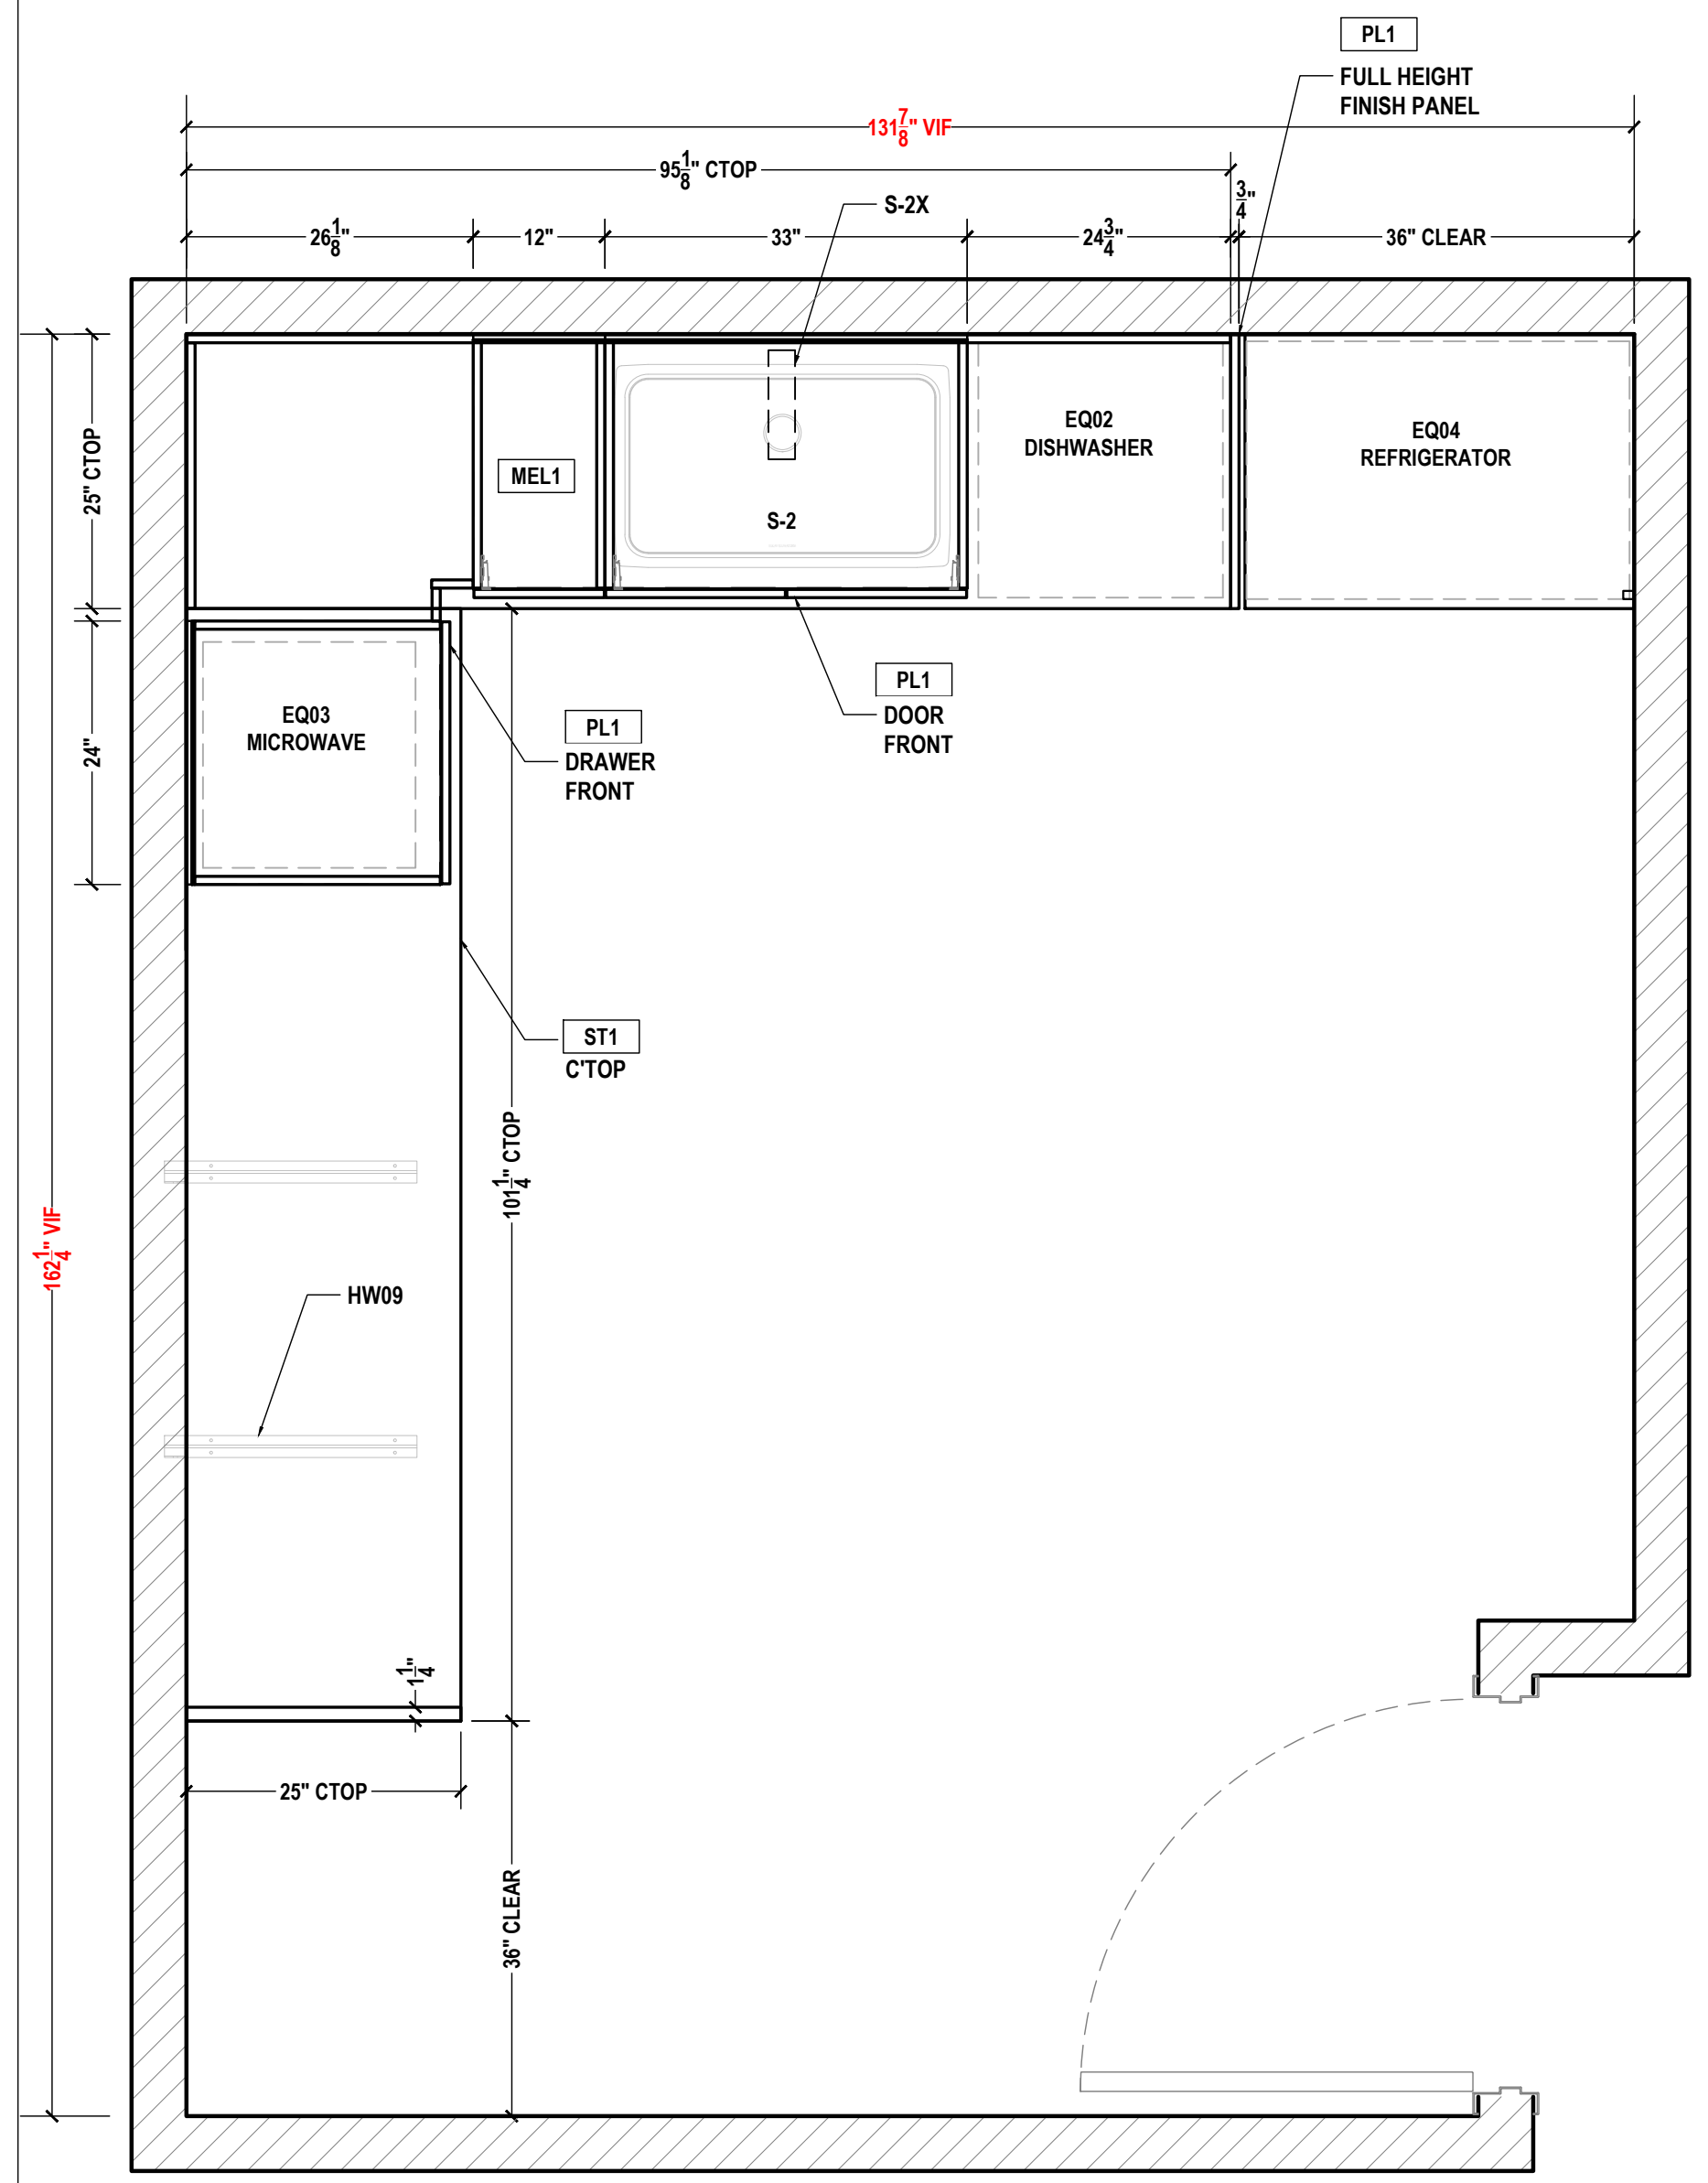

G WORKING ROOM A108
HORIZONTAL SECTION
SCALE: 3/4"=1'-0" ARCH REF.: N/A

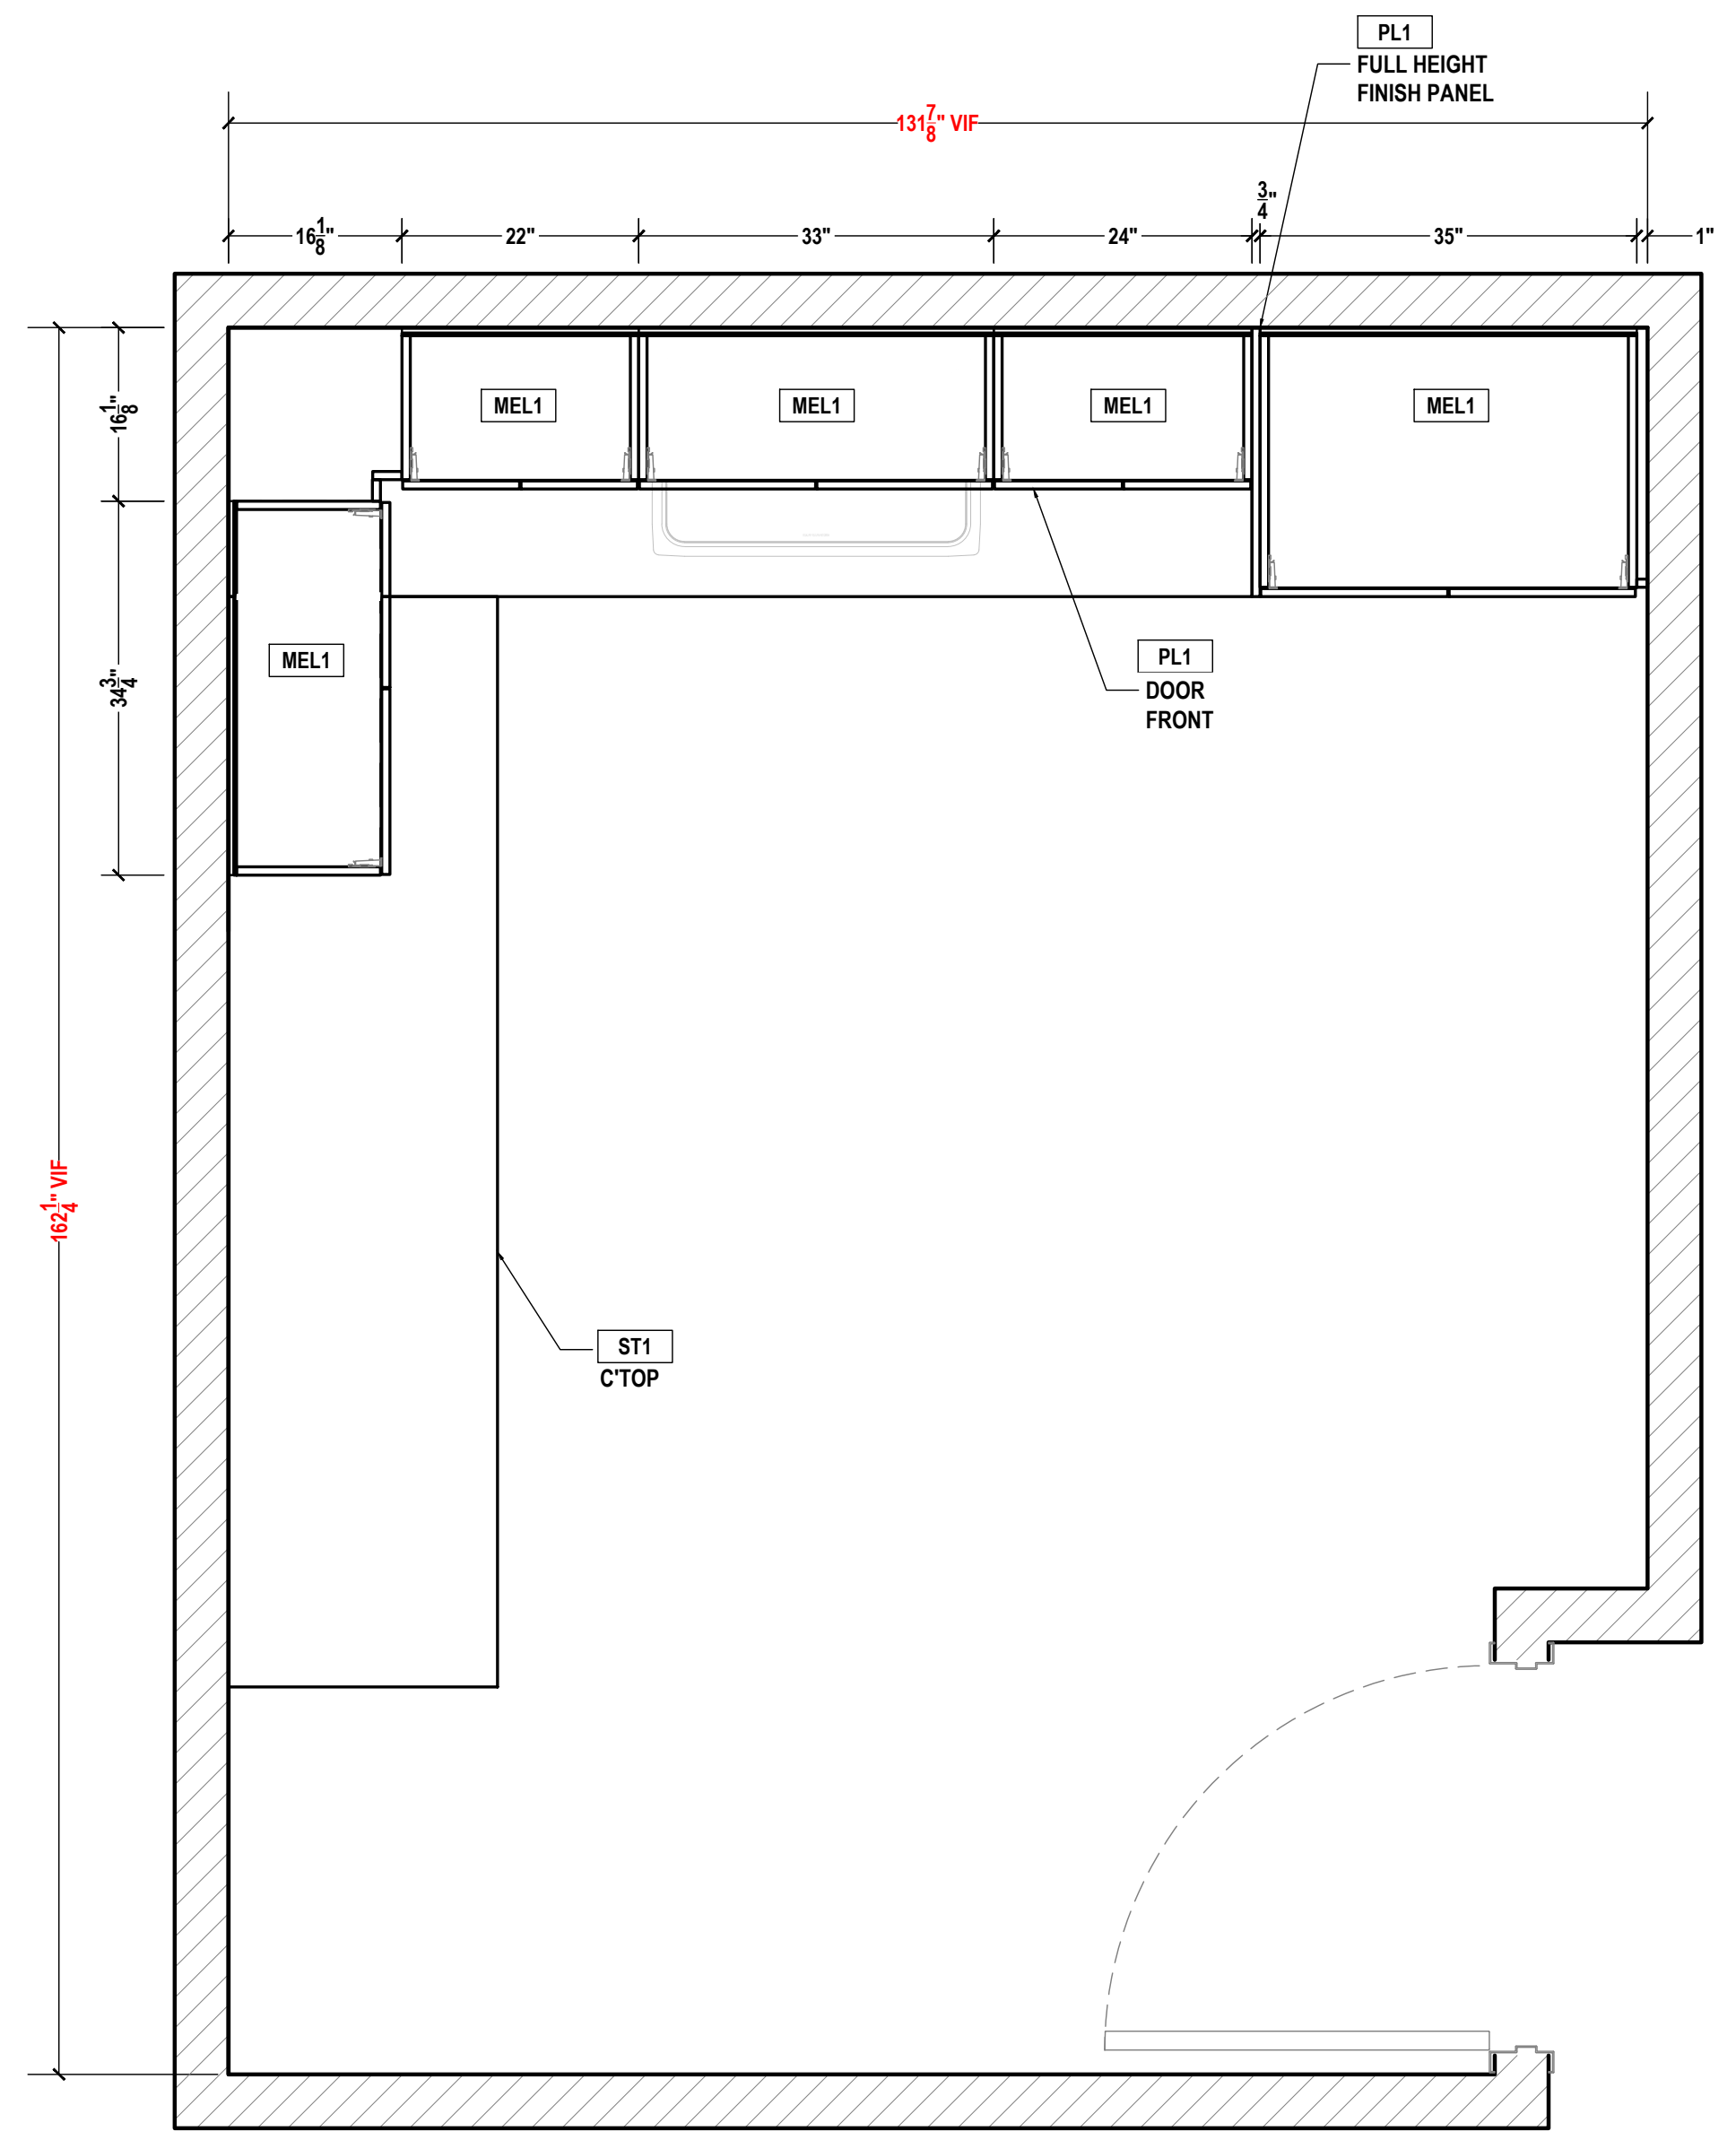

H WORKING ROOM A108
HORIZONTAL SECTION
SCALE: 3/4"=1'-0" ARCH REF.: N/A

PROJECT:
SAMPLE DRAWINGS

PROJECT ADDRESS:
ORANGE AVE, NASHVILLE, TN

ARCHITECT:
FREDDY C.

G.C.:
PAOLO P.

	QCP	YES <input checked="" type="checkbox"/>	NO <input type="checkbox"/>
	LEED	YES <input type="checkbox"/>	NO <input checked="" type="checkbox"/>
	FSC	YES <input type="checkbox"/>	NO <input checked="" type="checkbox"/>
	NAUF	YES <input type="checkbox"/>	NO <input checked="" type="checkbox"/>

FINISHES:


PLASTIC LAMINATE	
KEY	COLOR
PL1	CARBON, TRUMATTE, BLACK
STONE	
KEY	COLOR
ST1	CAESARSTONE 5121 LAYATILE
INTERIOR FINISHES	
KEY	COLOR
MEL1	WHITE MELAMINE

PM:	ERW
DRAWN BY:	TMS
DATE DRAWN:	02/10/2023
REVIEWED BY:	LCT (LOC)

REVISIONS:

No.	DATE:	DESCRIPTIONS:	BY:
△	-	-	-
△	-	-	-
△	-	-	-
△	-	-	-
△	-	-	-
△	-	-	-
△	-	-	-
△	-	-	-

APPROVAL DATE	-
PLOT DATE	07/11/2024
PROJECT NUMBER	P-5567446
ROOM NAME	BREAK ROOM A204
SHEET NUMBER	105.01

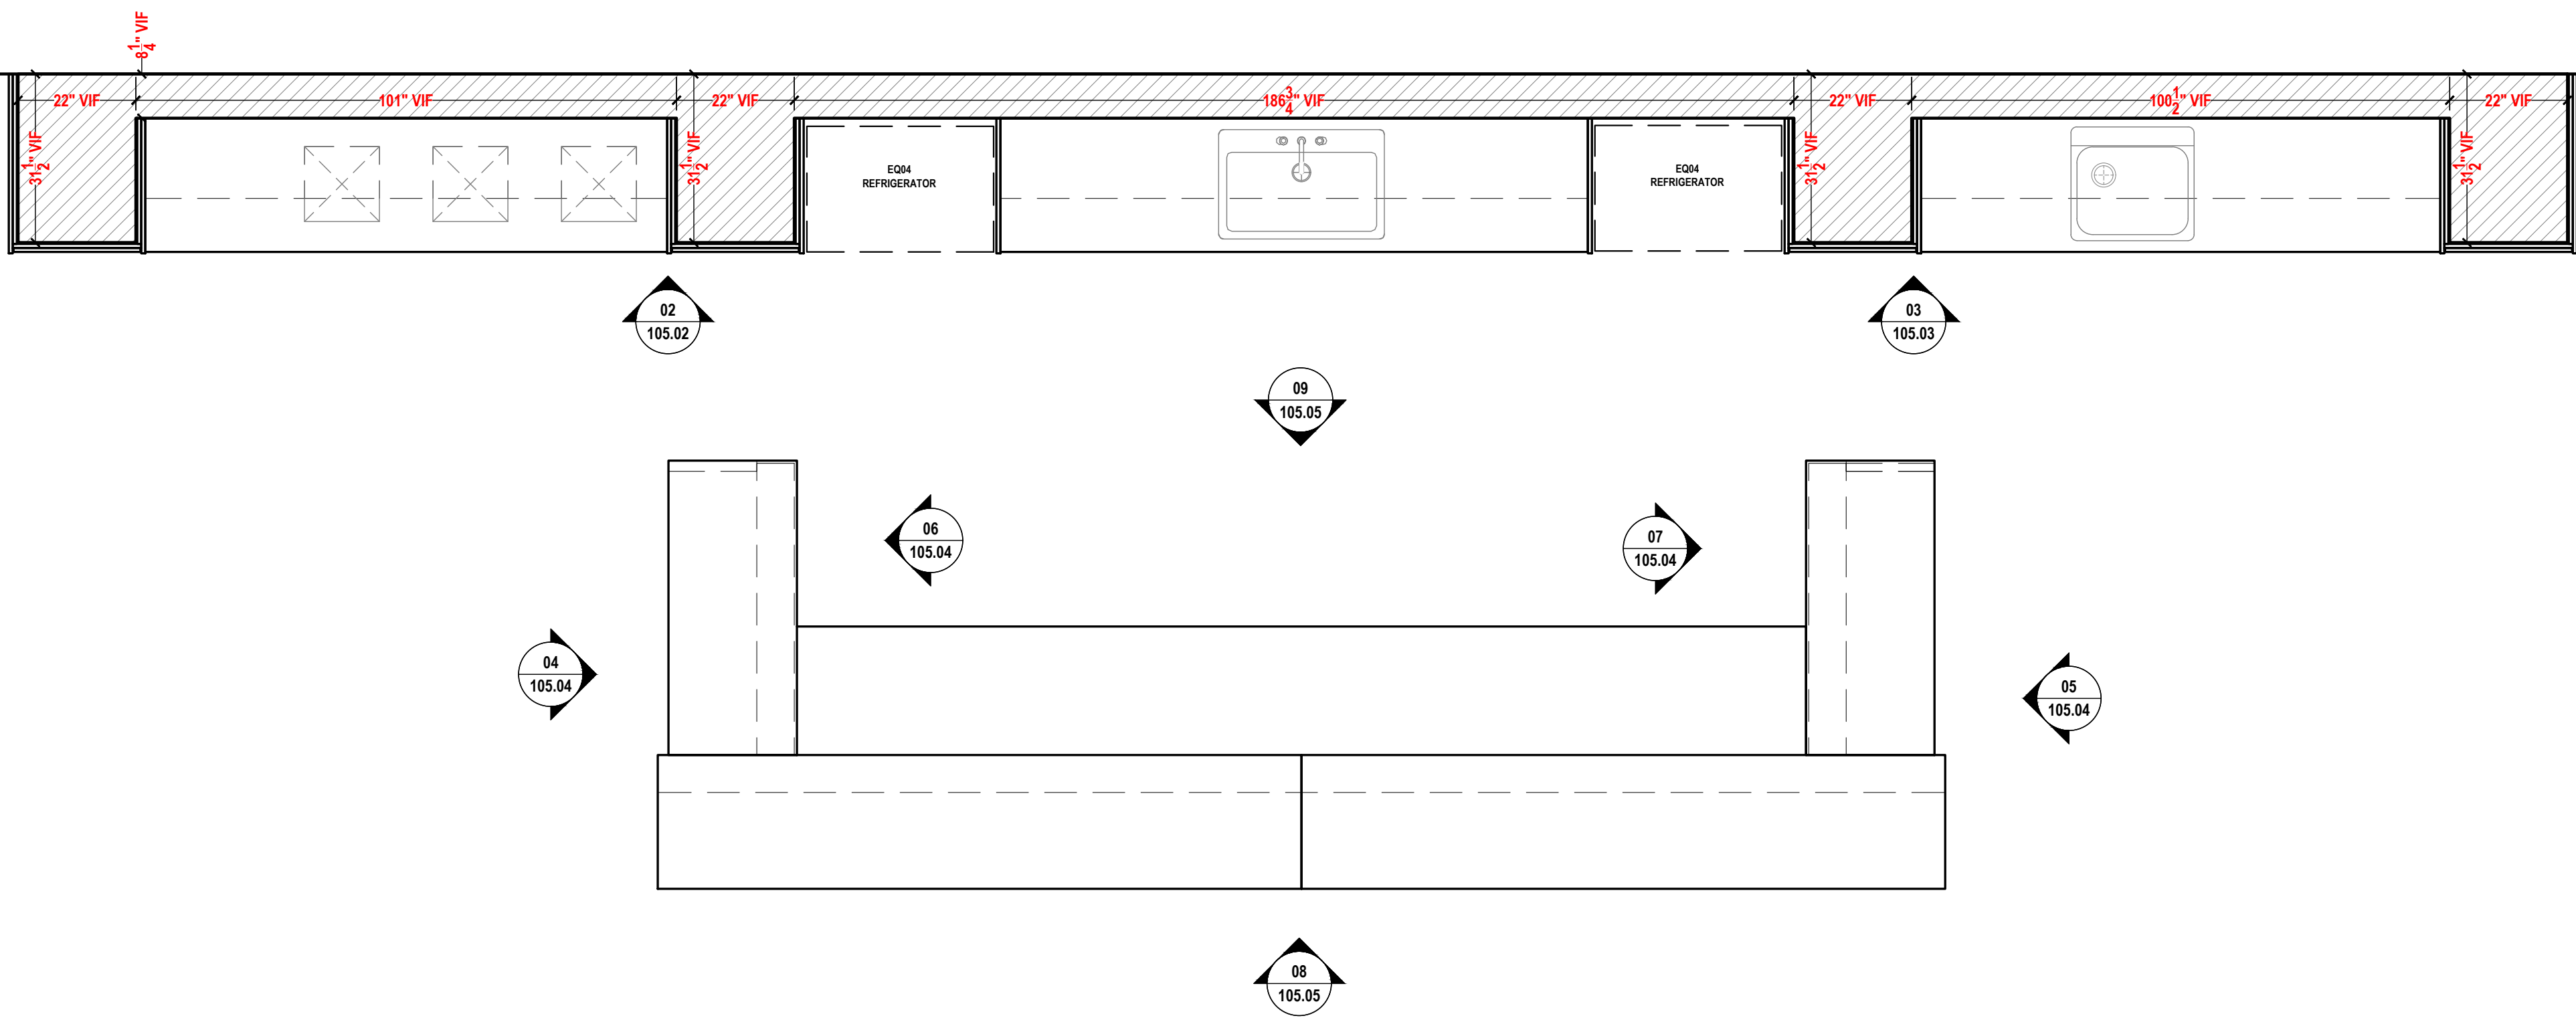

01 BREAK ROOM A204
PLAN VIEW
SCALE: 1/2"=1'-0" ARCH REF.: A1/A608

**** NOTE TO ARCH AND G.C. ****
REFERENCE RFI LIST ON SHEET 1CS.02
PLEASE PROVIDE EQUIPMENT SPECIFICATIONS.

PROJECT:
SAMPLE DRAWINGS

PROJECT ADDRESS:
ORANGE AVE, NASHVILLE, TN

ARCHITECT:
FREDDY C.

G.C.:
PAOLO P.

	QCP	YES <input type="checkbox"/>	NO <input type="checkbox"/>
	LEED	YES <input type="checkbox"/>	NO <input type="checkbox"/>
	FSC	YES <input type="checkbox"/>	NO <input type="checkbox"/>
	NAUF	YES <input type="checkbox"/>	NO <input type="checkbox"/>

FINISHES:


PLASTIC LAMINATE	
KEY	COLOR
PL1	CARBON, TRUMATTE, BLACK
STONE	
KEY	COLOR
ST1	CAESARSTONE 5121 LAYATILE
INTERIOR FINISHES	
KEY	COLOR
MEL1	WHITE MELAMINE

PM:	ERW
DRAWN BY:	TMS
DATE DRAWN:	02/10/2023
REVIEWED BY:	LCT (LOC)

REVISIONS:

No.	DATE	DESCRIPTIONS	BY:
△	-	-	-
△	-	-	-
△	-	-	-
△	-	-	-
△	-	-	-
△	-	-	-
△	-	-	-
△	-	-	-

APPROVAL DATE	-
PLOT DATE	07/11/2024
PROJECT NUMBER	P-5567446
ROOM NAME	BREAK ROOM A204
SHEET NUMBER	105.02

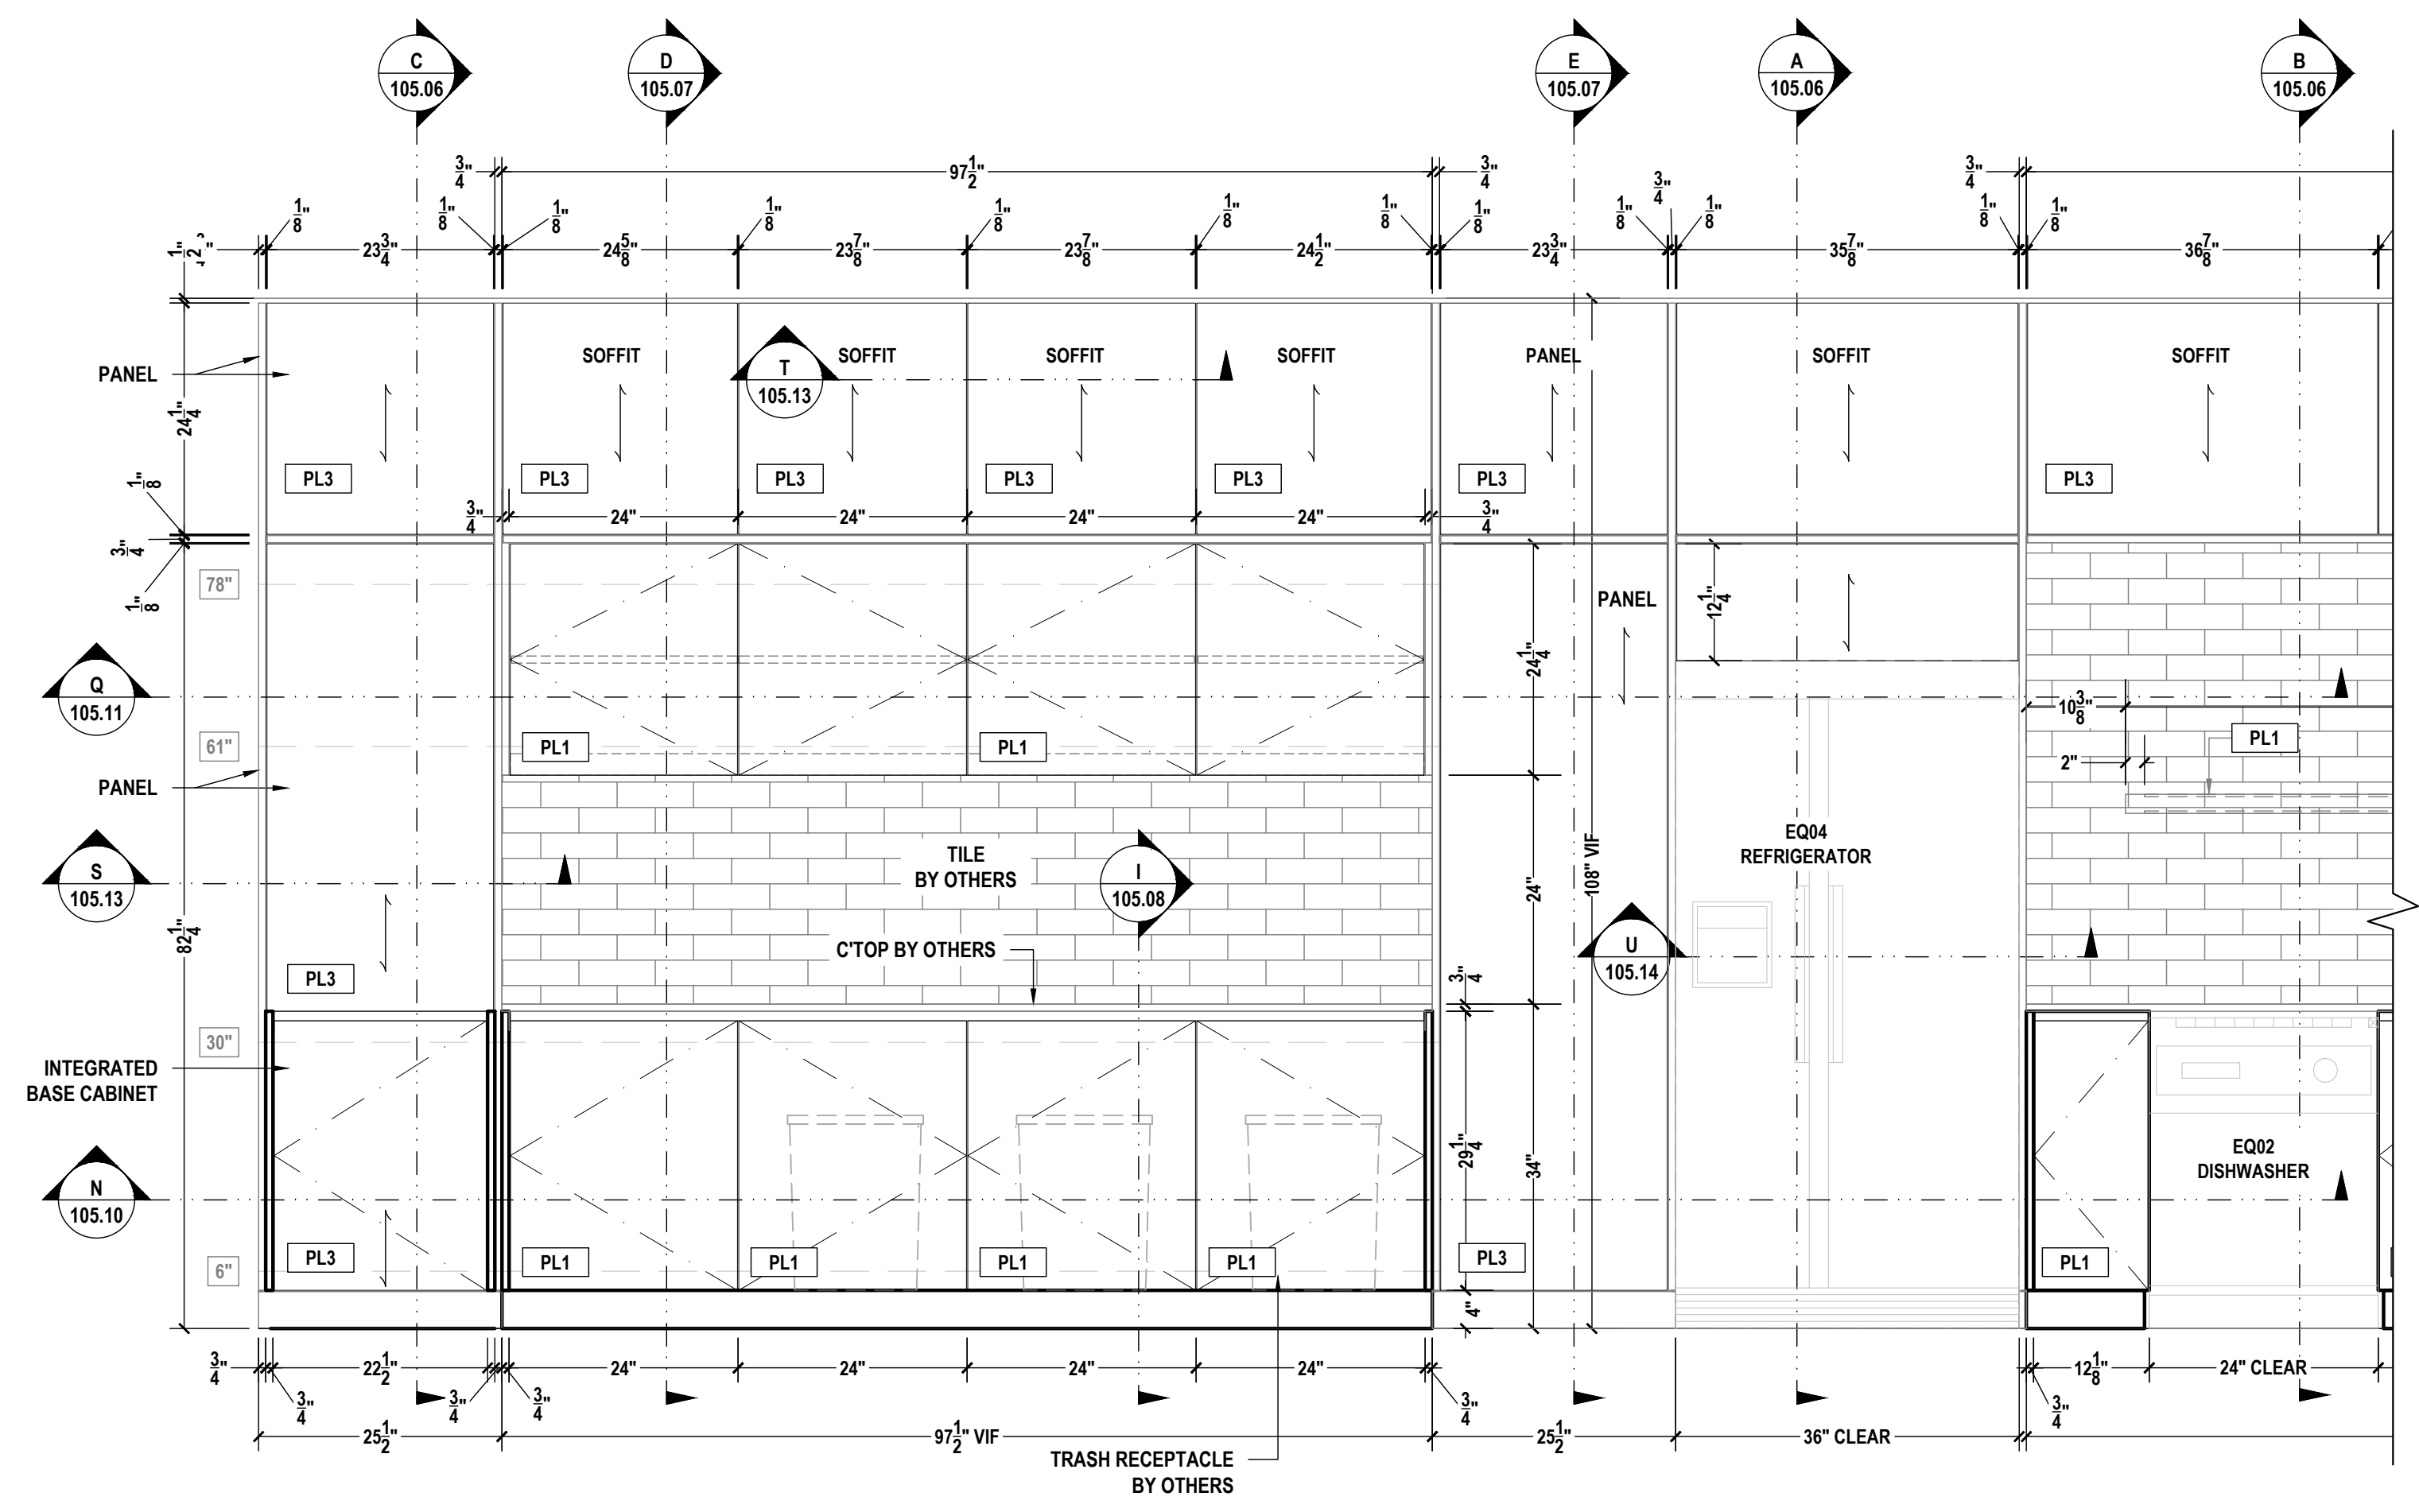

02 BREAK ROOM A204
ELEVATION
SCALE: 3/4"=1'-0" ARCH REF.: A2/A608

**** NOTE TO ARCH AND G.C. ****
REFERENCE RFI LIST ON SHEET 1CS.02

PLEASE PROVIDE P-2 AND P-2X SPECIFICATIONS.

PROJECT:
SAMPLE DRAWINGS

PROJECT ADDRESS:
ORANGE AVE, NASHVILLE, TN

ARCHITECT:
FREDDY C.

G.C.:
PAOLO P.

	QCP	YES <input checked="" type="checkbox"/>	NO <input type="checkbox"/>
	LEED	YES <input type="checkbox"/>	NO <input checked="" type="checkbox"/>
	FSC	YES <input type="checkbox"/>	NO <input checked="" type="checkbox"/>
	NAUF	YES <input type="checkbox"/>	NO <input checked="" type="checkbox"/>

FINISHES:


PLASTIC LAMINATE		
KEY	COLOR	
PL1	CARBON, TRUMATTE, BLACK	
STONE		
KEY	COLOR	
ST1	CAESARSTONE 5121 LAYATILE	
INTERIOR FINISHES		
KEY	COLOR	
WELL	WHITE MELAMINE	

PM:	ERW
DRAWN BY:	TMS
DATE DRAWN:	02/10/2023
REVIEWED BY:	LCT (LOC)

REVISIONS:

No.	DATE	DESCRIPTIONS	BY:
△	-	-	-
△	-	-	-
APPROVAL DATE	-
PLOT DATE	07/11/2024
PROJECT NUMBER	P-5567446
ROOM NAME	BREAK ROOM A204
SHEET NUMBER	105.03

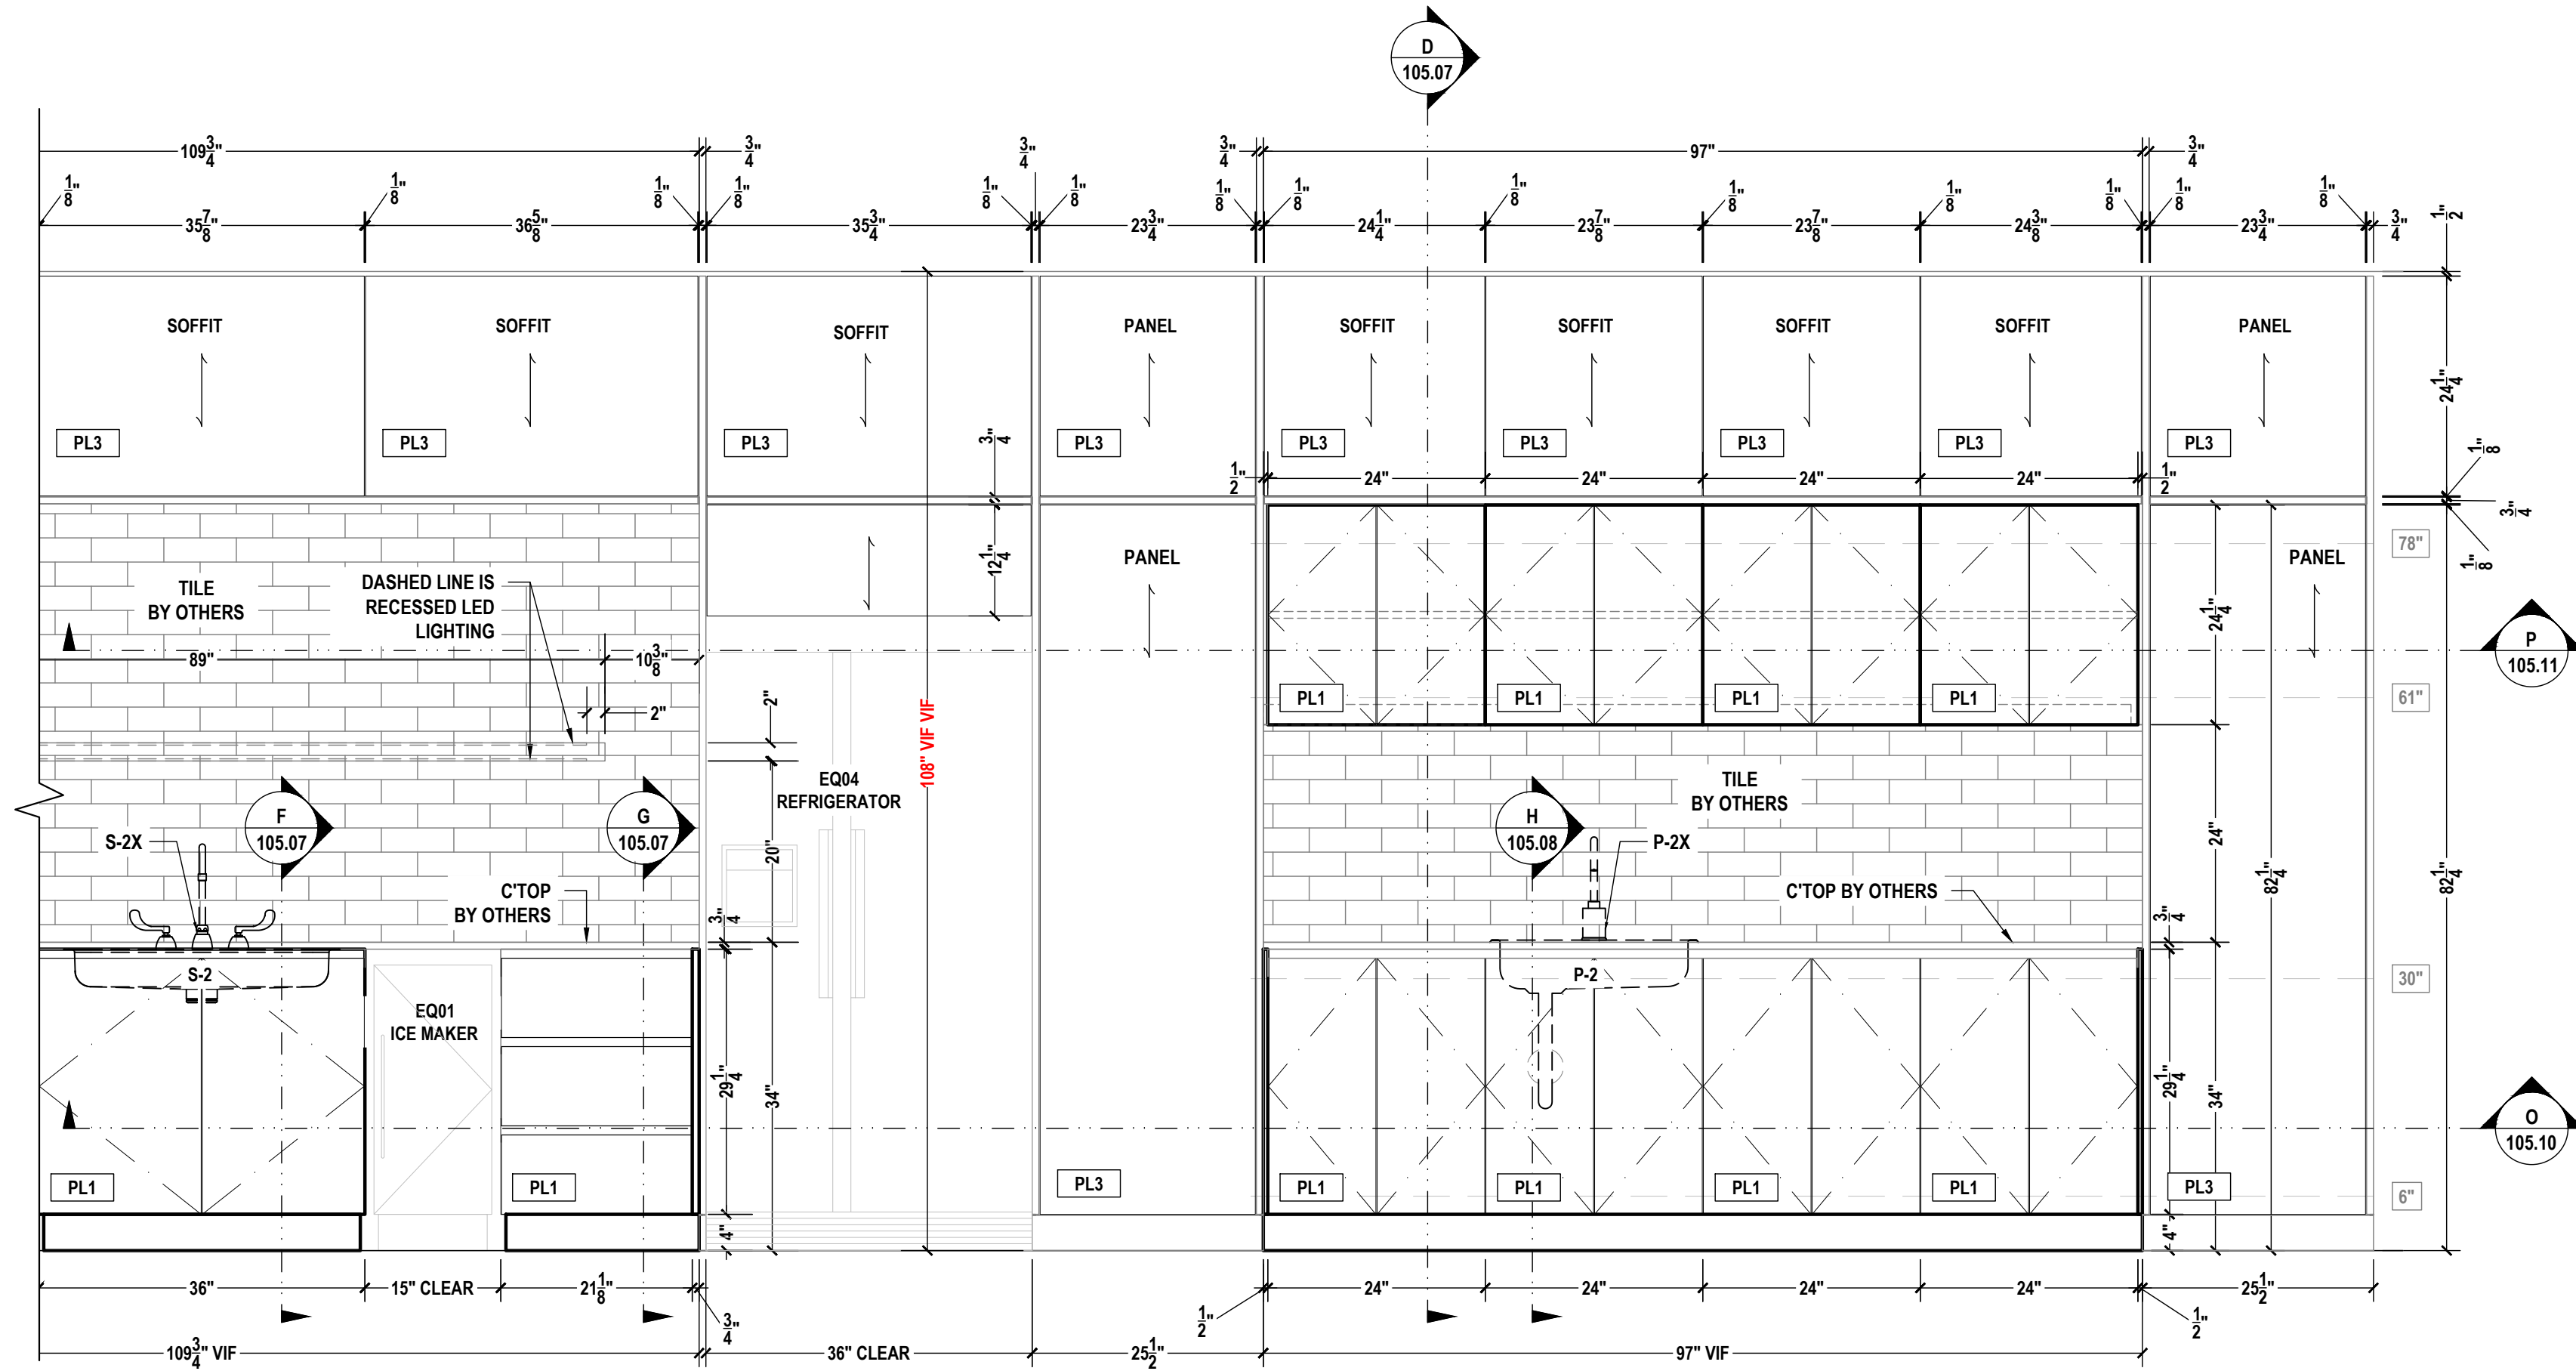

03 BREAK ROOM A204
ELEVATION
SCALE: 3/4"=1'-0" ARCH REF.: A2/A608

PROJECT:
SAMPLE DRAWINGS

PROJECT ADDRESS:
ORANGE AVE, NASHVILLE, TN

ARCHITECT:
FREDDY C.

G.C.:
PAOLO P.

	QCP	YES <input checked="" type="checkbox"/>	NO <input type="checkbox"/>
	LEED	YES <input type="checkbox"/>	NO <input checked="" type="checkbox"/>
	FSC	YES <input type="checkbox"/>	NO <input checked="" type="checkbox"/>
	NAUF	YES <input type="checkbox"/>	NO <input checked="" type="checkbox"/>

FINISHES:


PLASTIC LAMINATE	
KEY	COLOR
PL1	CARBON, TRUMATTE, BLACK
STONE	
KEY	COLOR
ST1	CAESARSTONE 5121 LAYATILE
INTERIOR FINISHES	
KEY	COLOR
MEL1	WHITE MELAMINE

PM:	ERW
DRAWN BY:	TMS
DATE DRAWN:	02/10/2023
REVIEWED BY:	LCT (LOC)


REVISIONS:

No.	DATE	DESCRIPTIONS	BY:
△	-	-	-
△	-	-	-
△	-	-	-
△	-	-	-
△	-	-	-
△	-	-	-
△	-	-	-
△	-	-	-
△	-	#	-


APPROVAL DATE	-
PLOT DATE	07/11/2024
PROJECT NUMBER	P-5567446
ROOM NAME	BREAK ROOM A204
SHEET NUMBER	105.04

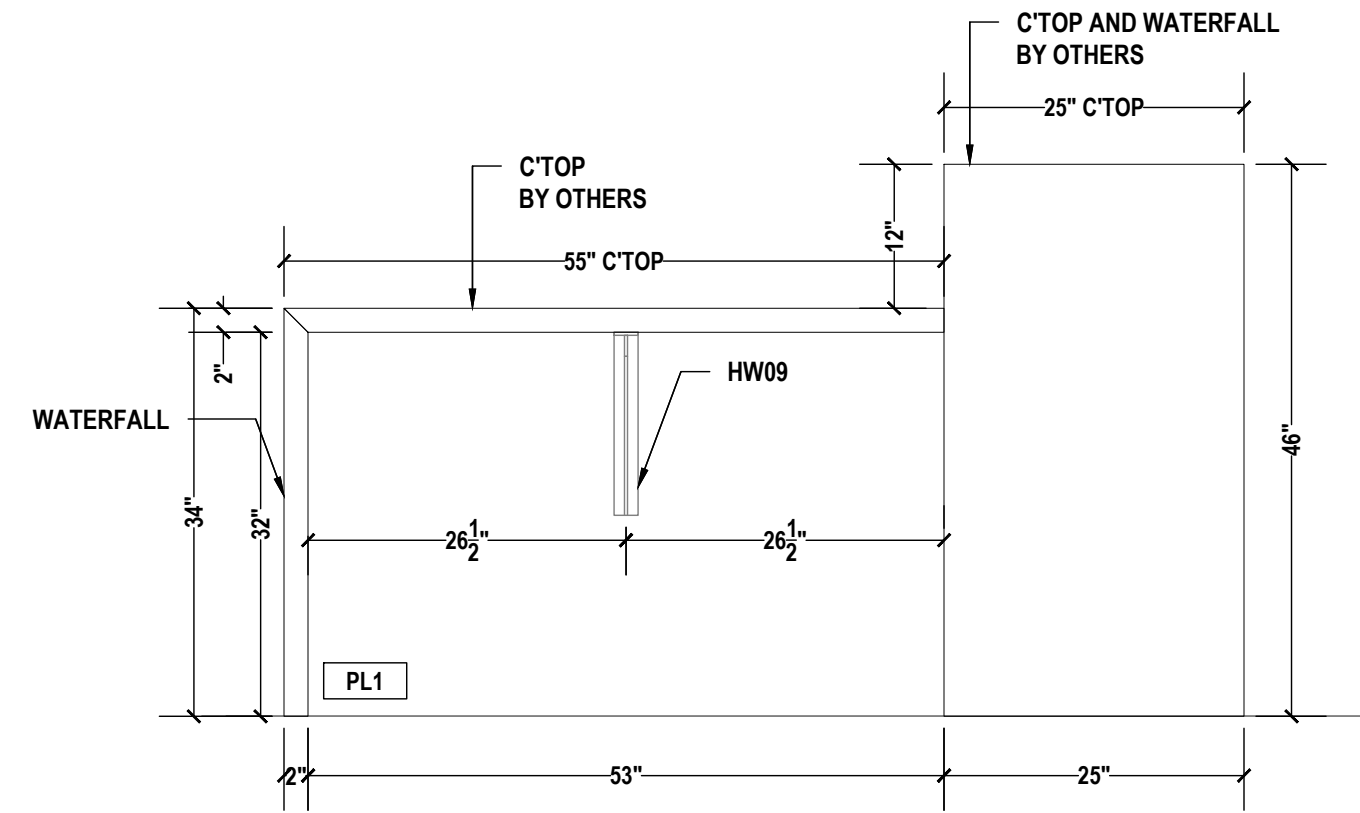


04 BREAK ROOM A204 ELEVATION
SCALE: 3/4"=1'-0" ARCH REF.: A3/A608

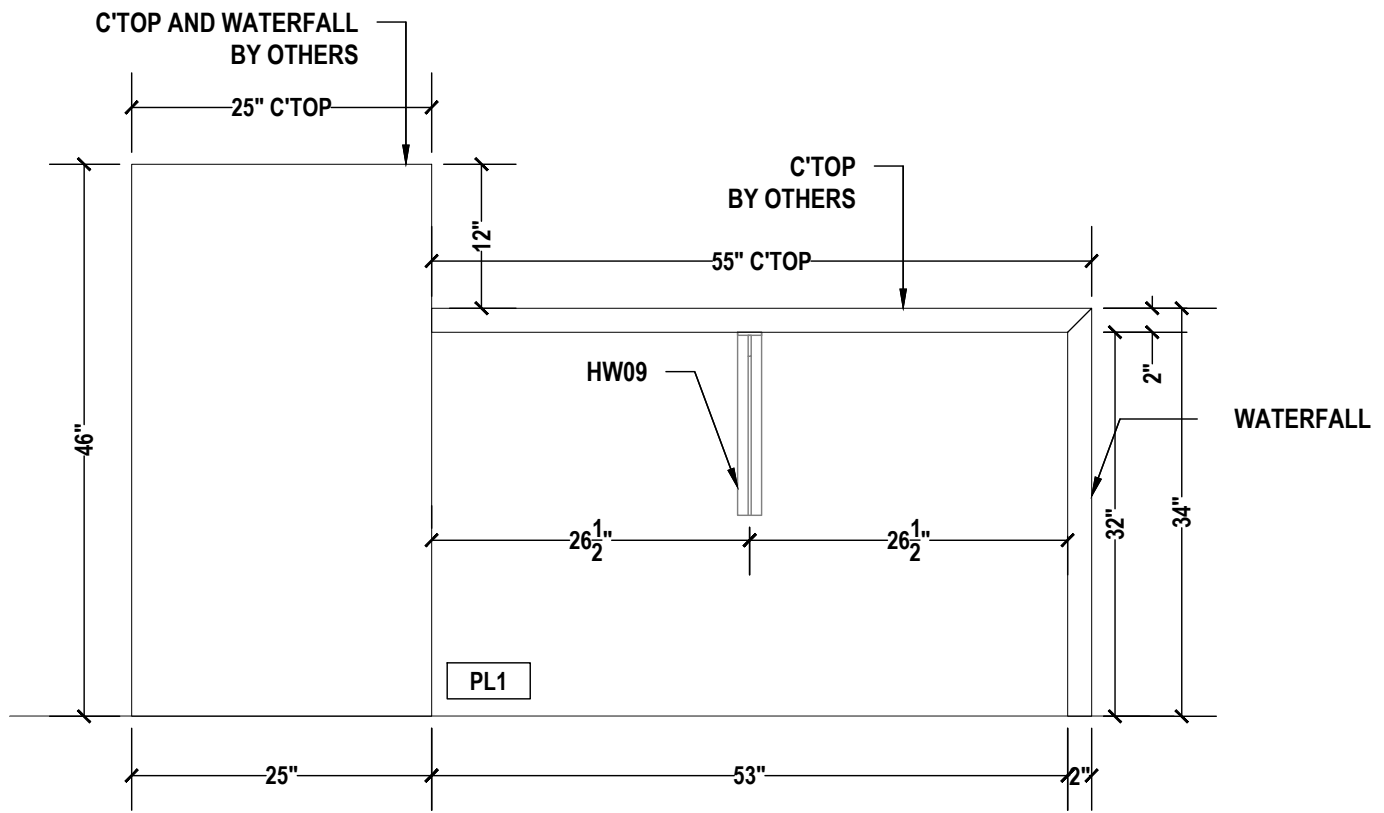

05 BREAK ROOM A204 ELEVATION
SCALE: 3/4"=1'-0" ARCH REF.: A4/A608

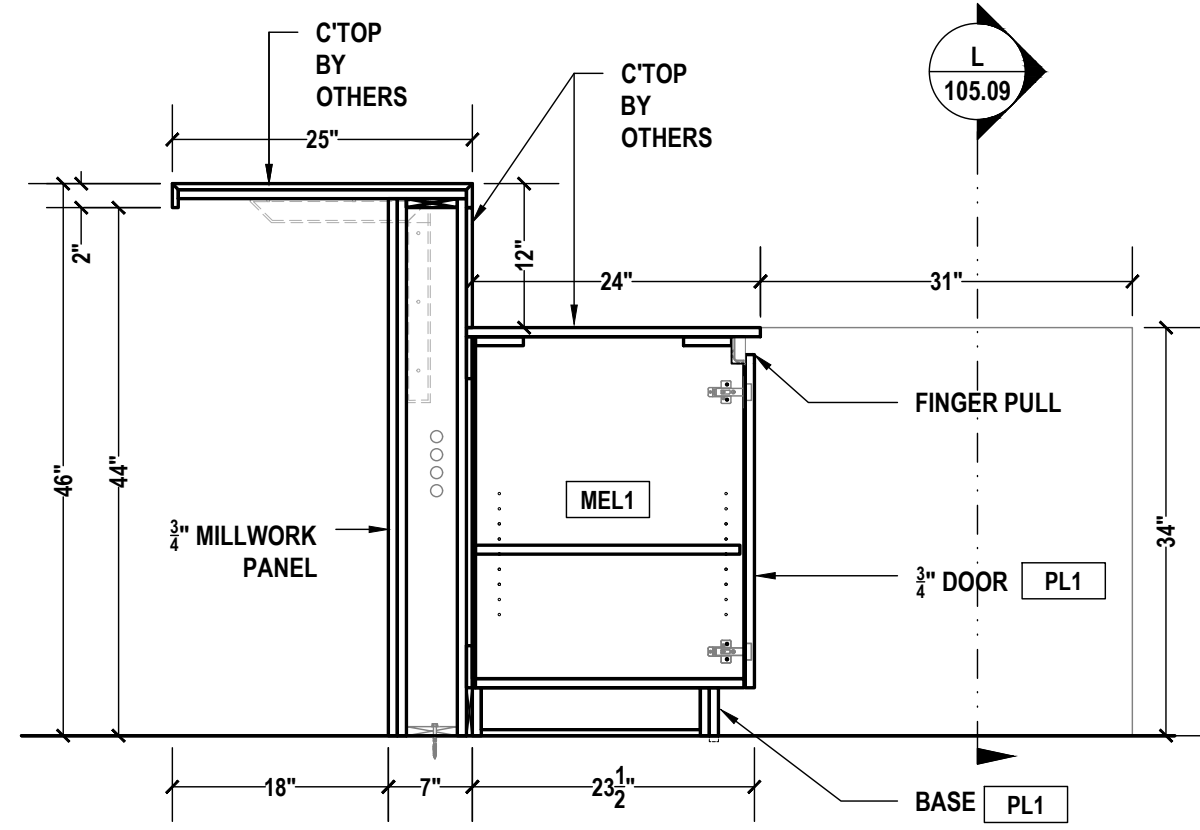

06 BREAK ROOM A204 ELEVATION
SCALE: 3/4"=1'-0" ARCH REF.: A6/A608

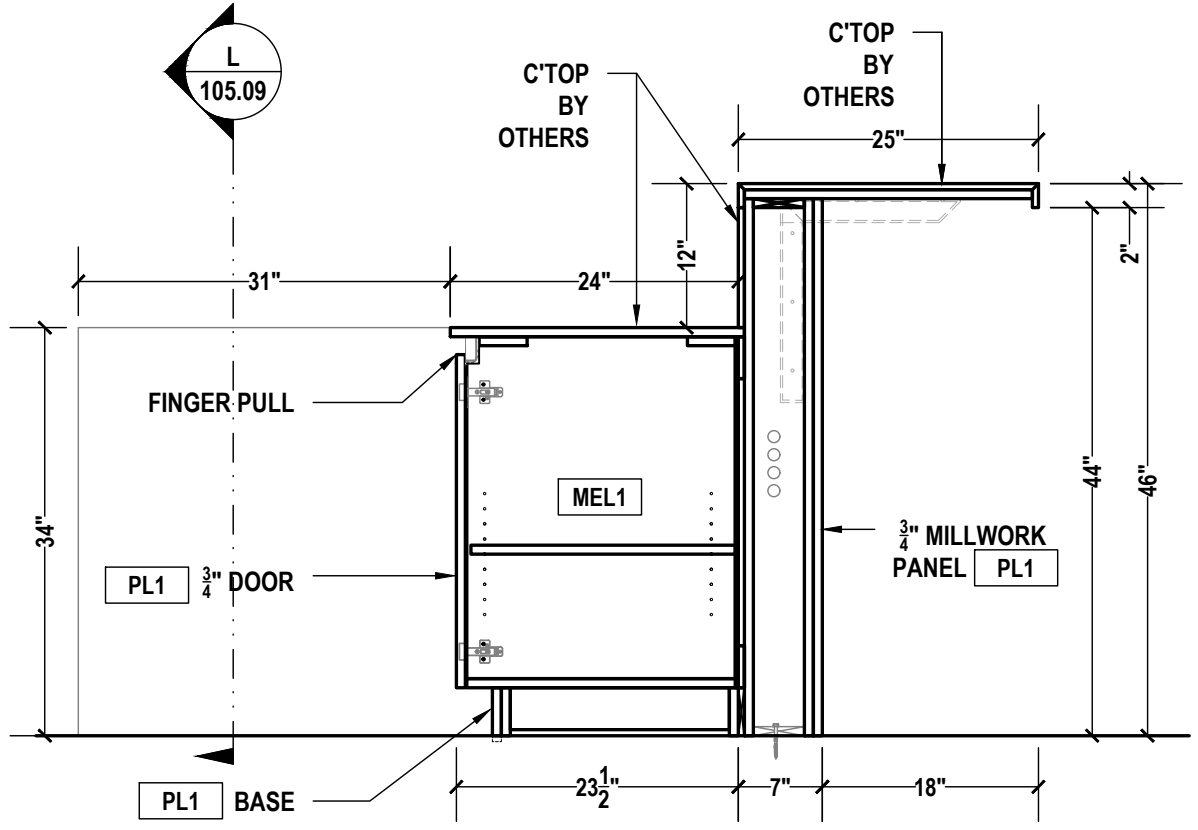

07 BREAK ROOM A204 ELEVATION
SCALE: 3/4"=1'-0" ARCH REF.: A7/A608


PROJECT:
SAMPLE DRAWINGS

PROJECT ADDRESS:
ORANGE AVE, NASHVILLE, TN

ARCHITECT:
FREDDY C.

G.C.:
PAOLO P.

	QCP	YES <input checked="" type="checkbox"/>	NO <input type="checkbox"/>
	LEED	YES <input type="checkbox"/>	NO <input checked="" type="checkbox"/>
	FSC	YES <input type="checkbox"/>	NO <input checked="" type="checkbox"/>
	NAUF	YES <input type="checkbox"/>	NO <input checked="" type="checkbox"/>

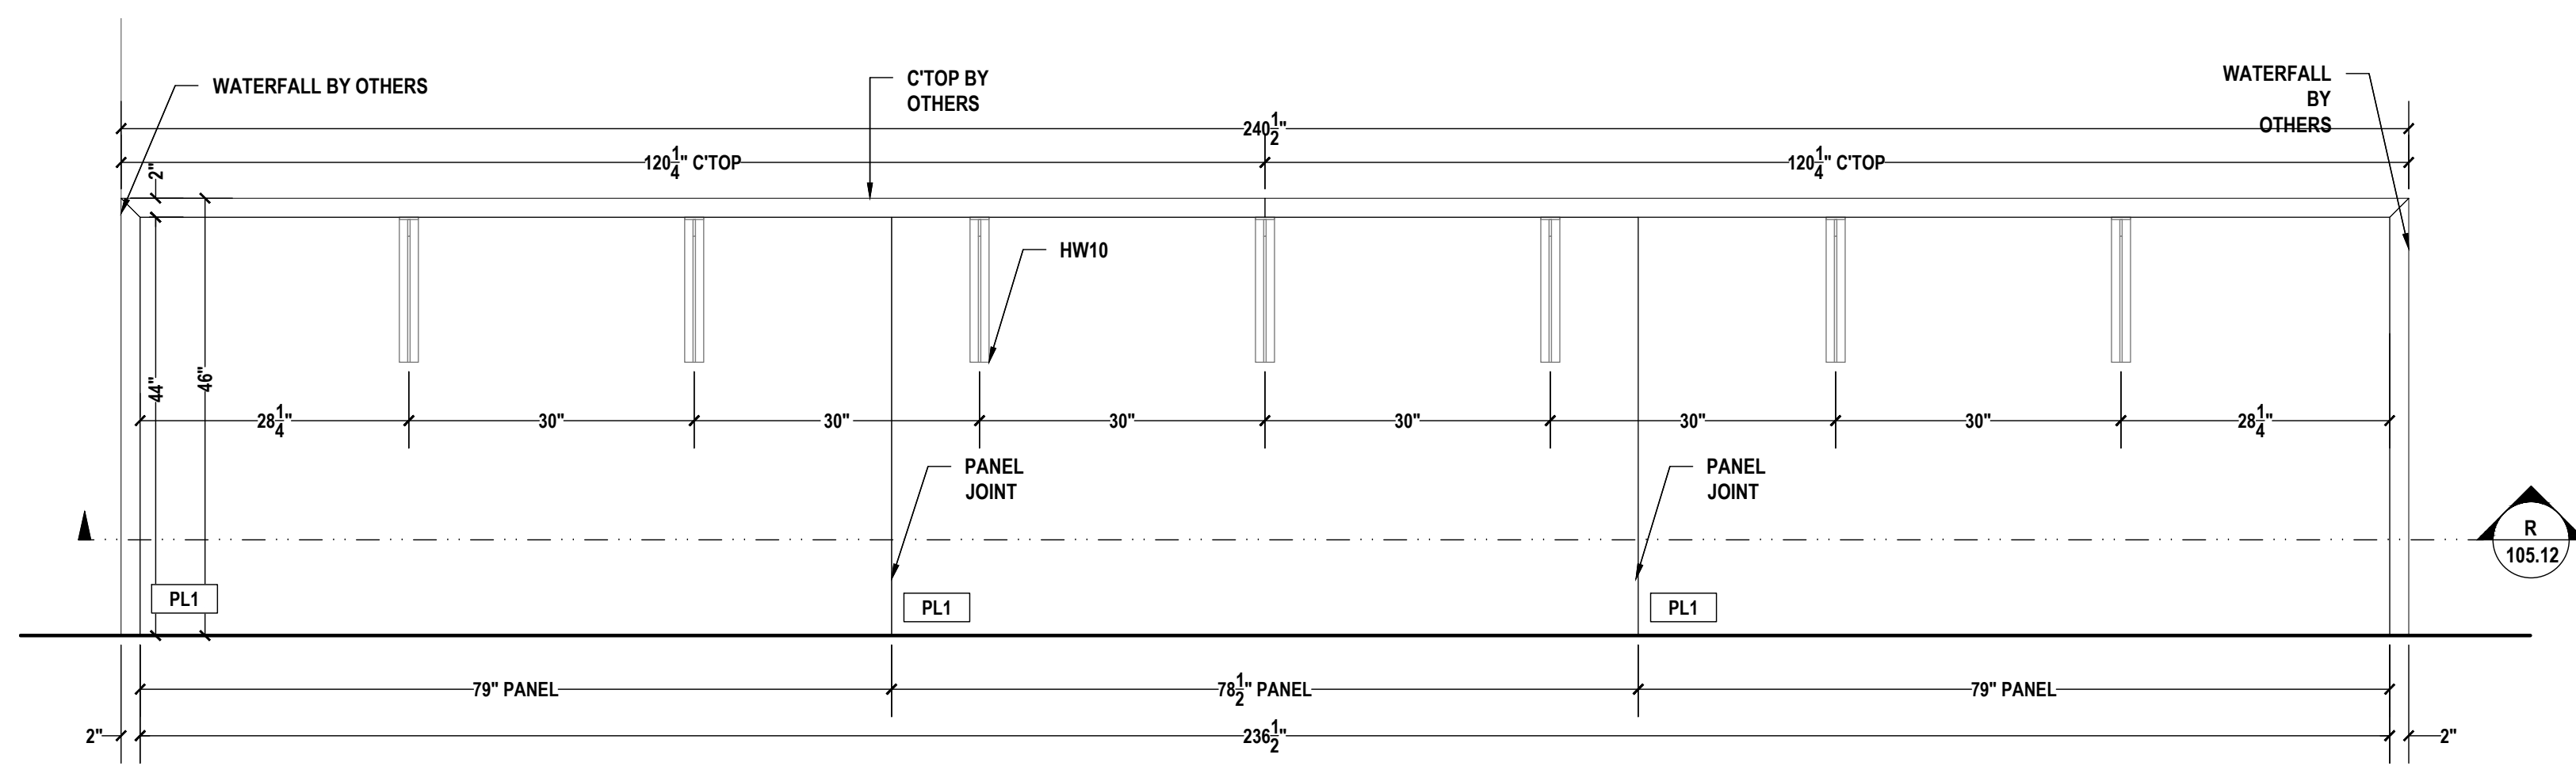

08 BREAK ROOM A204
ELEVATION
SCALE: 3/4"=1'-0" ARCH REF.: A5/A608

**** NOTE TO ARCH AND G.C. ****
REFERENCE RFI LIST ON SHEET 1CS.02
PLEASE PROVIDE EQ05, EQ06 AND EQ07 SPECIFICATIONS.


FINISHES:

PLASTIC LAMINATE	
KEY	COLOR
PL1	CARBON, TRUMATTE, BLACK
STONE	
KEY	COLOR
ST1	CAESARSTONE 5121 LAYATILE
INTERIOR FINISHES	
KEY	COLOR
MEL1	WHITE MELAMINE

PM:	ERW
DRAWN BY:	TMS
DATE DRAWN:	02/10/2023
REVIEWED BY:	LCT (LOC)

REVISIONS:

No.	DATE:	DESCRIPTIONS:	BY:
△	-	-	-
△	-	-	-
△	-	#	-

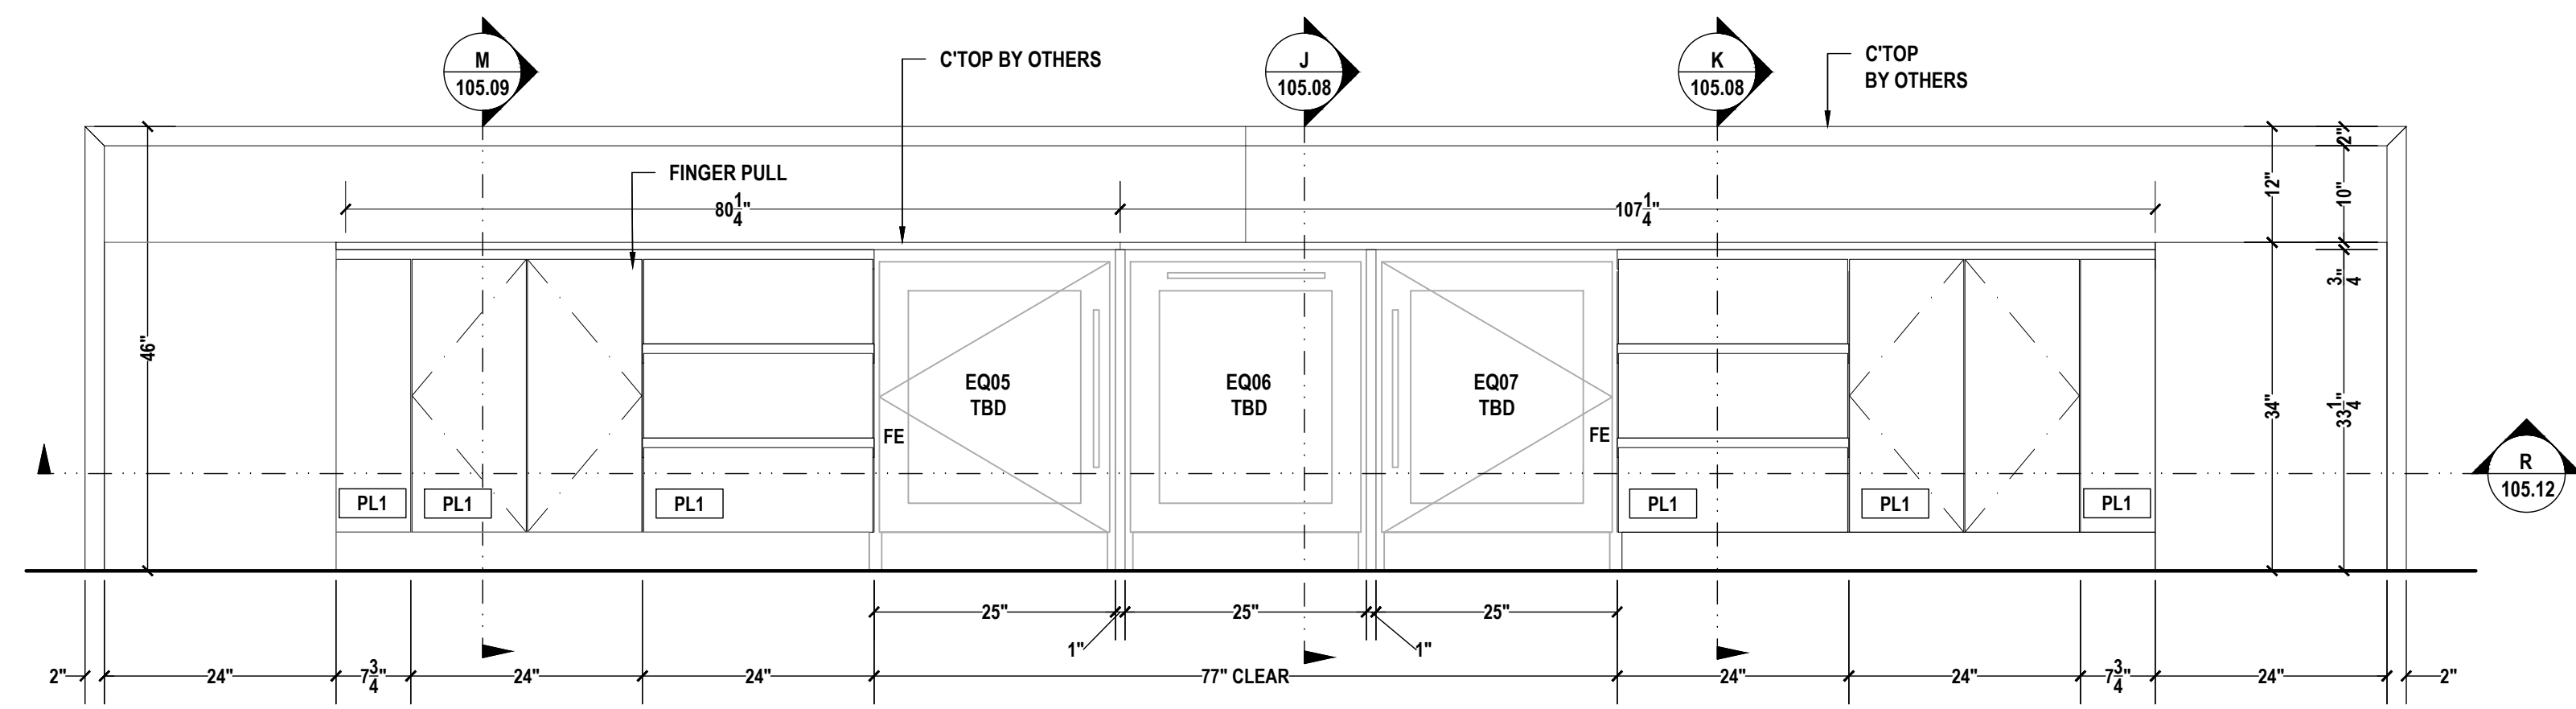

09 BREAK ROOM A204
ELEVATION
SCALE: 3/4"=1'-0" ARCH REF.: A8/A608

APPROVAL DATE	-
PLOT DATE	07/11/2024
PROJECT NUMBER	P-5567446
ROOM NAME	BREAK ROOM A204
SHEET NUMBER	105.05

PROJECT:
SAMPLE DRAWINGS

PROJECT ADDRESS:
ORANGE AVE, NASHVILLE, TN

ARCHITECT:
FREDDY C.

G.C.:
PAOLO P.

	QCP	YES <input type="checkbox"/>	NO <input type="checkbox"/>
	LEED	YES <input type="checkbox"/>	NO <input type="checkbox"/>
	FSC	YES <input type="checkbox"/>	NO <input type="checkbox"/>
	NAUF	YES <input type="checkbox"/>	NO <input type="checkbox"/>

FINISHES:


PLASTIC LAMINATE	
KEY	COLOR
PL1	CARBON, TRUMATTE, BLACK
STONE	
KEY	COLOR
ST1	CAESARSTONE 5121 LAYATILE
INTERIOR FINISHES	
KEY	COLOR
MEL1	WHITE MELAMINE

PM:	ERW
DRAWN BY:	TMS
DATE DRAWN:	02/10/2023
REVIEWED BY:	LCT (LOC)


REVISIONS:

No.	DATE	DESCRIPTIONS	BY:
△	-	-	-
△	-	-	-
△	-	-	-
△	-	-	-
△	-	-	-
△	-	-	-
△	-	-	-


APPROVAL DATE	-
PLOT DATE	07/11/2024
PROJECT NUMBER	P-5567446
ROOM NAME	BREAK ROOM A204
SHEET NUMBER	105.06

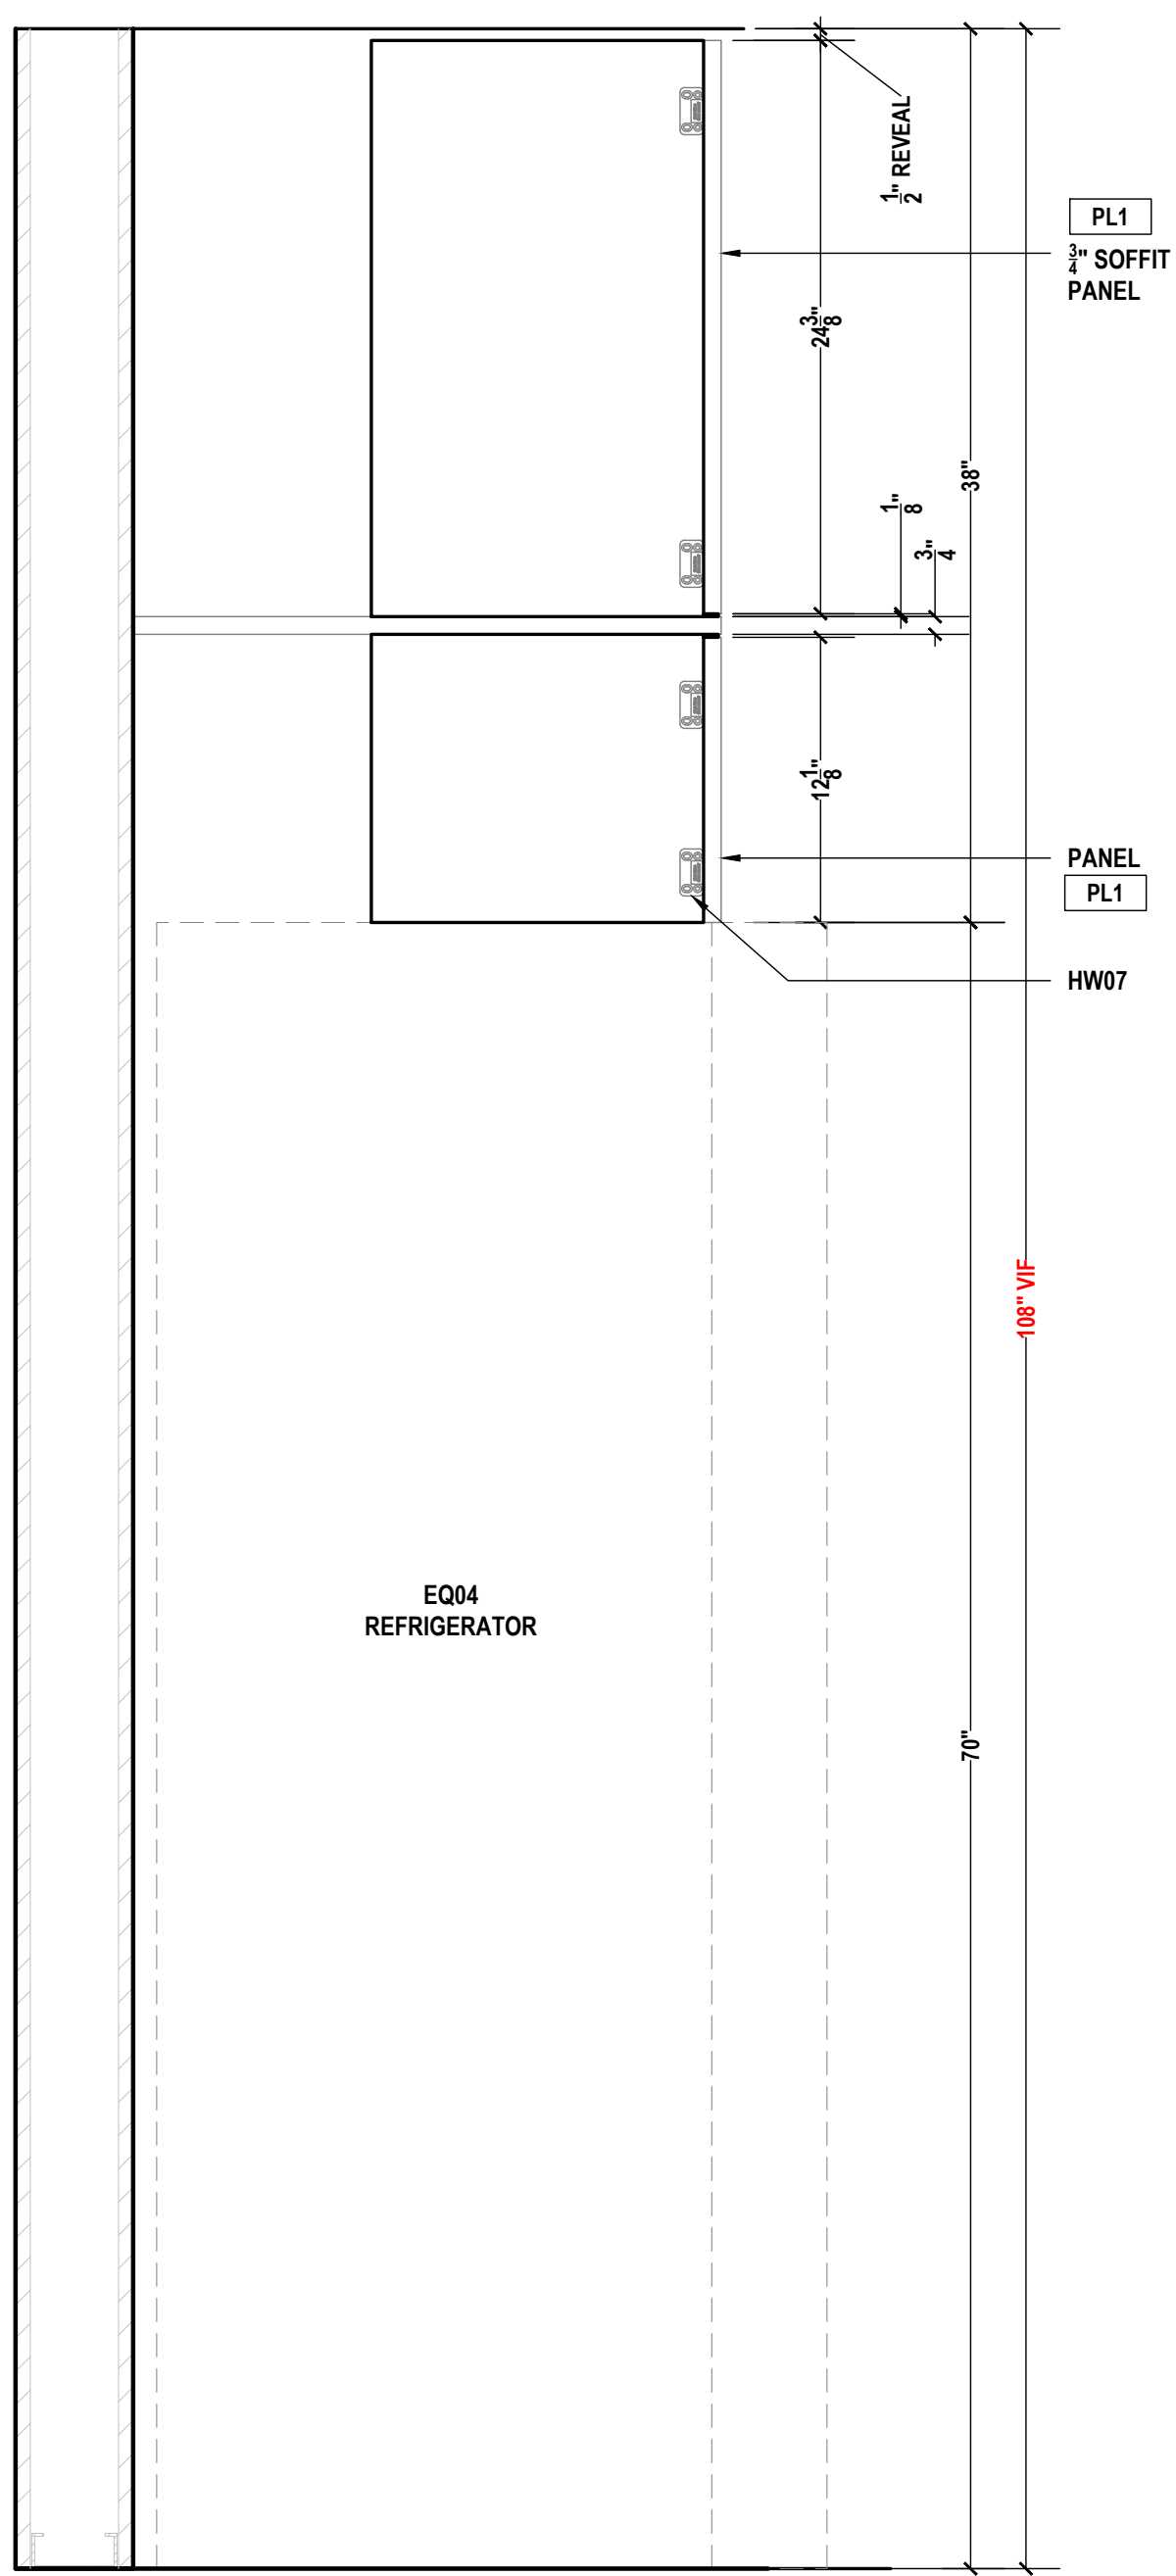

A BREAK ROOM SECTION
SCALE: 1-1/2"=1'-0" ARCH REF.: 10/A605B

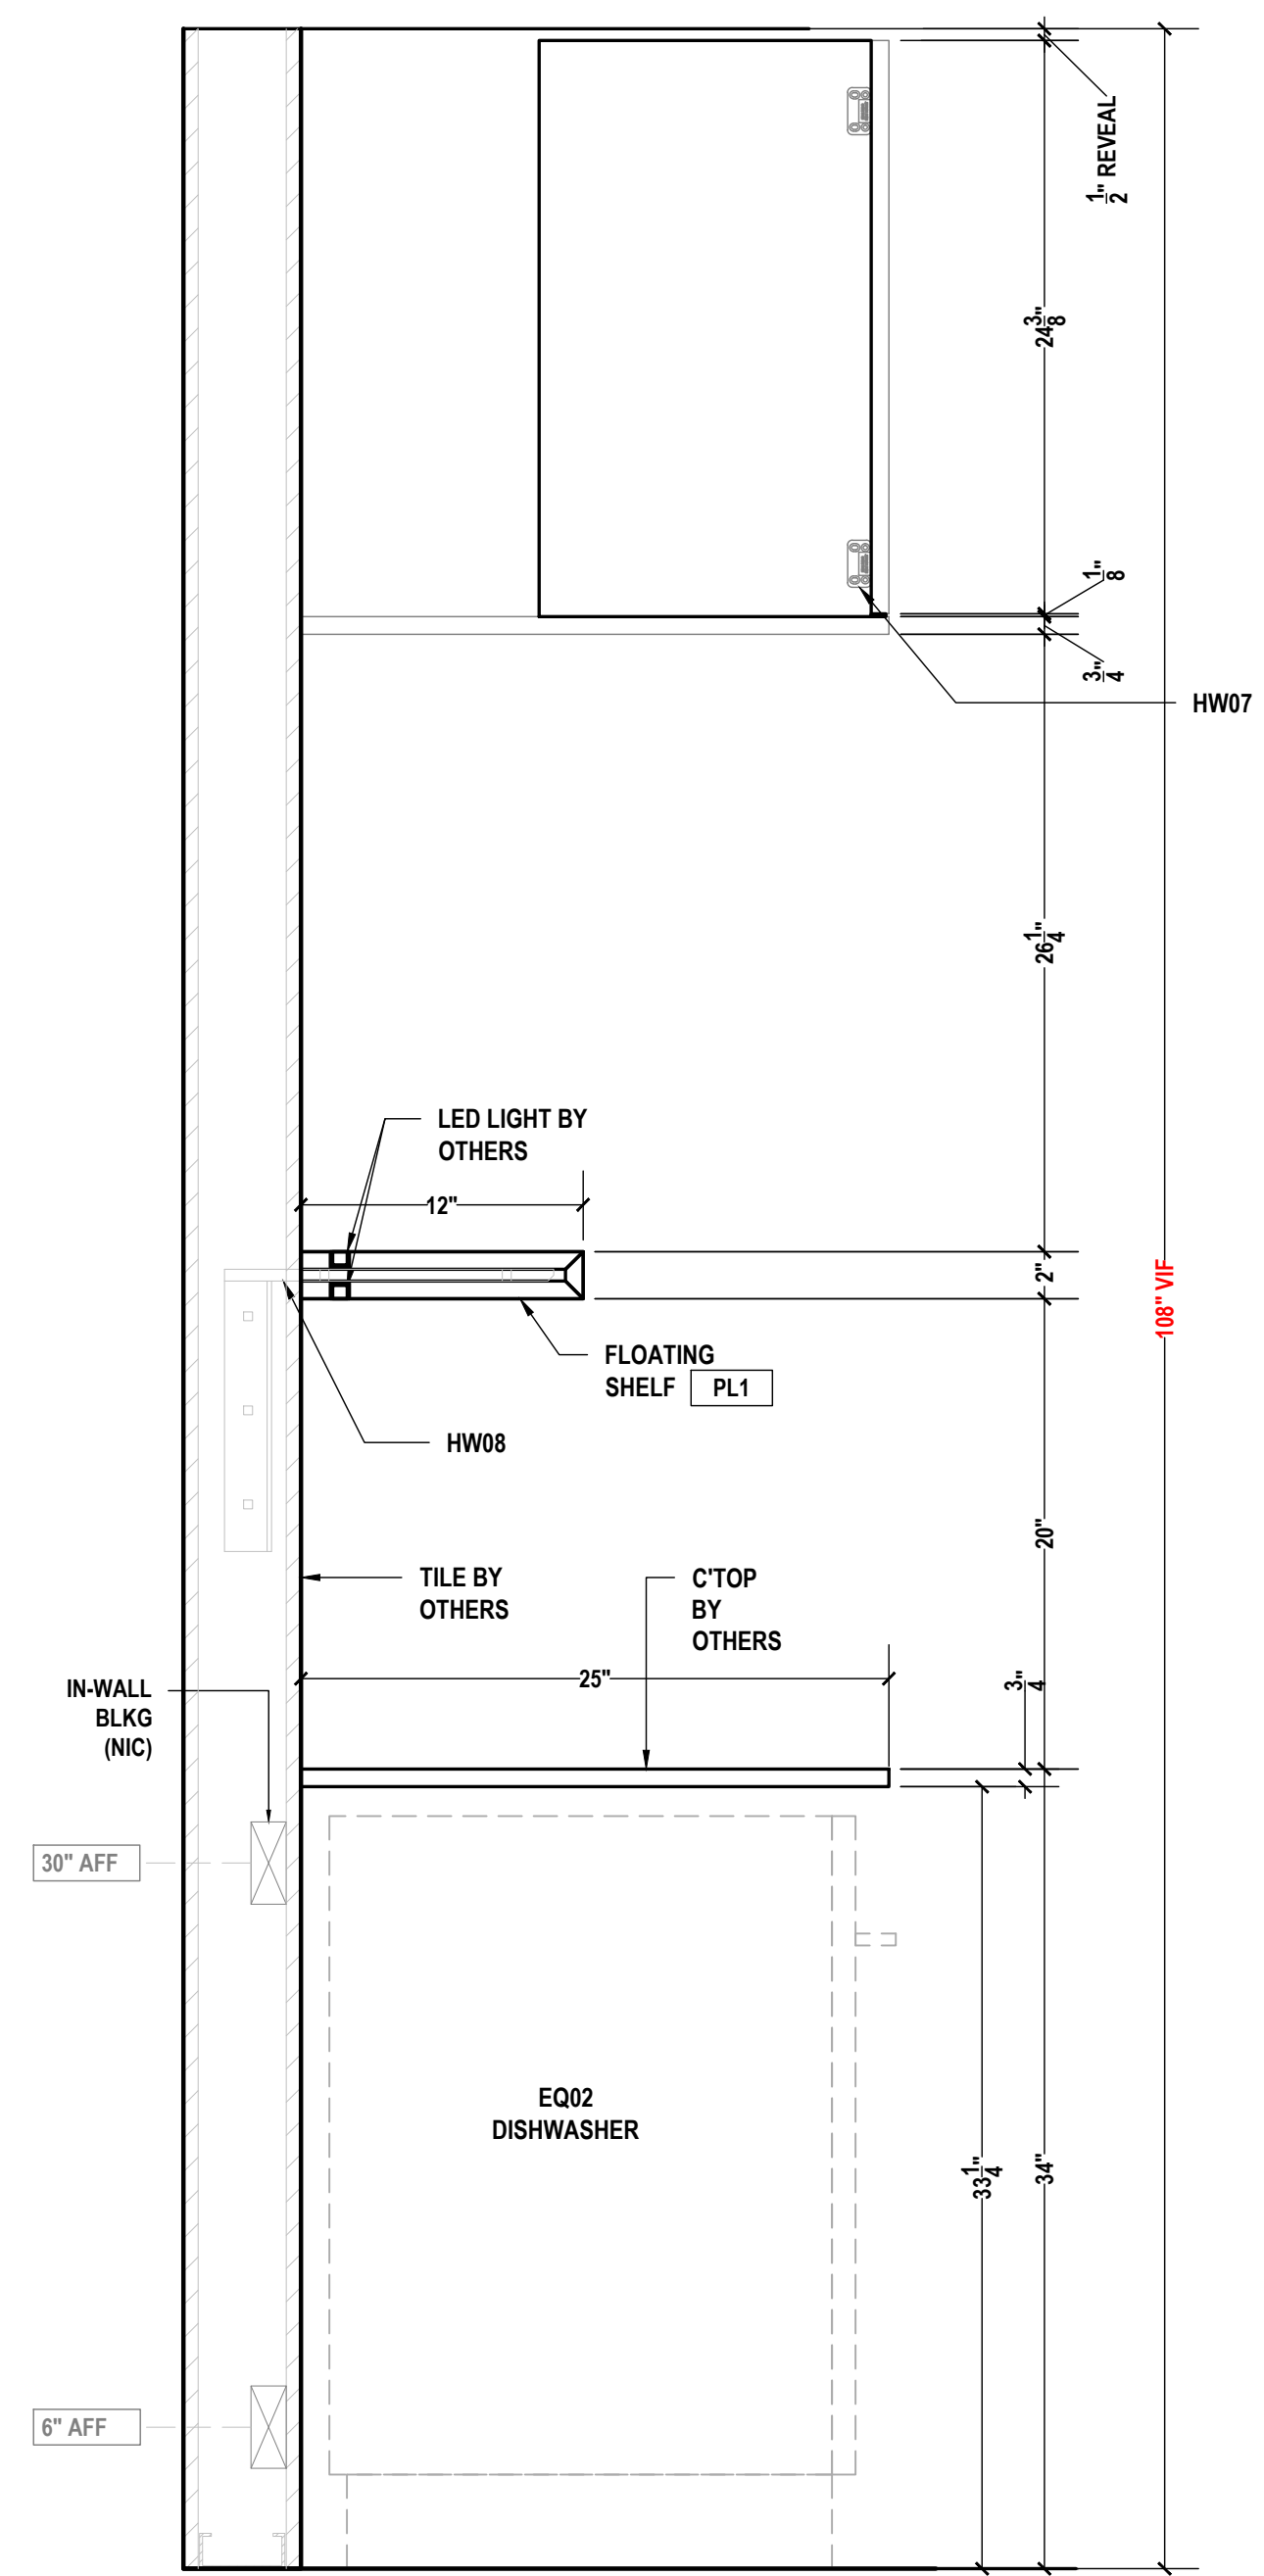

B BREAK ROOM SECTION
SCALE: 1-1/2"=1'-0" ARCH REF.: 11/A605B

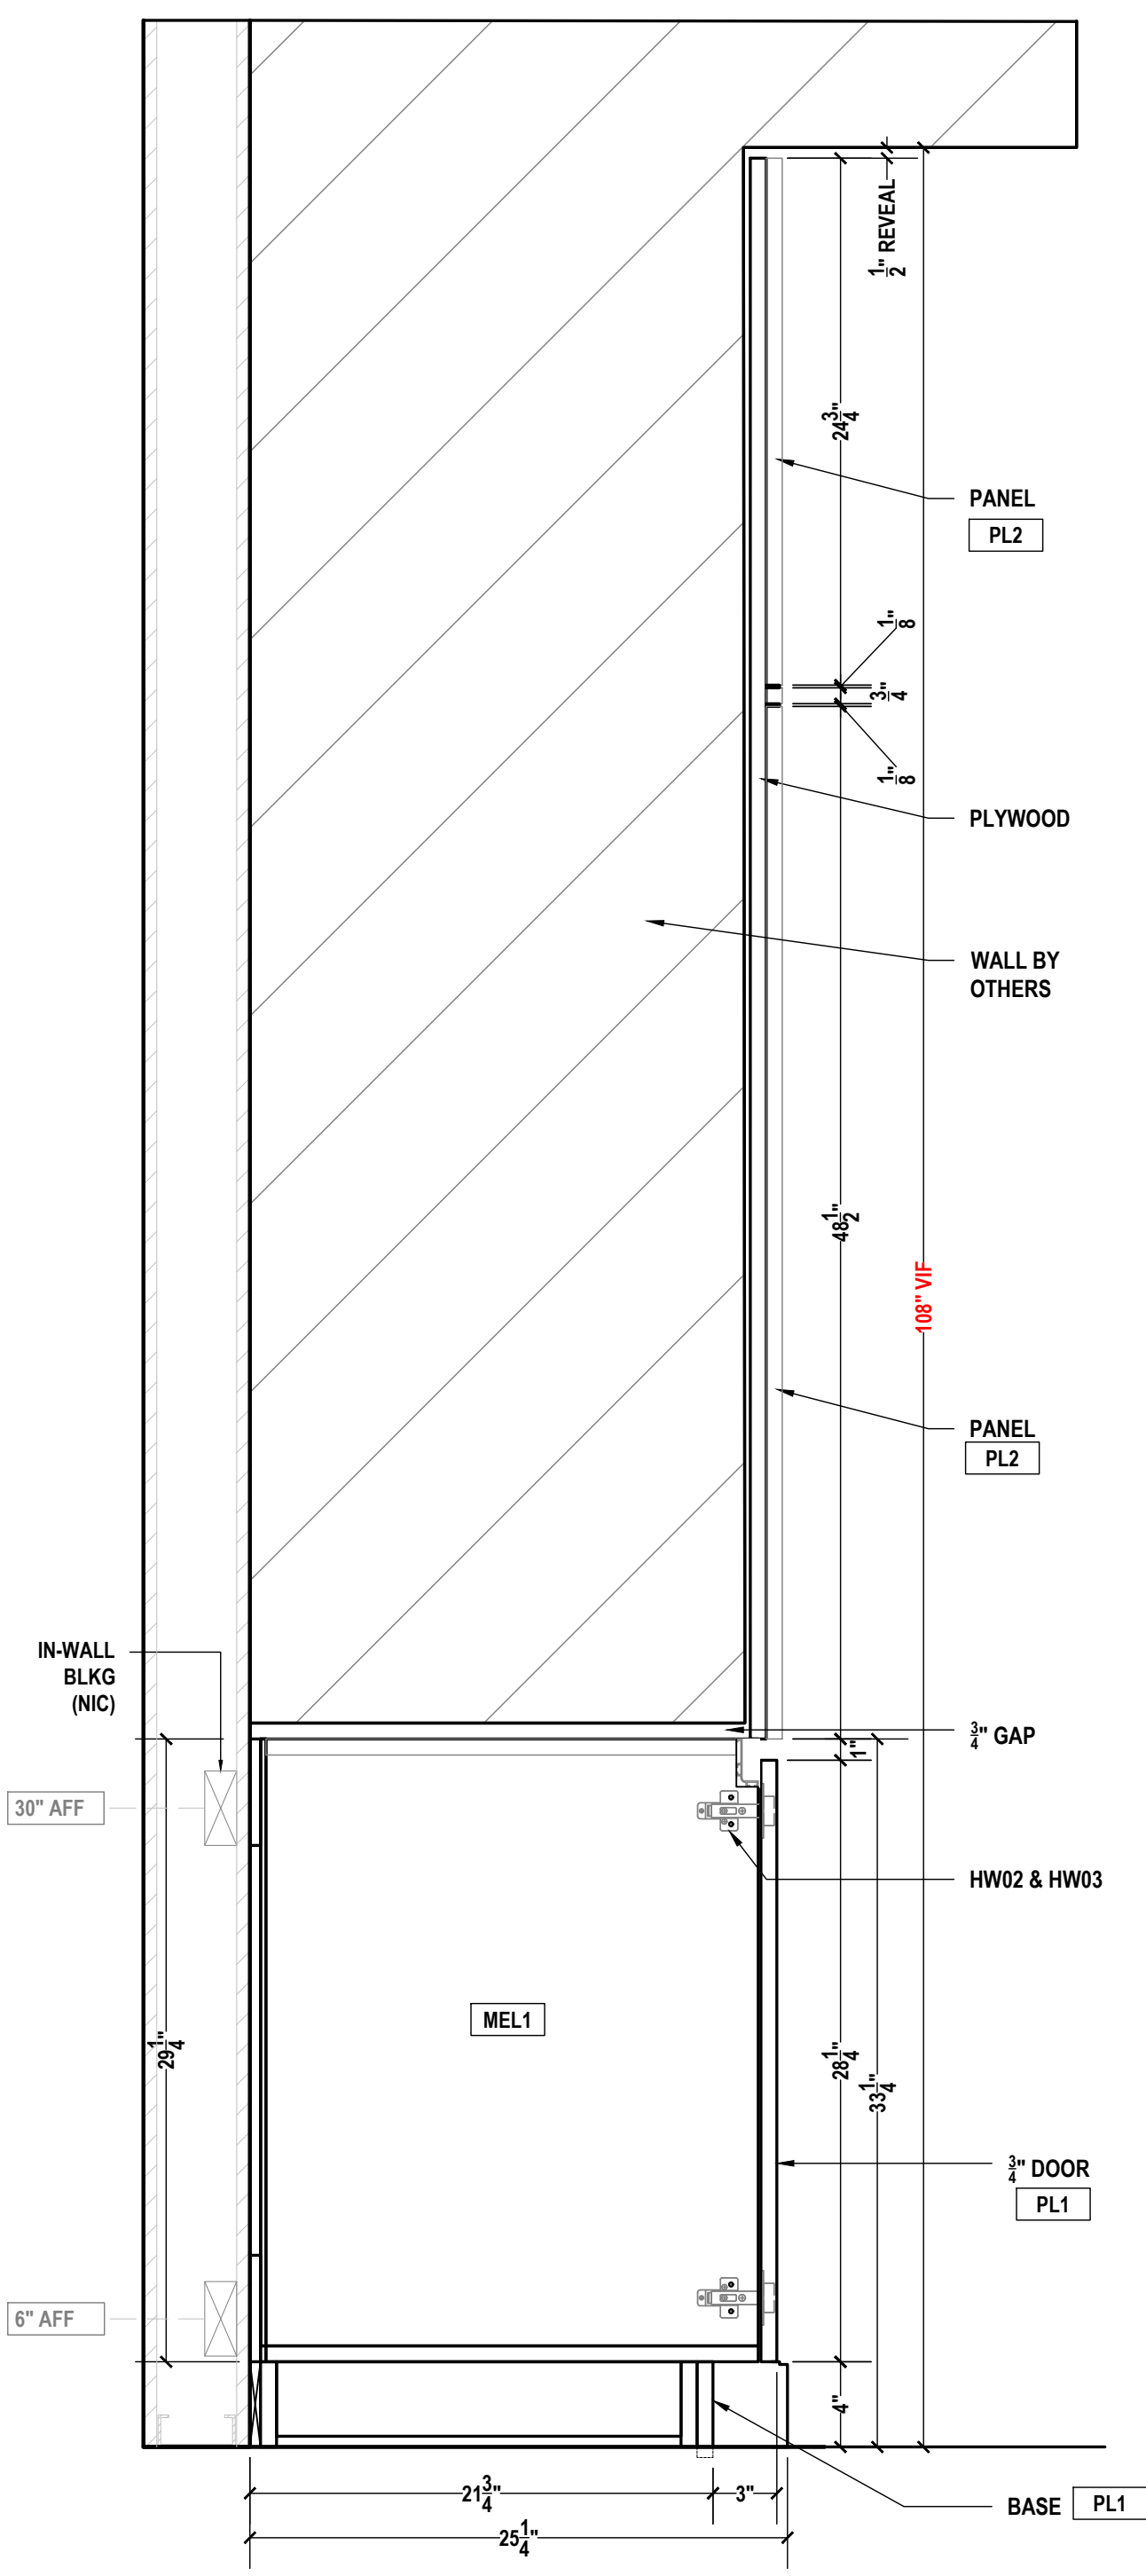

C BREAK ROOM SECTION
SCALE: 1-1/2"=1'-0" ARCH REF.: 12/A605B

PROJECT:
SAMPLE DRAWINGS

PROJECT ADDRESS:
ORANGE AVE, NASHVILLE, TN

ARCHITECT:
FREDDY C.

G.C.:
PAOLO P.

	QCP	YES <input type="checkbox"/>	NO <input type="checkbox"/>
	LEED	YES <input type="checkbox"/>	NO <input type="checkbox"/>
	FSC	YES <input type="checkbox"/>	NO <input type="checkbox"/>
	NAUF	YES <input type="checkbox"/>	NO <input type="checkbox"/>

FINISHES:


KEY	STONE
ST1	COLOR CAESARSTONE 5121 LAYATILE
KEY	INTERIOR FINISHES
MEL1	COLOR WHITE MELAMINE

PM:	ERW
DRAWN BY:	TMS
DATE DRAWN:	02/10/2023
REVIEWED BY:	LCT (LOC)


REVISIONS:

No.	DATE	DESCRIPTIONS	BY:
△	-	-	-
△	-	-	-
△	-	-	-
△	-	-	-
△	-	-	-
△	-	-	-
△	-	-	-
△	-	-	-


APPROVAL DATE	-
PLOT DATE	07/11/2024
PROJECT NUMBER	P-5567446
ROOM NAME	BREAK ROOM A204
SHEET NUMBER	105.07

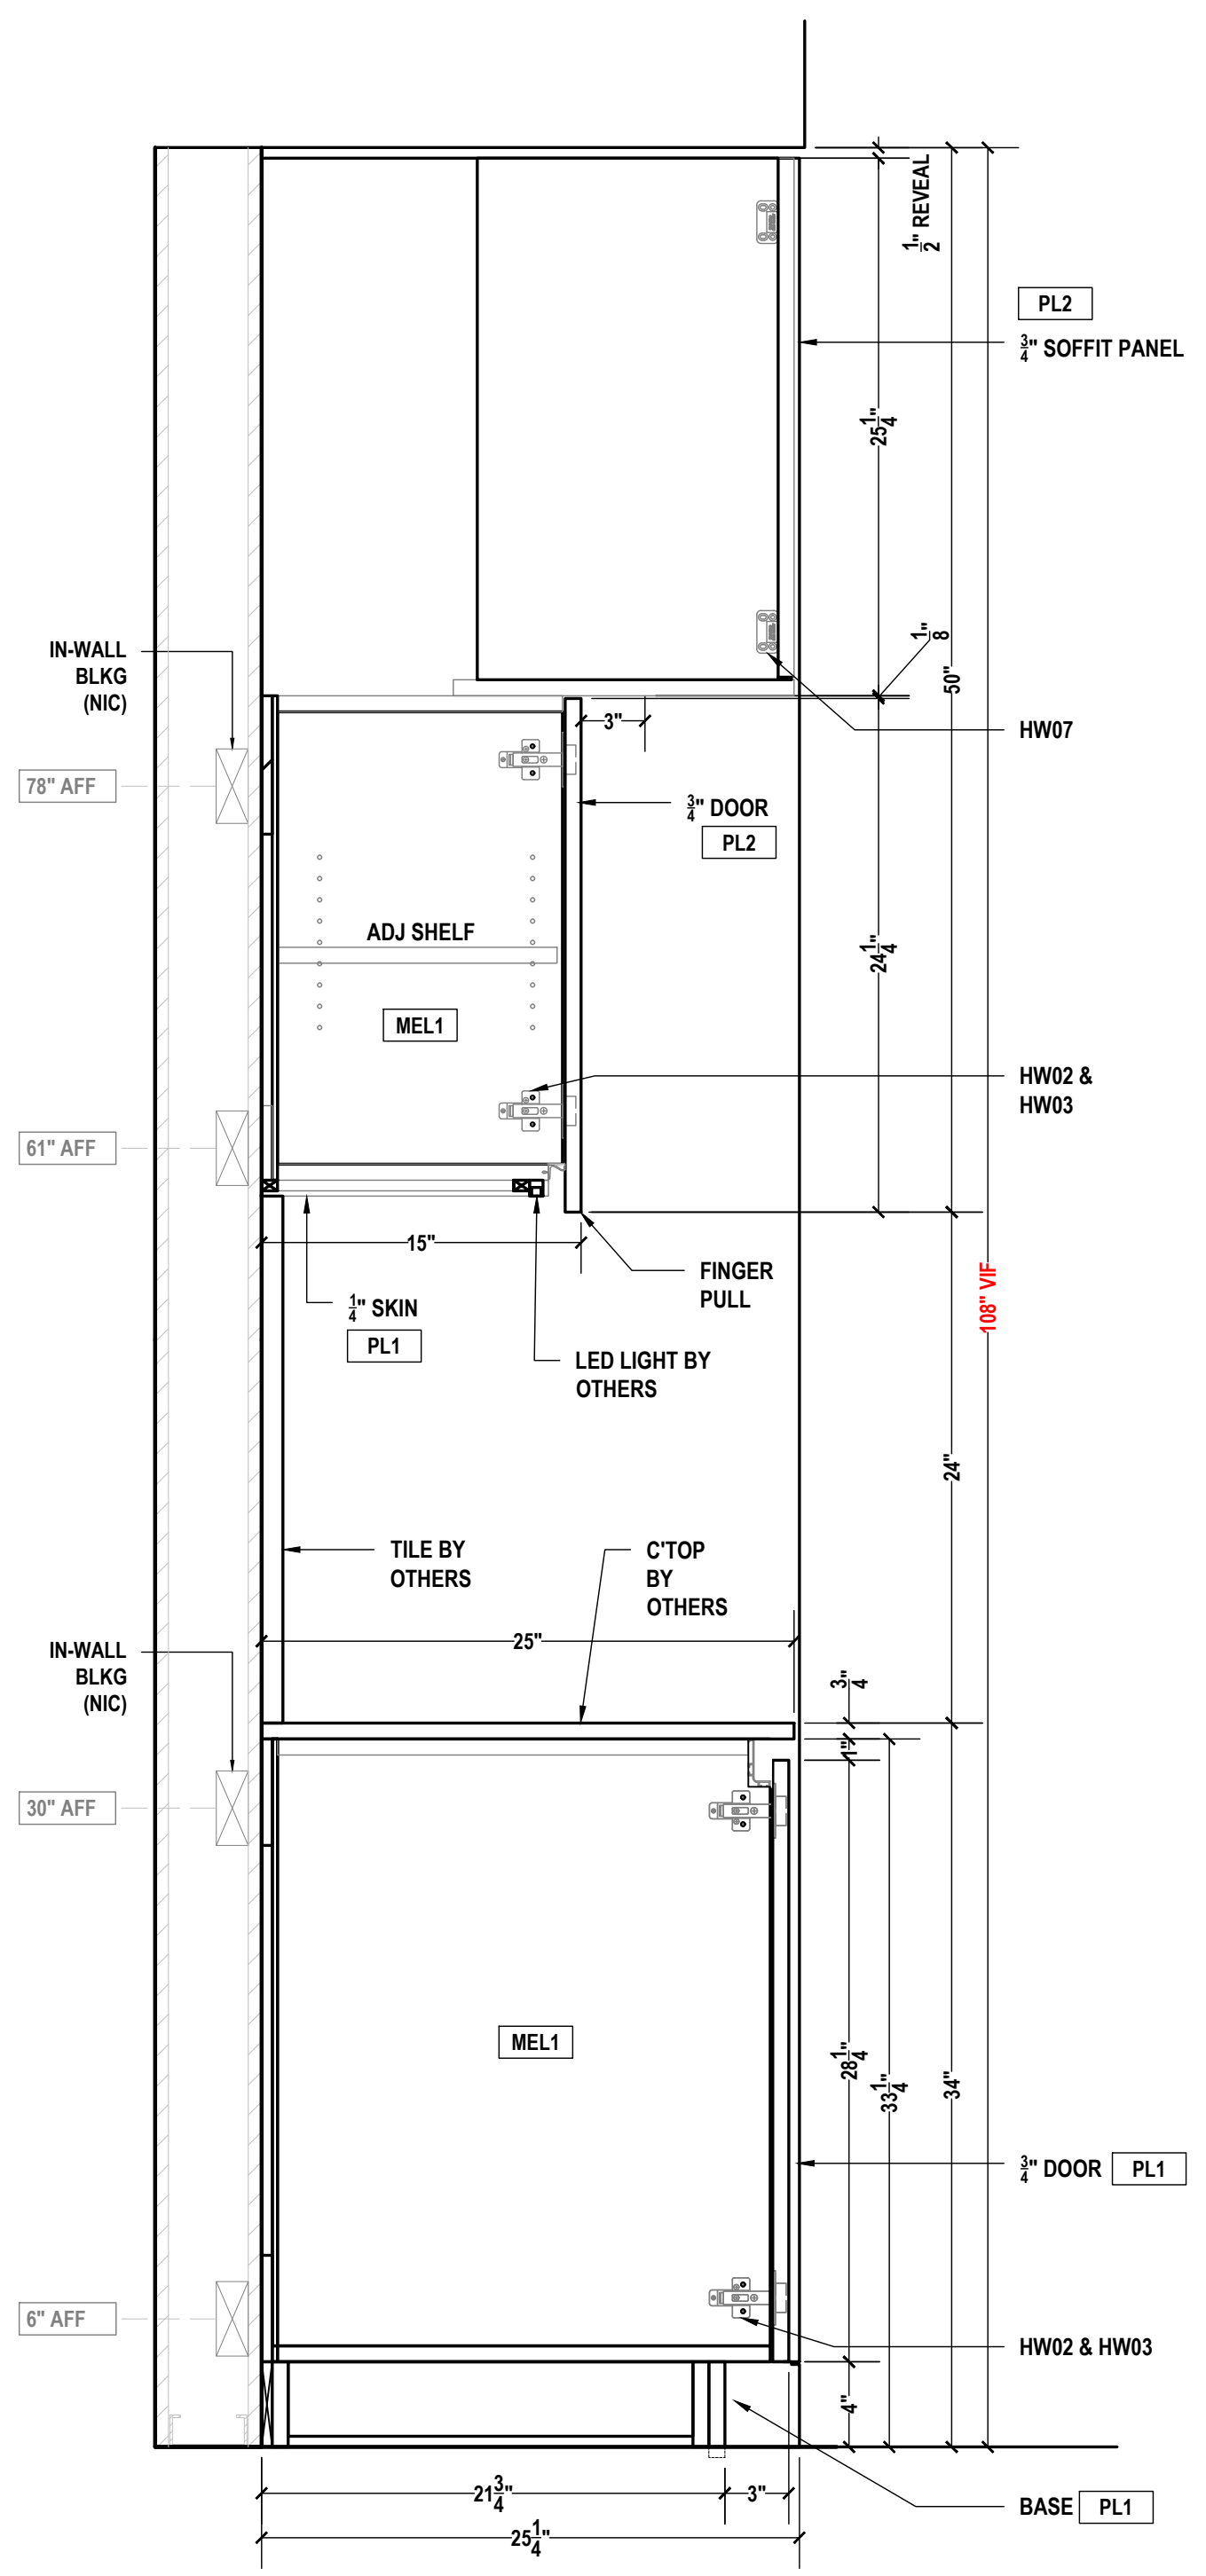


D BREAK ROOM SECTION
SCALE: 1-1/2"=1'-0" ARCH REF.: 13/A605B

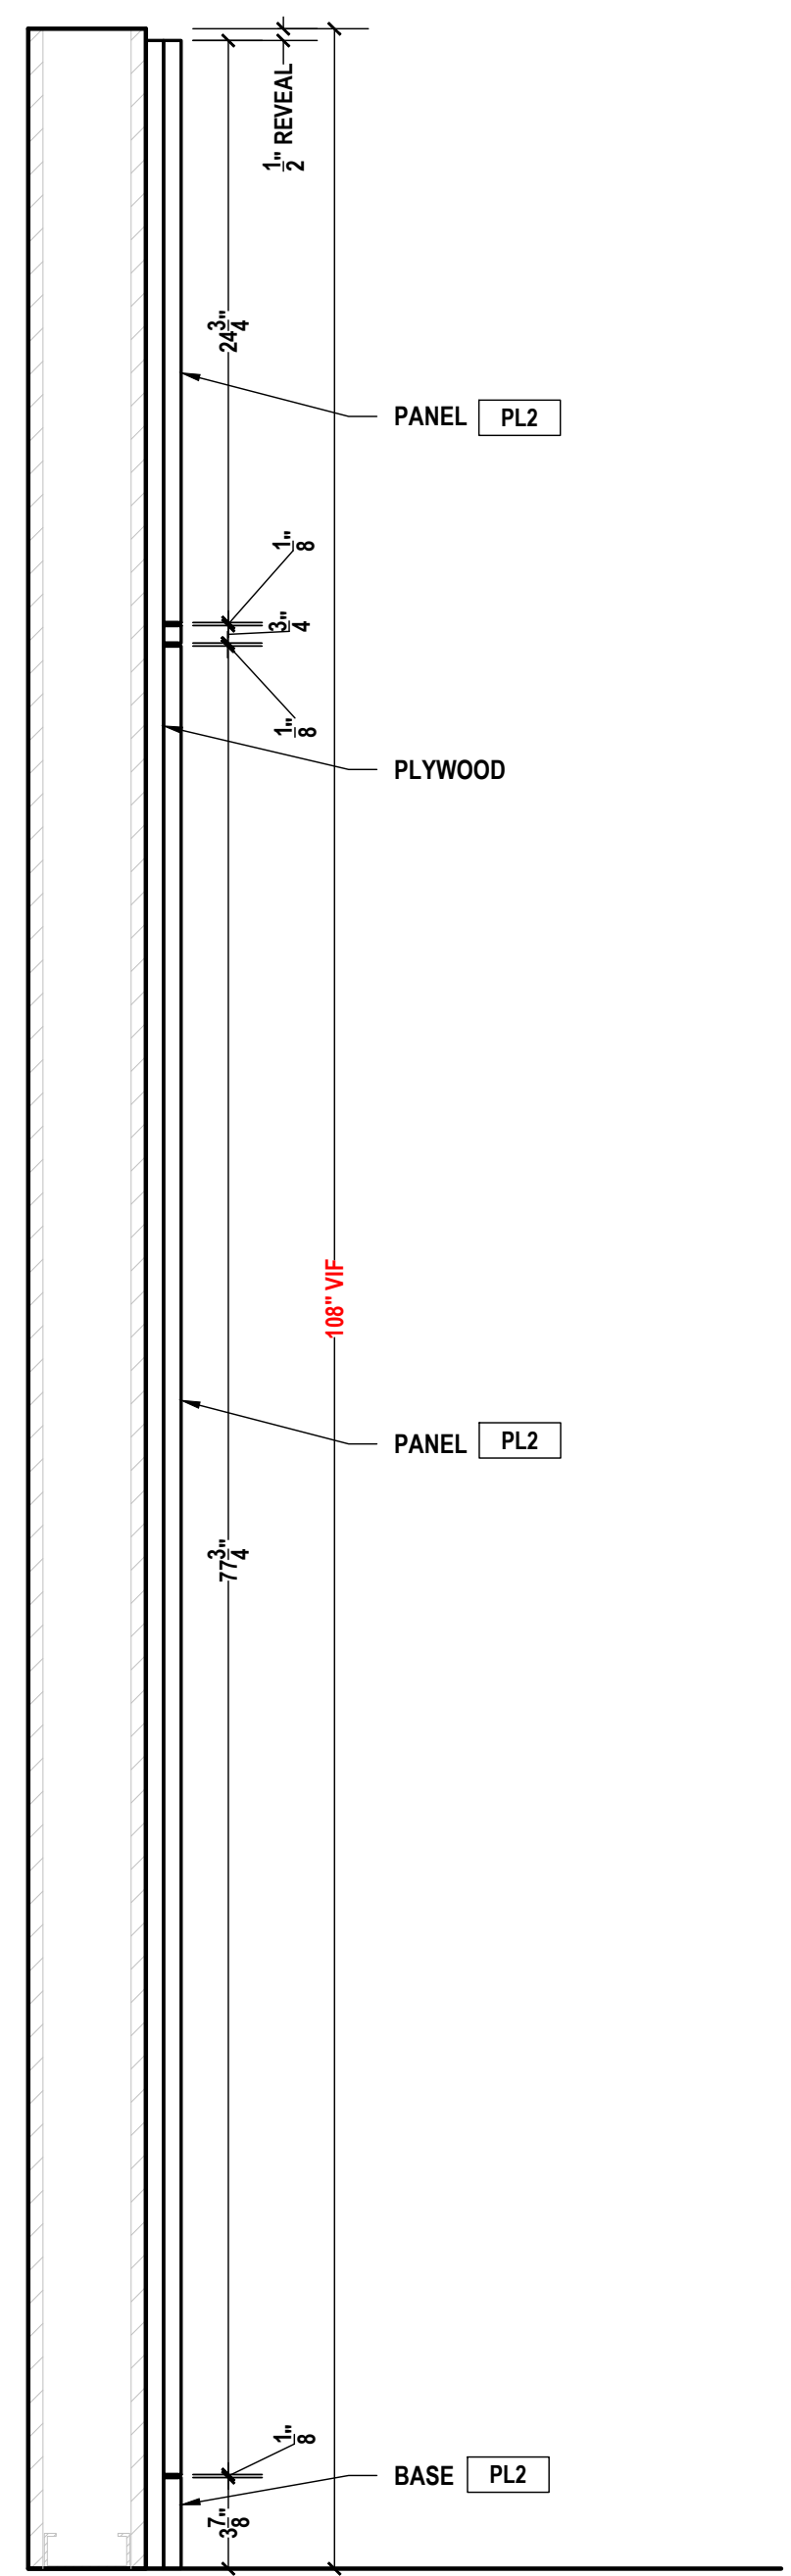

E BREAK ROOM SECTION
SCALE: 1-1/2"=1'-0" ARCH REF.: 14/A605B

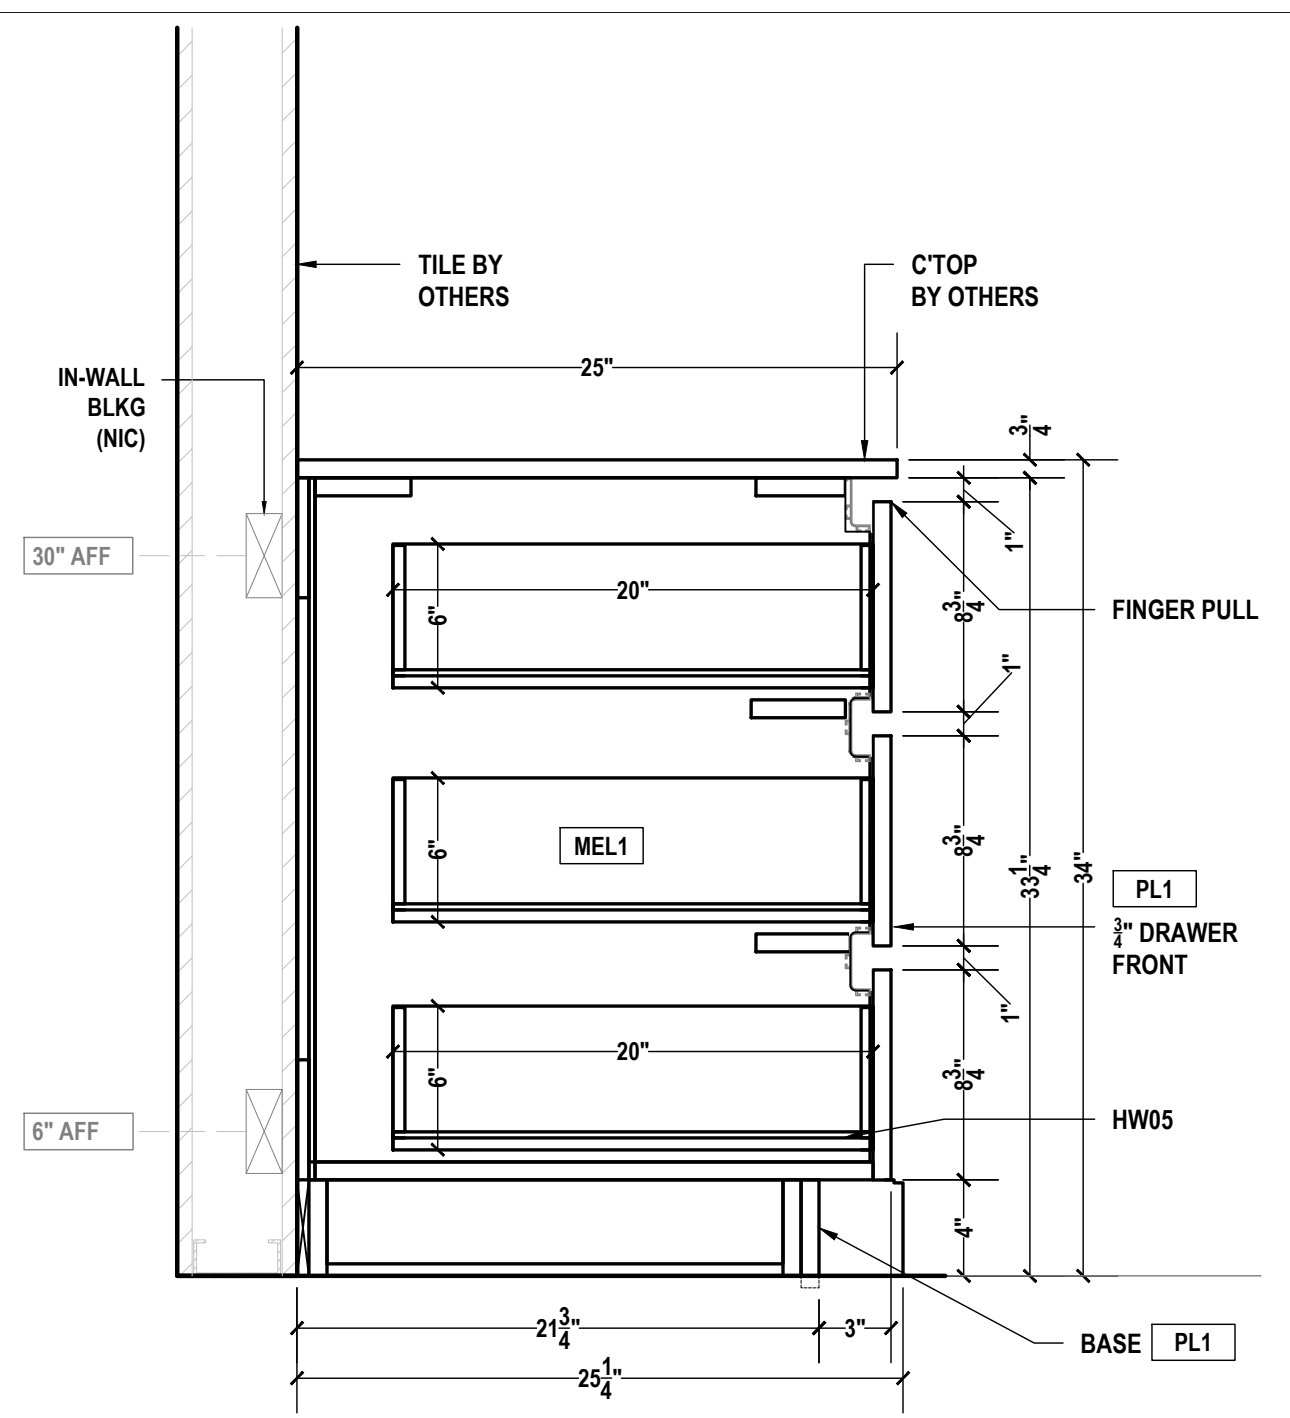

G BREAK ROOM SECTION
SCALE: 1-1/2"=1'-0" ARCH REF.: 16/A605B

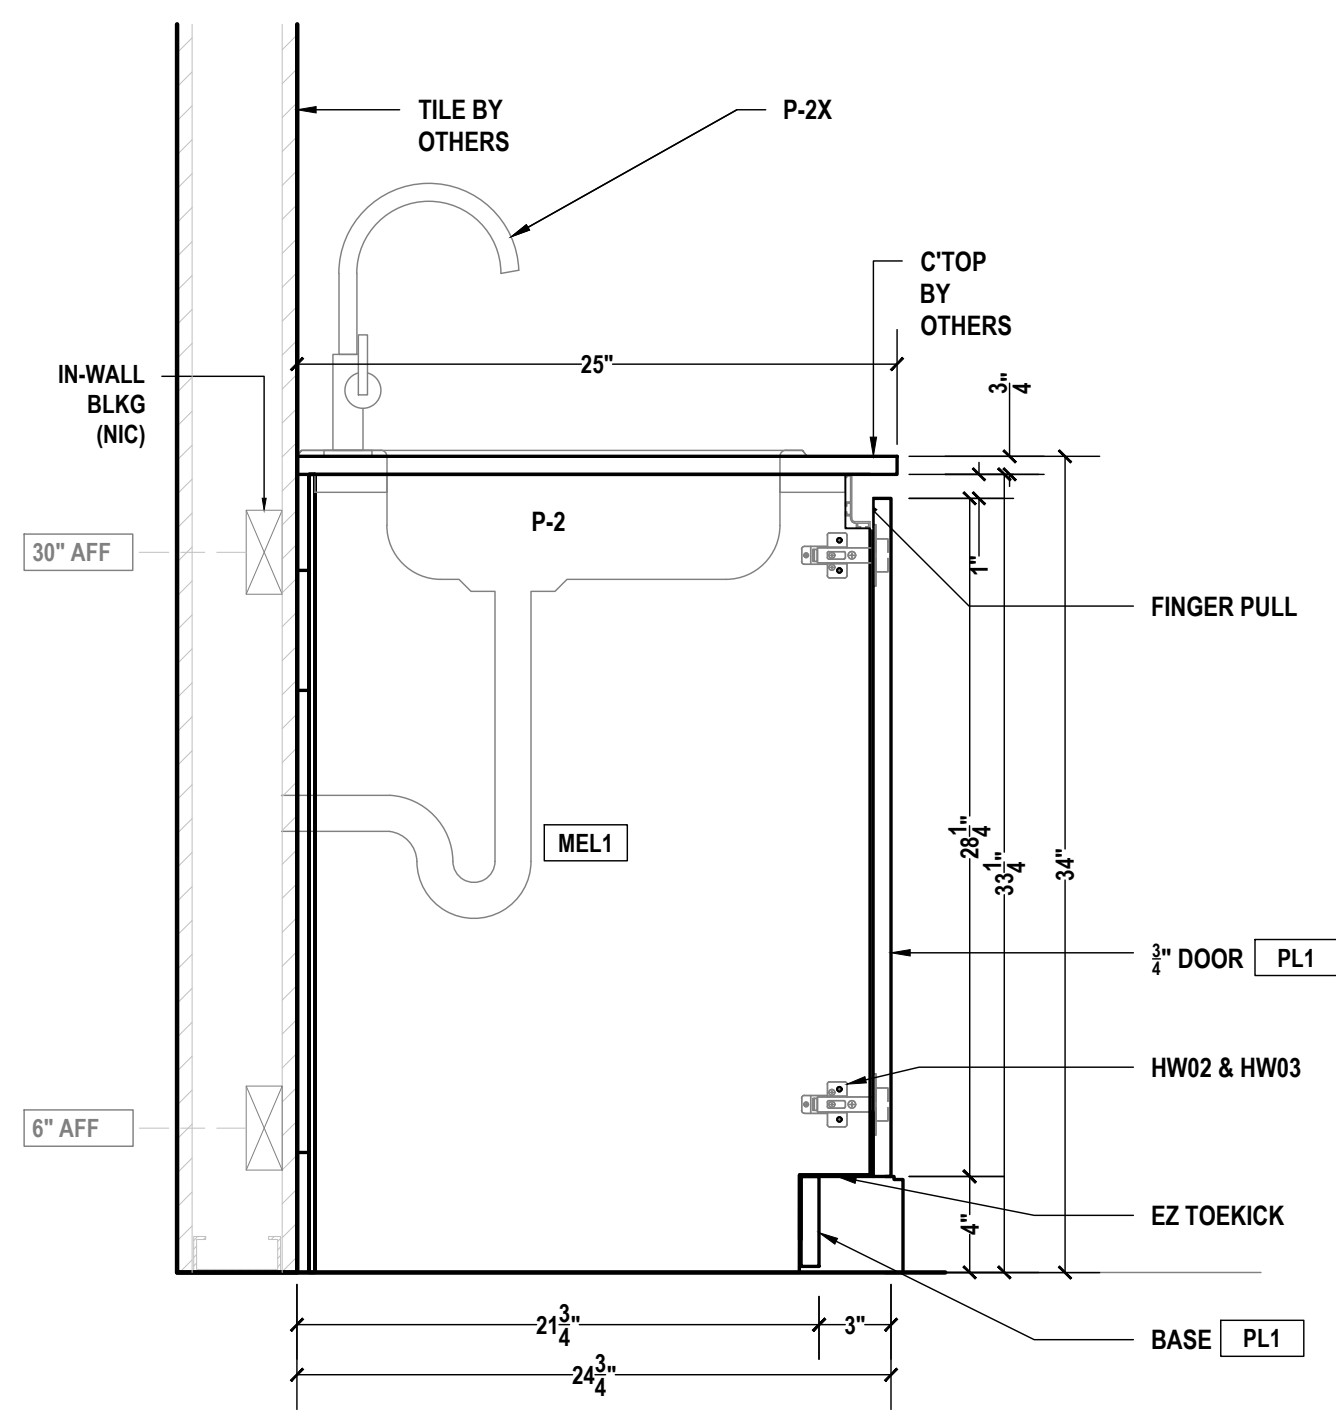

F BREAK ROOM SECTION
SCALE: 1-1/2"=1'-0" ARCH REF.: 15/A605B

PROJECT:
SAMPLE DRAWINGS

PROJECT ADDRESS:
ORANGE AVE, NASHVILLE, TN

ARCHITECT:
FREDDY C.

G.C.:
PAOLO P.

	QCP	YES <input checked="" type="checkbox"/>	NO <input type="checkbox"/>
	LEED	YES <input type="checkbox"/>	NO <input checked="" type="checkbox"/>
	FSC	YES <input type="checkbox"/>	NO <input checked="" type="checkbox"/>
	NAUF	YES <input type="checkbox"/>	NO <input checked="" type="checkbox"/>

FINISHES:


PLASTIC LAMINATE	
KEY	COLOR
PL1	CARBON, TRUMATTE, BLACK
STONE	
KEY	COLOR
ST1	CAESARSTONE 5121 LAYATILE
INTERIOR FINISHES	
KEY	COLOR
MEL1	WHITE MELAMINE

PM:	ERW
DRAWN BY:	TMS
DATE DRAWN:	02/10/2023
REVIEWED BY:	LCT (LOC)


REVISIONS:

No.	DATE	DESCRIPTIONS	BY:
△	-	-	-
△	-	-	-
△	-	-	-
△	-	-	-
△	-	-	-
△	-	-	-
△	-	-	-
△	-	#	-


APPROVAL DATE	-
PLOT DATE	07/11/2024
PROJECT NUMBER	P-5567446
ROOM NAME	BREAK ROOM A204
SHEET NUMBER	105.08

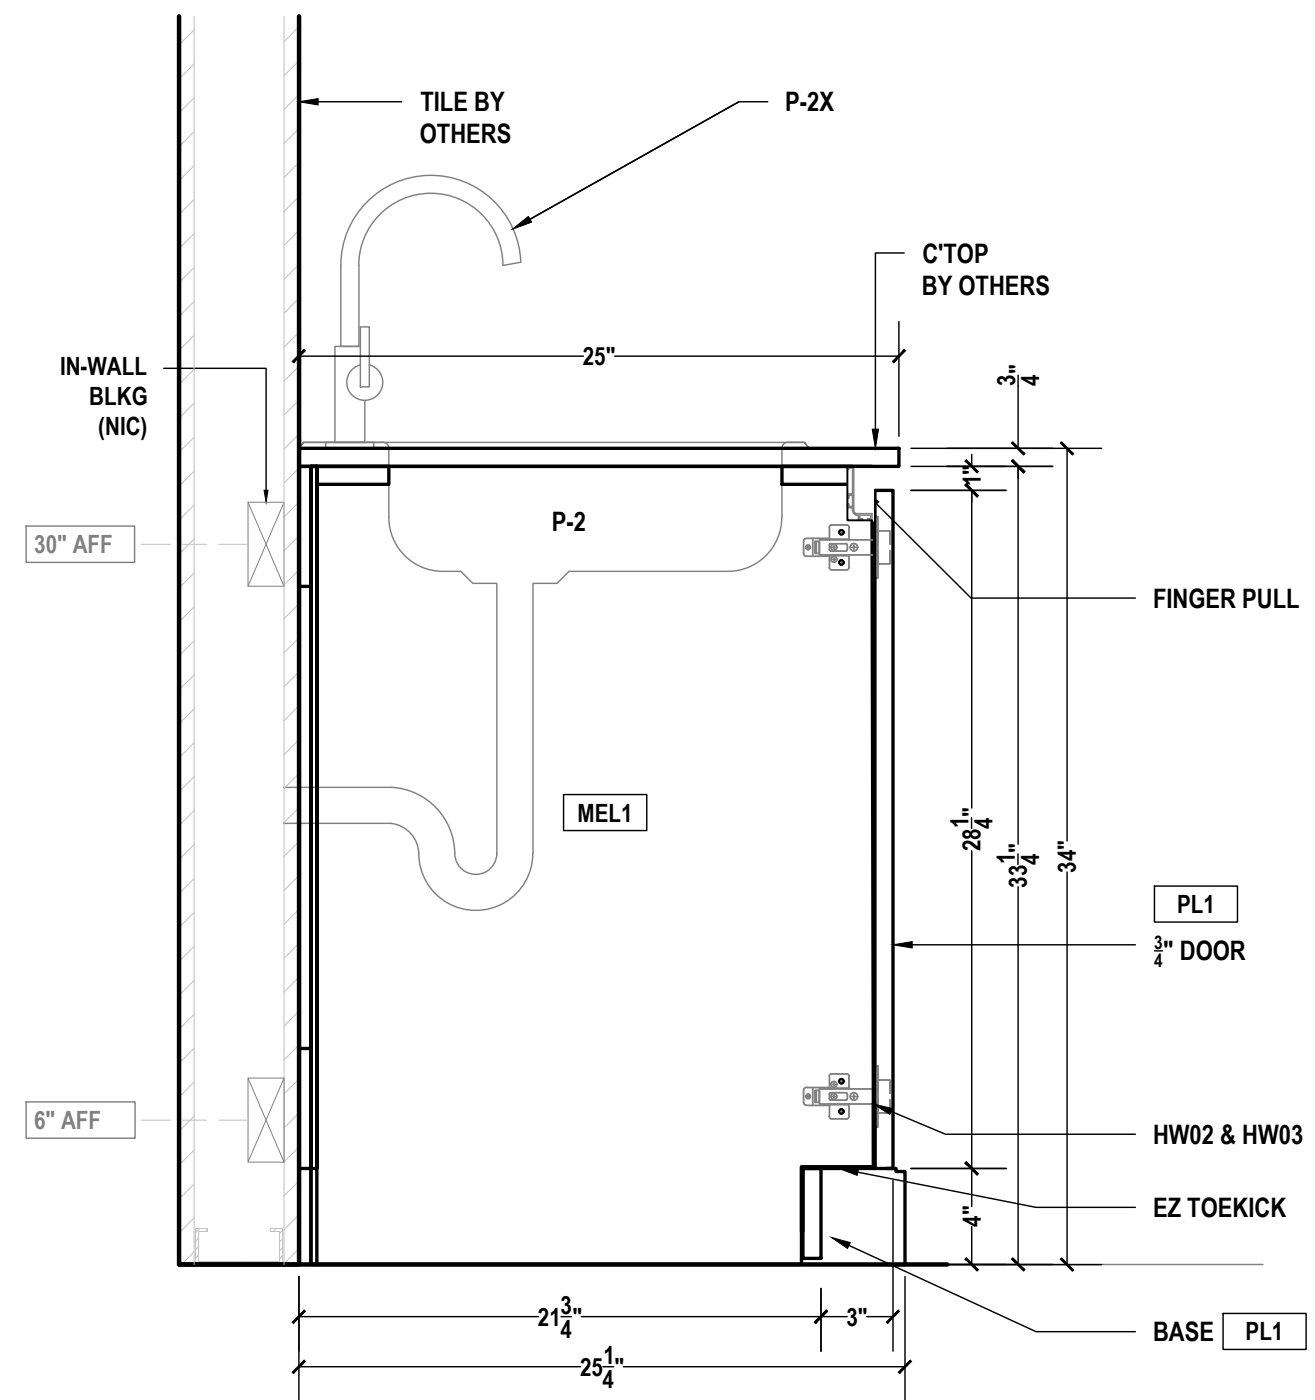


H BREAK ROOM SECTION
SCALE: 1-1/2"=1'-0" ARCH REF.: 17/A605B

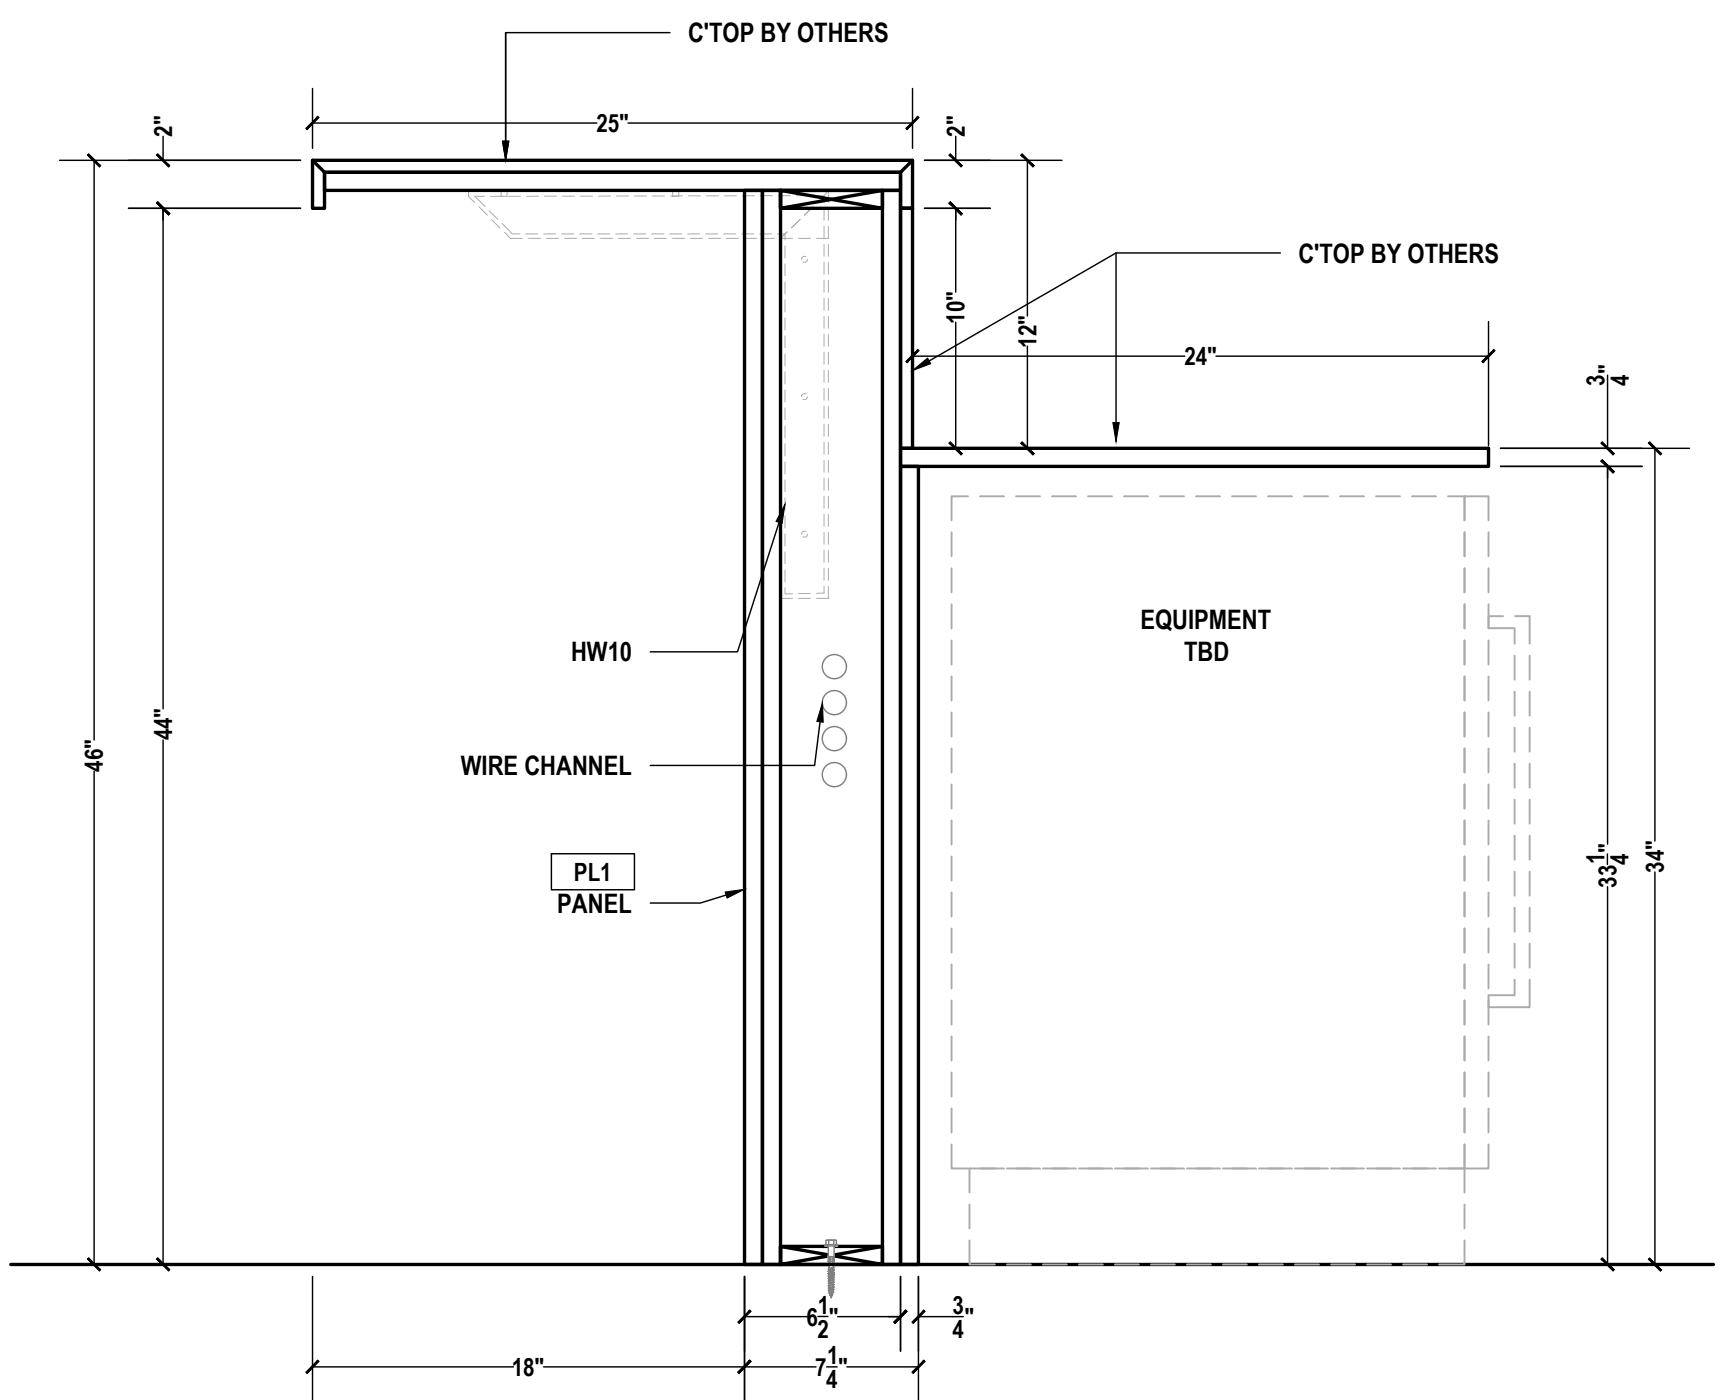

J BREAK ROOM SECTION
SCALE: 1-1/2"=1'-0" ARCH REF.: 19/A605B

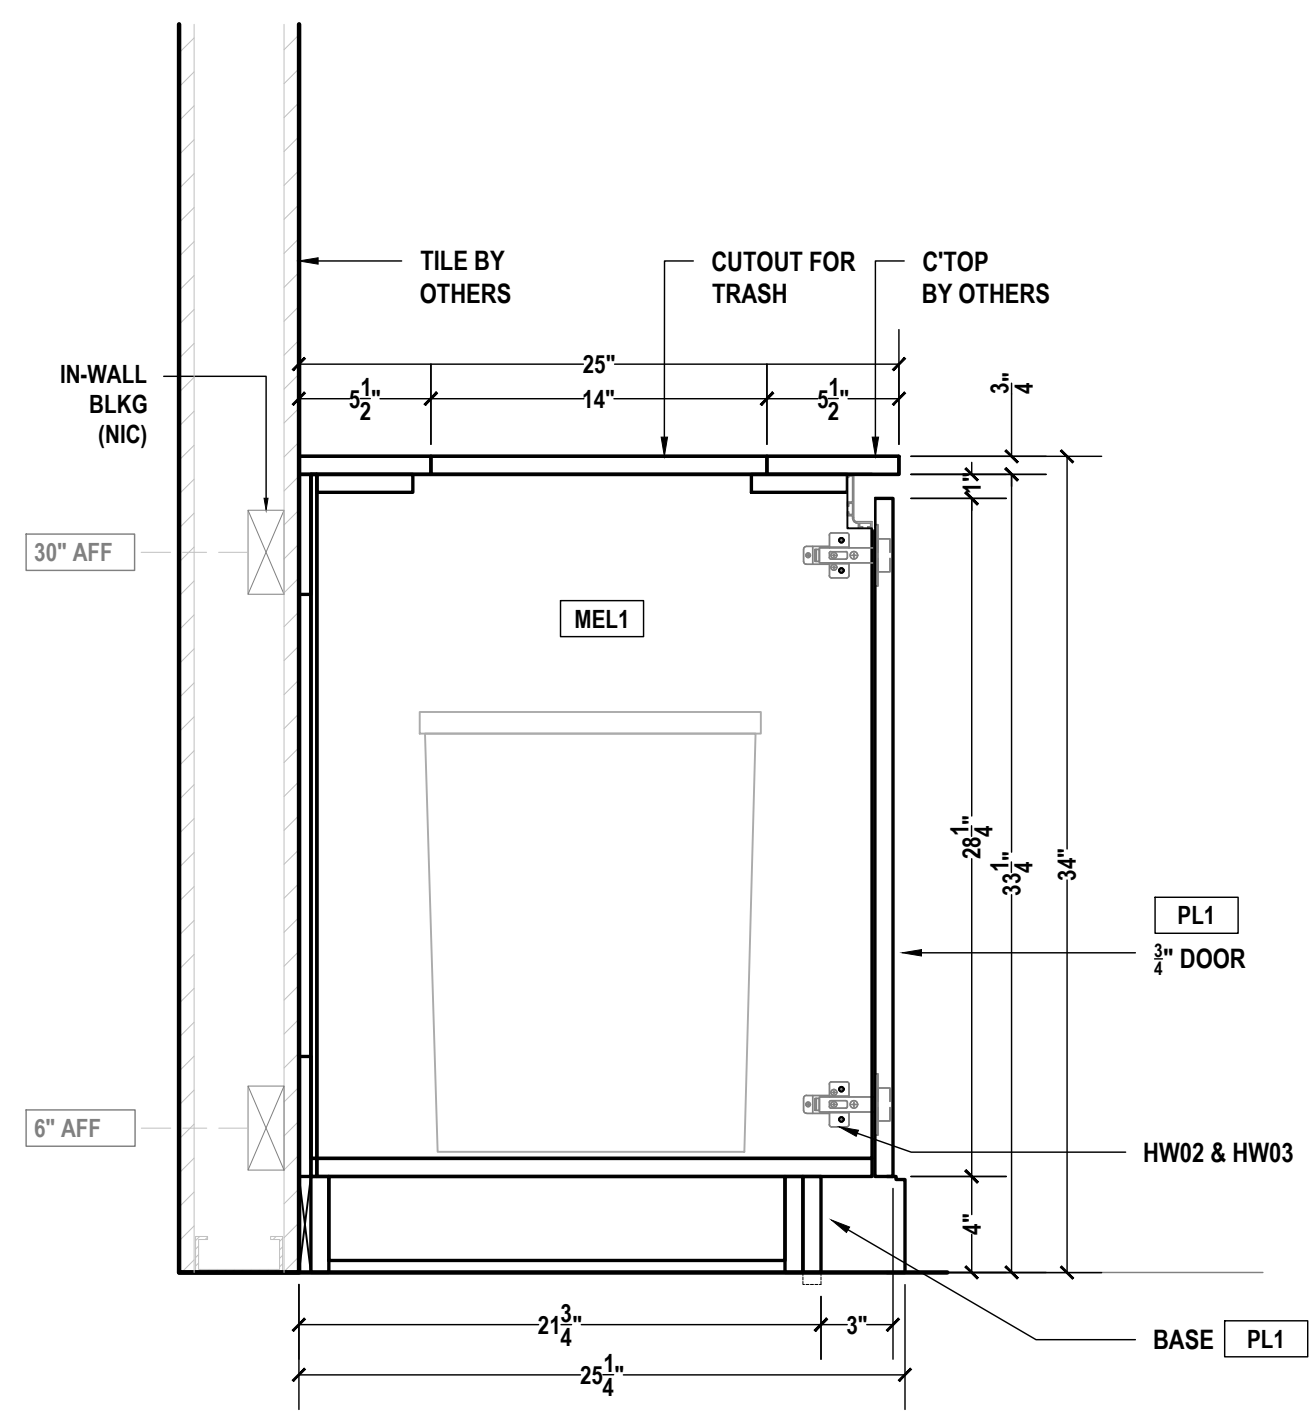

I BREAK ROOM SECTION
SCALE: 1-1/2"=1'-0" ARCH REF.: 18/A605B

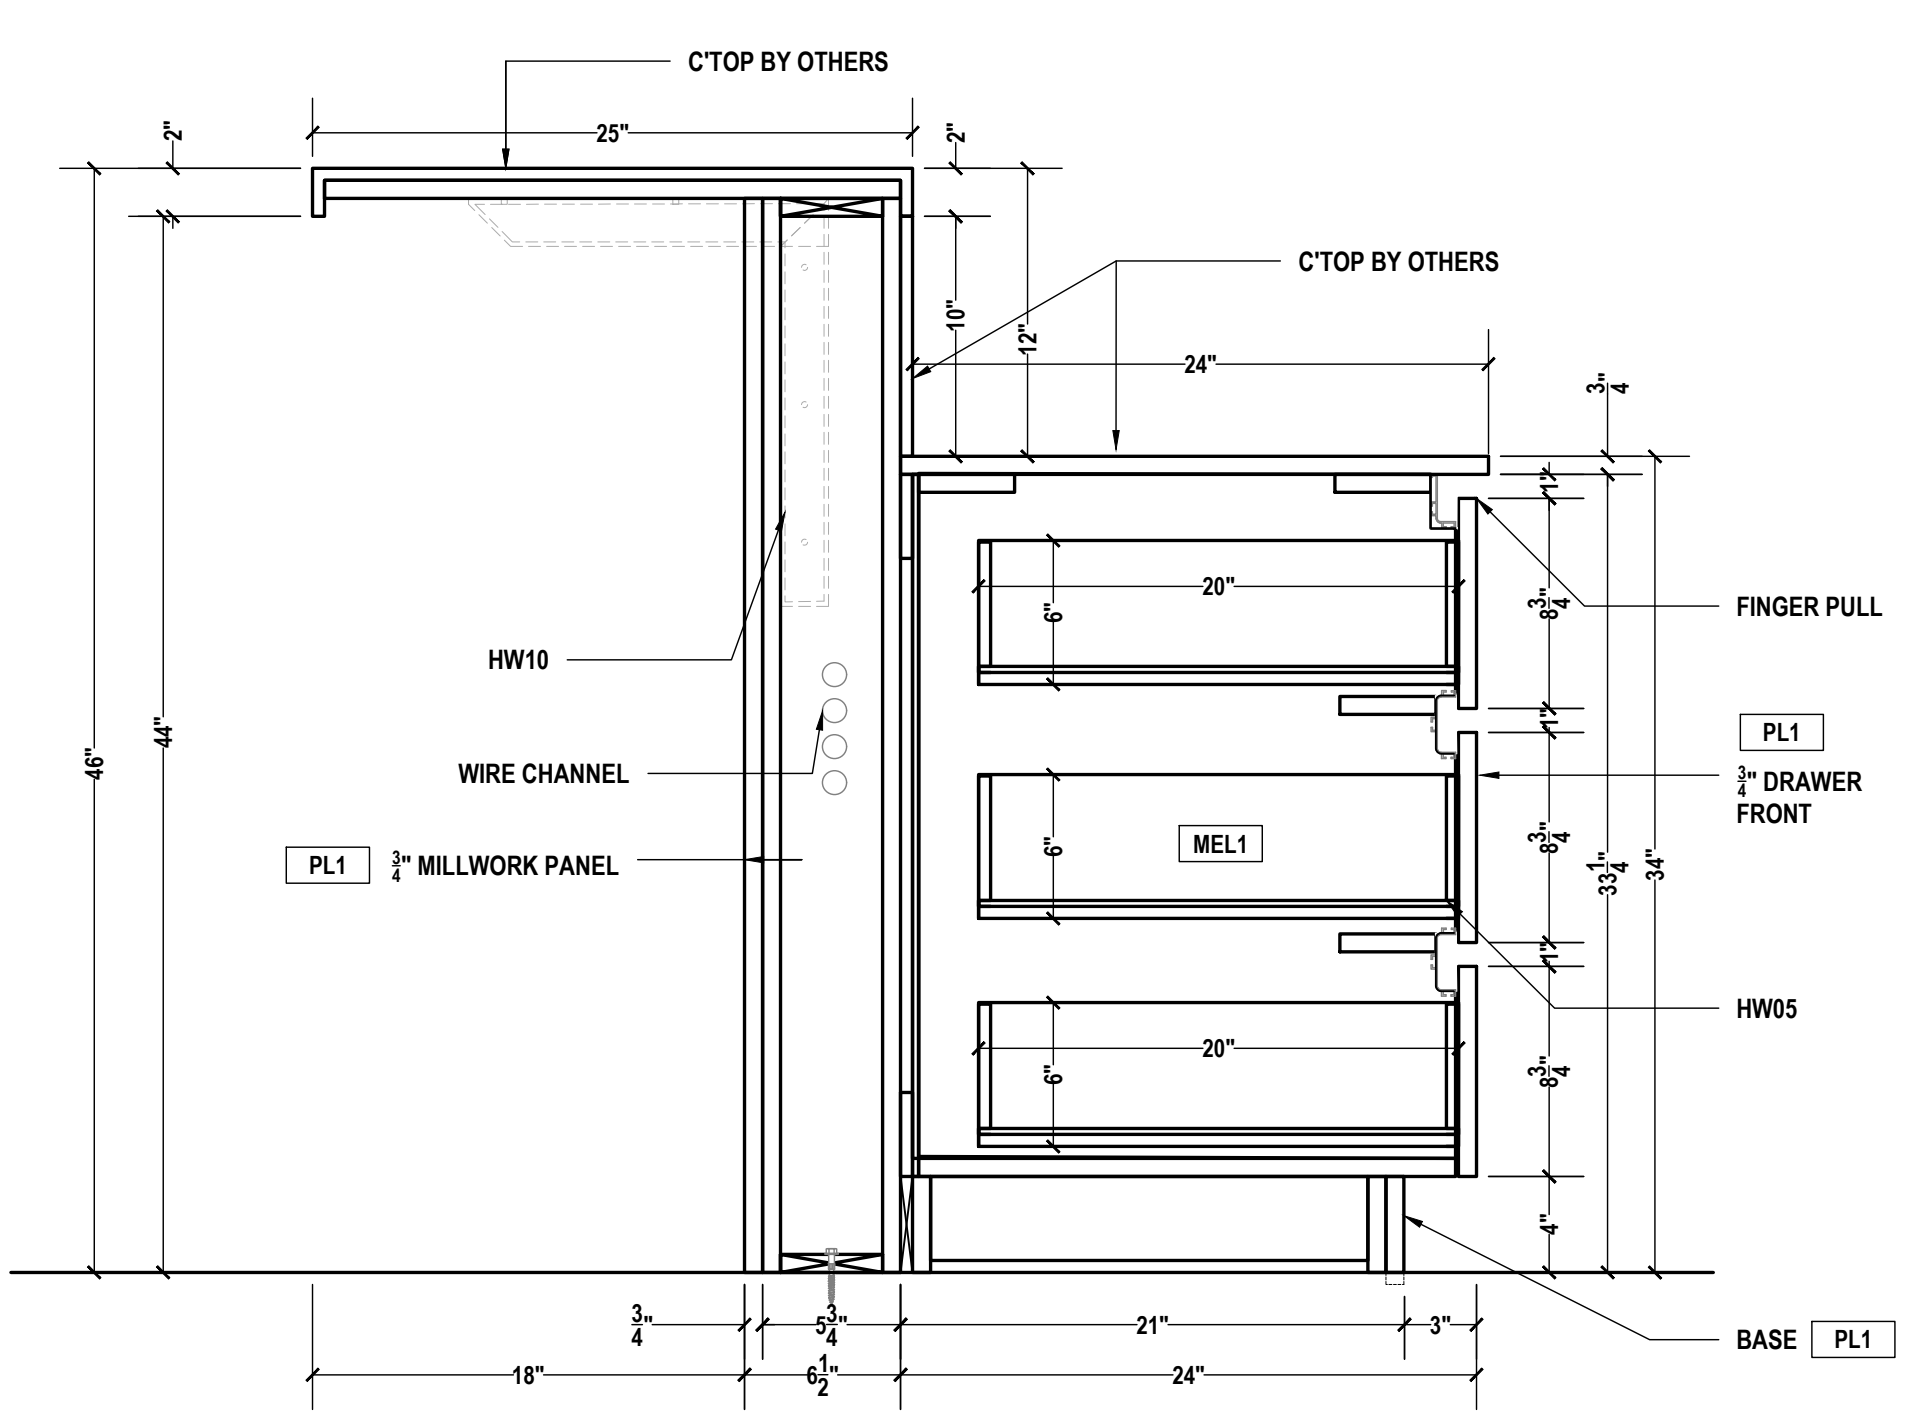

K BREAK ROOM SECTION
SCALE: 1-1/2"=1'-0" ARCH REF.: 20/A605B

PROJECT:
SAMPLE DRAWINGS

PROJECT ADDRESS:
ORANGE AVE, NASHVILLE, TN

ARCHITECT:
FREDDY C.

G.C.:
PAOLO P.

	QCP	YES <input checked="" type="checkbox"/>	NO <input type="checkbox"/>
	LEED	YES <input type="checkbox"/>	NO <input checked="" type="checkbox"/>
	FSC	YES <input type="checkbox"/>	NO <input checked="" type="checkbox"/>
	NAUF	YES <input type="checkbox"/>	NO <input checked="" type="checkbox"/>

FINISHES:


PLASTIC LAMINATE	
KEY	COLOR
PL1	CARBON, TRUMATTE, BLACK
STONE	
KEY	COLOR
ST1	CAESARSTONE 5121 LAYATILE
INTERIOR FINISHES	
KEY	COLOR
MEL1	WHITE MELAMINE

PM:	ERW
DRAWN BY:	TMS
DATE DRAWN:	02/10/2023
REVIEWED BY:	LCT (LOC)


REVISIONS:

No.	DATE:	DESCRIPTIONS:	BY:
△	-	-	-
△	-	-	-
△	-	-	-
△	-	-	-
△	-	-	-
△	-	-	-
△	-	-	-
△	-	-	-
△	-	#	-

APPROVAL DATE	-
PLOT DATE	07/11/2024
PROJECT NUMBER	P-5567446
ROOM NAME	BREAK ROOM A204
SHEET NUMBER	105.09

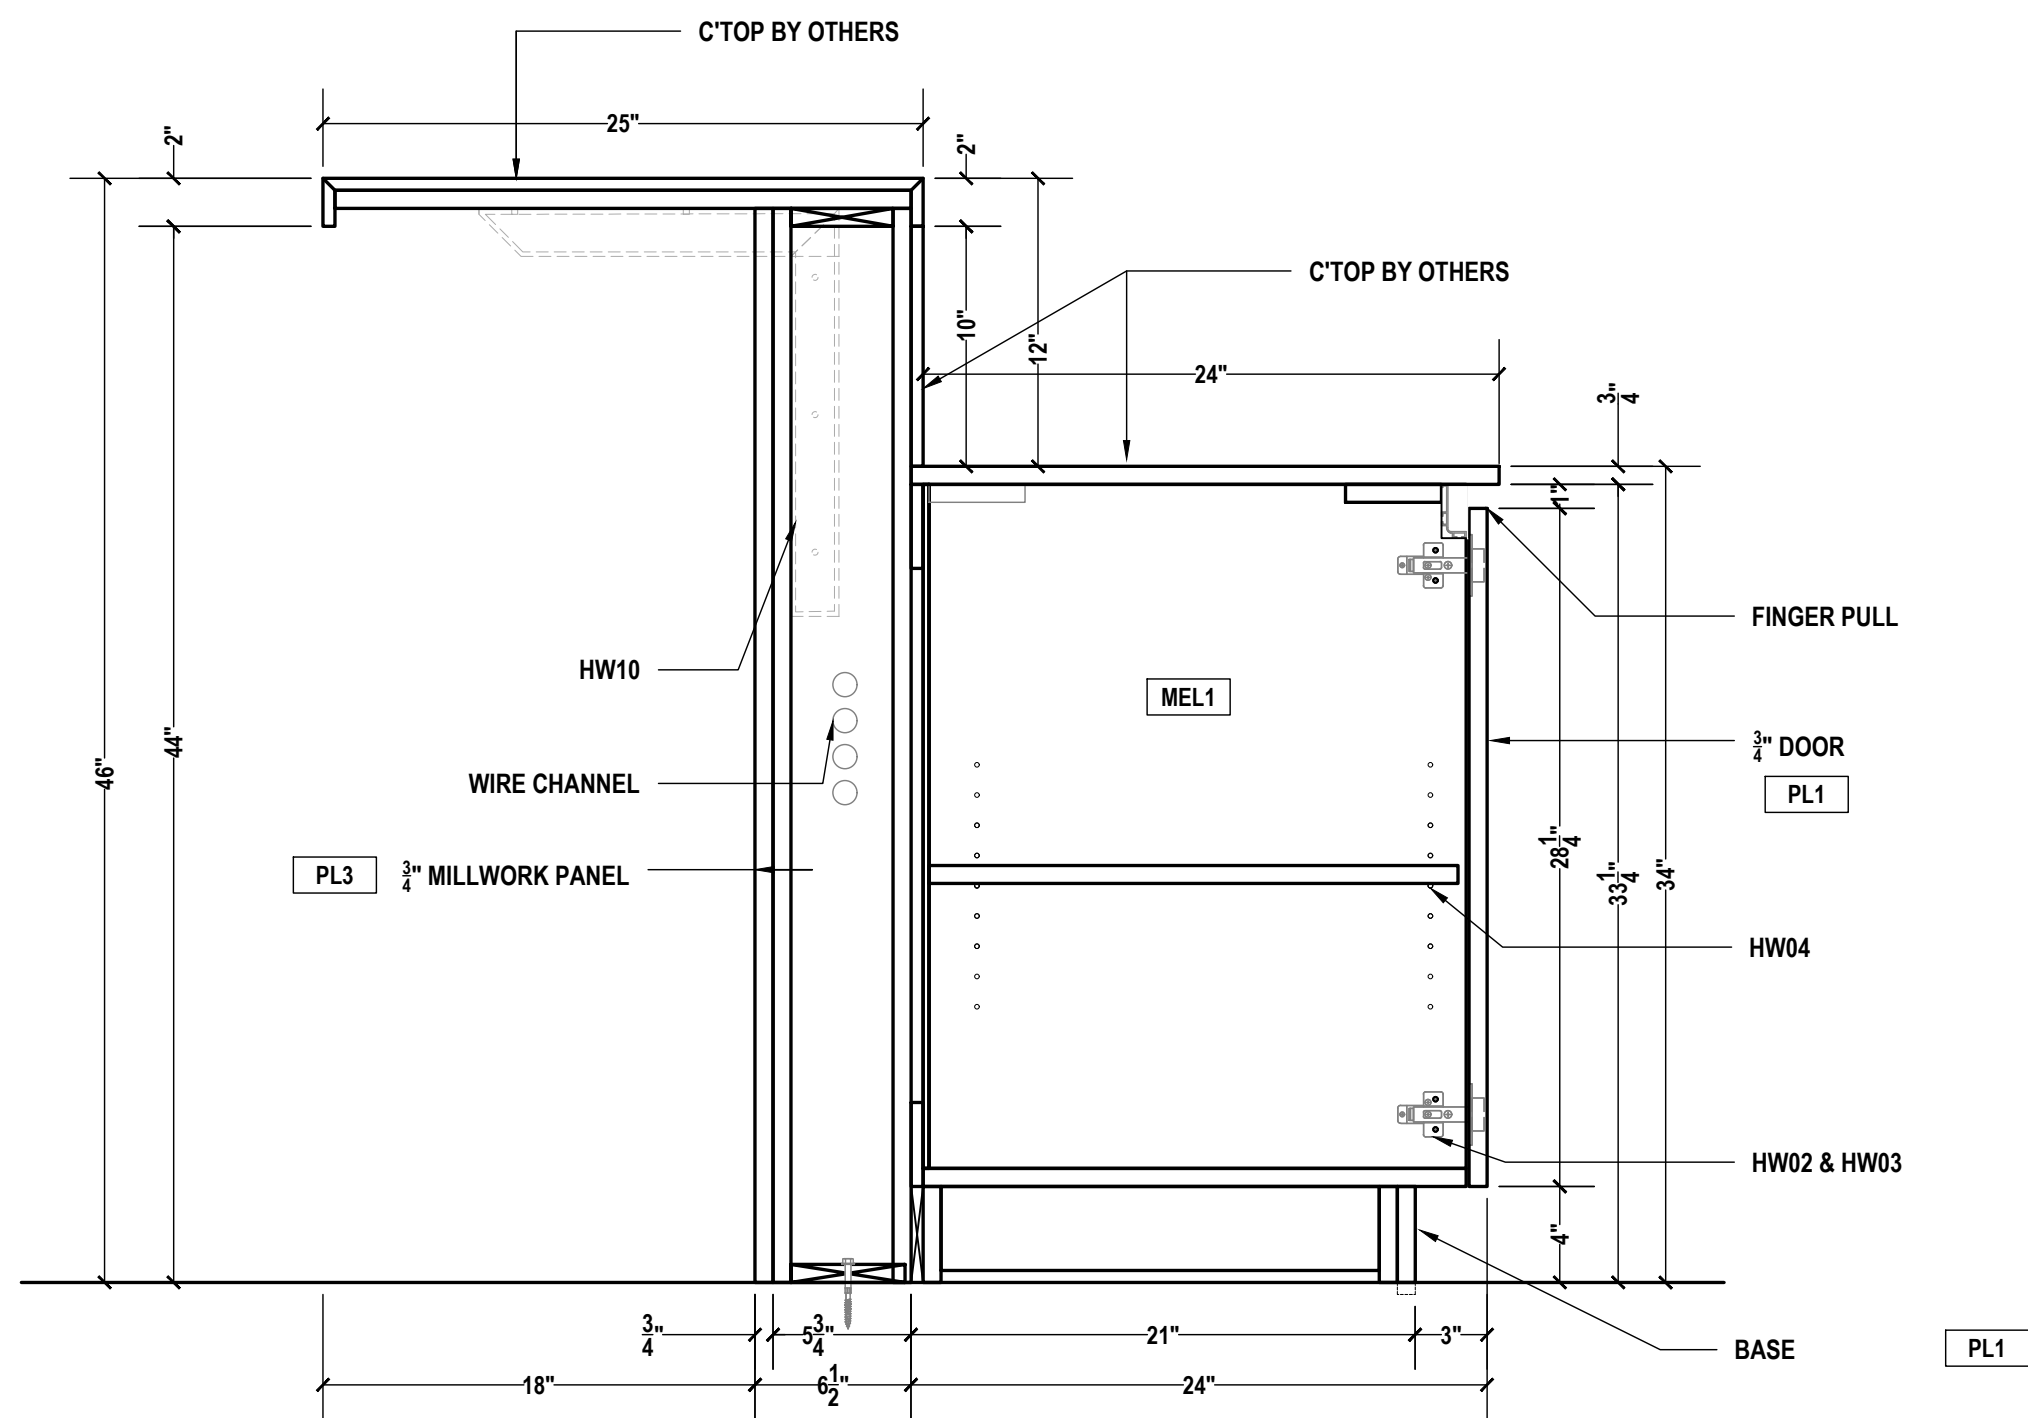

M BREAK ROOM SECTION
SCALE: 1-1/2"=1'-0" ARCH REF.: 22/A605B

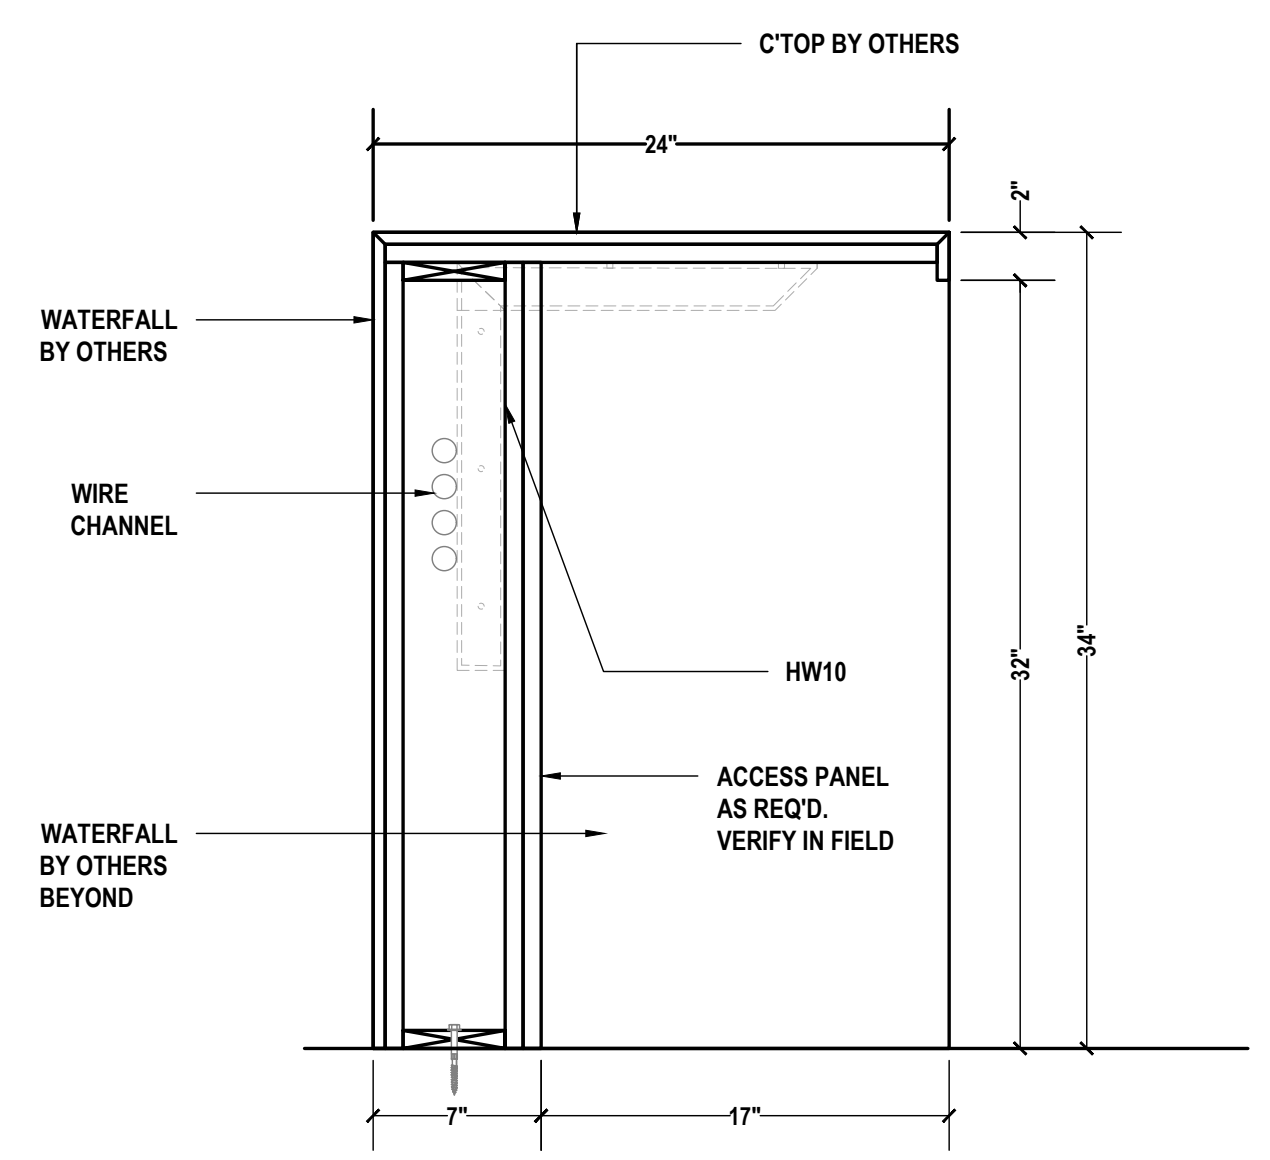

L BREAK ROOM SECTION
SCALE: 1-1/2"=1'-0" ARCH REF.: 21/A605B

PROJECT:
SAMPLE DRAWINGS

PROJECT ADDRESS:
ORANGE AVE, NASHVILLE, TN

ARCHITECT:
FREDDY C.

G.C.:
PAOLO P.

	QCP	YES <input checked="" type="checkbox"/>	NO <input type="checkbox"/>
	LEED	YES <input type="checkbox"/>	NO <input checked="" type="checkbox"/>
	FSC	YES <input type="checkbox"/>	NO <input checked="" type="checkbox"/>
	NAUF	YES <input type="checkbox"/>	NO <input checked="" type="checkbox"/>

FINISHES:


PLASTIC LAMINATE	
KEY	COLOR
PL1	CARBON, TRUMATTE, BLACK
STONE	
KEY	COLOR
ST1	CAESARSTONE 5121 LAYATILE
INTERIOR FINISHES	
KEY	COLOR
MEL1	WHITE MELAMINE

PM:	ERW
DRAWN BY:	TMS
DATE DRAWN:	02/10/2023
REVIEWED BY:	LCT (LOC)


REVISIONS:

No.	DATE	DESCRIPTIONS	BY:
△	-	-	-
△	-	-	-
△	-	-	-
△	-	-	-
△	-	-	-
△	-	-	-
△	-	-	-
△	-	-	-

APPROVAL DATE	-
PLOT DATE	07/11/2024
PROJECT NUMBER	P-5567446
ROOM NAME	BREAK ROOM A204
SHEET NUMBER	105.10

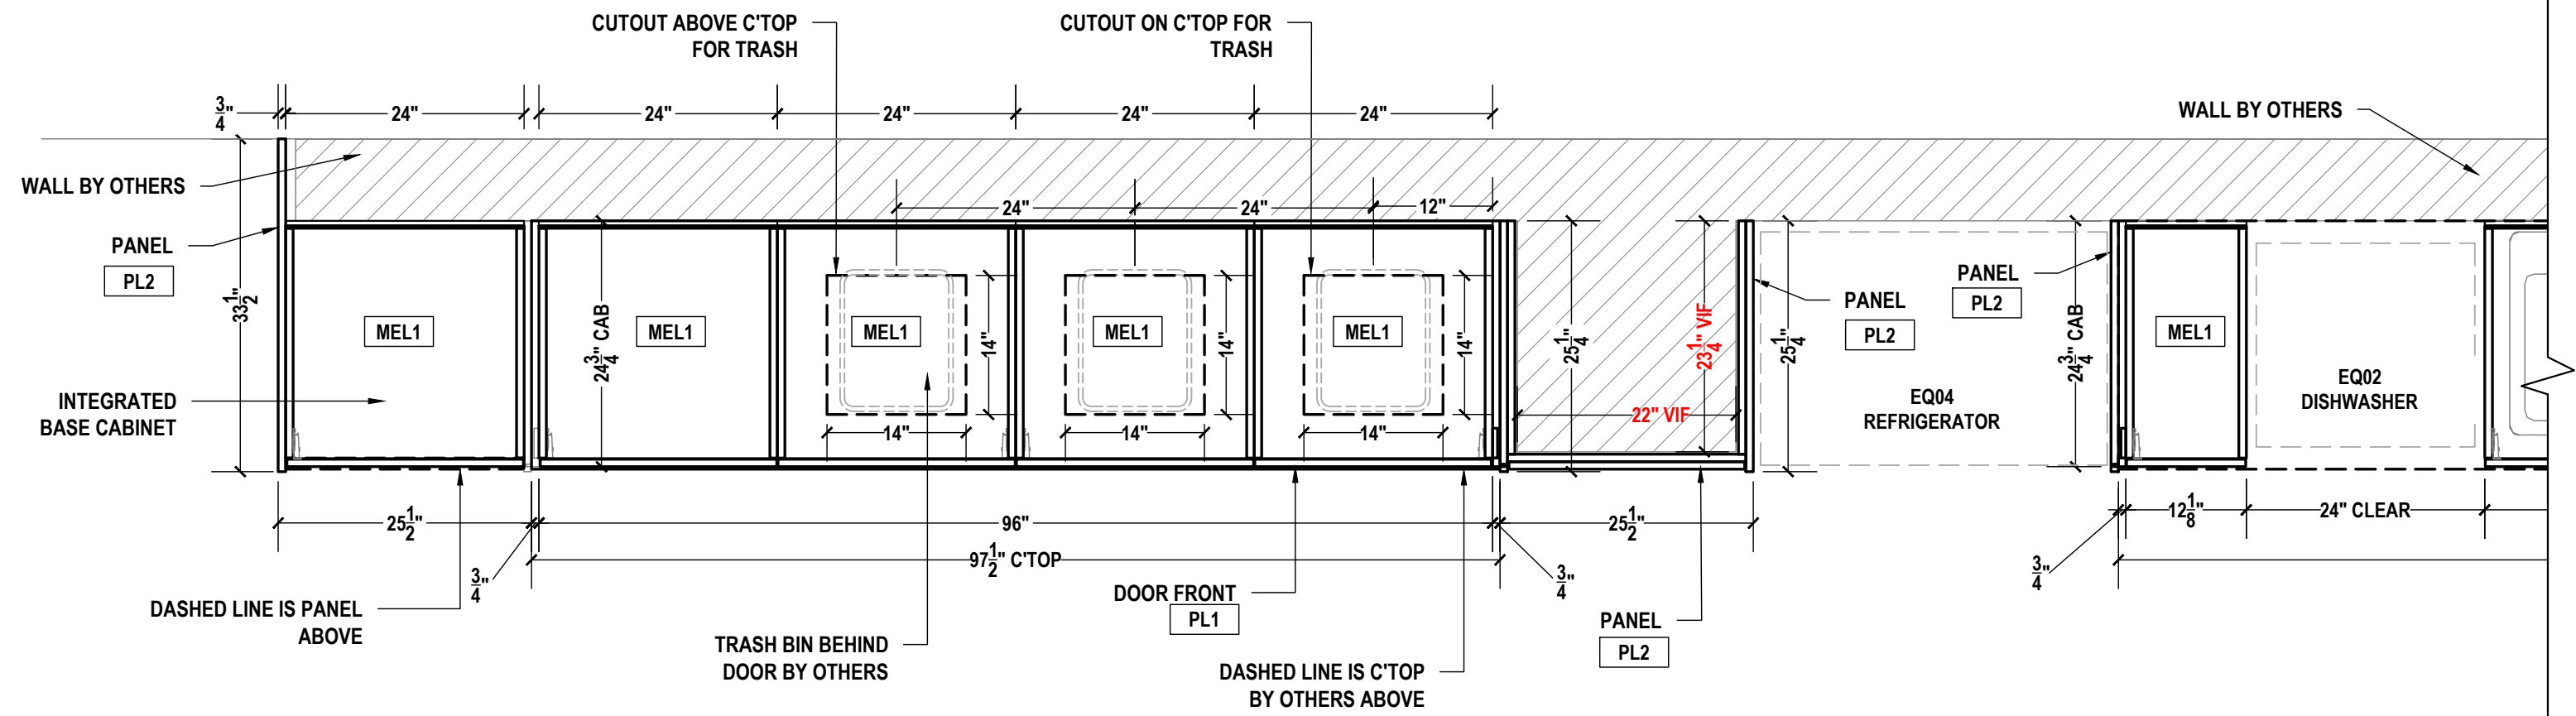

N BREAK ROOM A204
HORIZONTAL SECTION
SCALE: 3/4"=1'-0" ARCH REF.: N/A

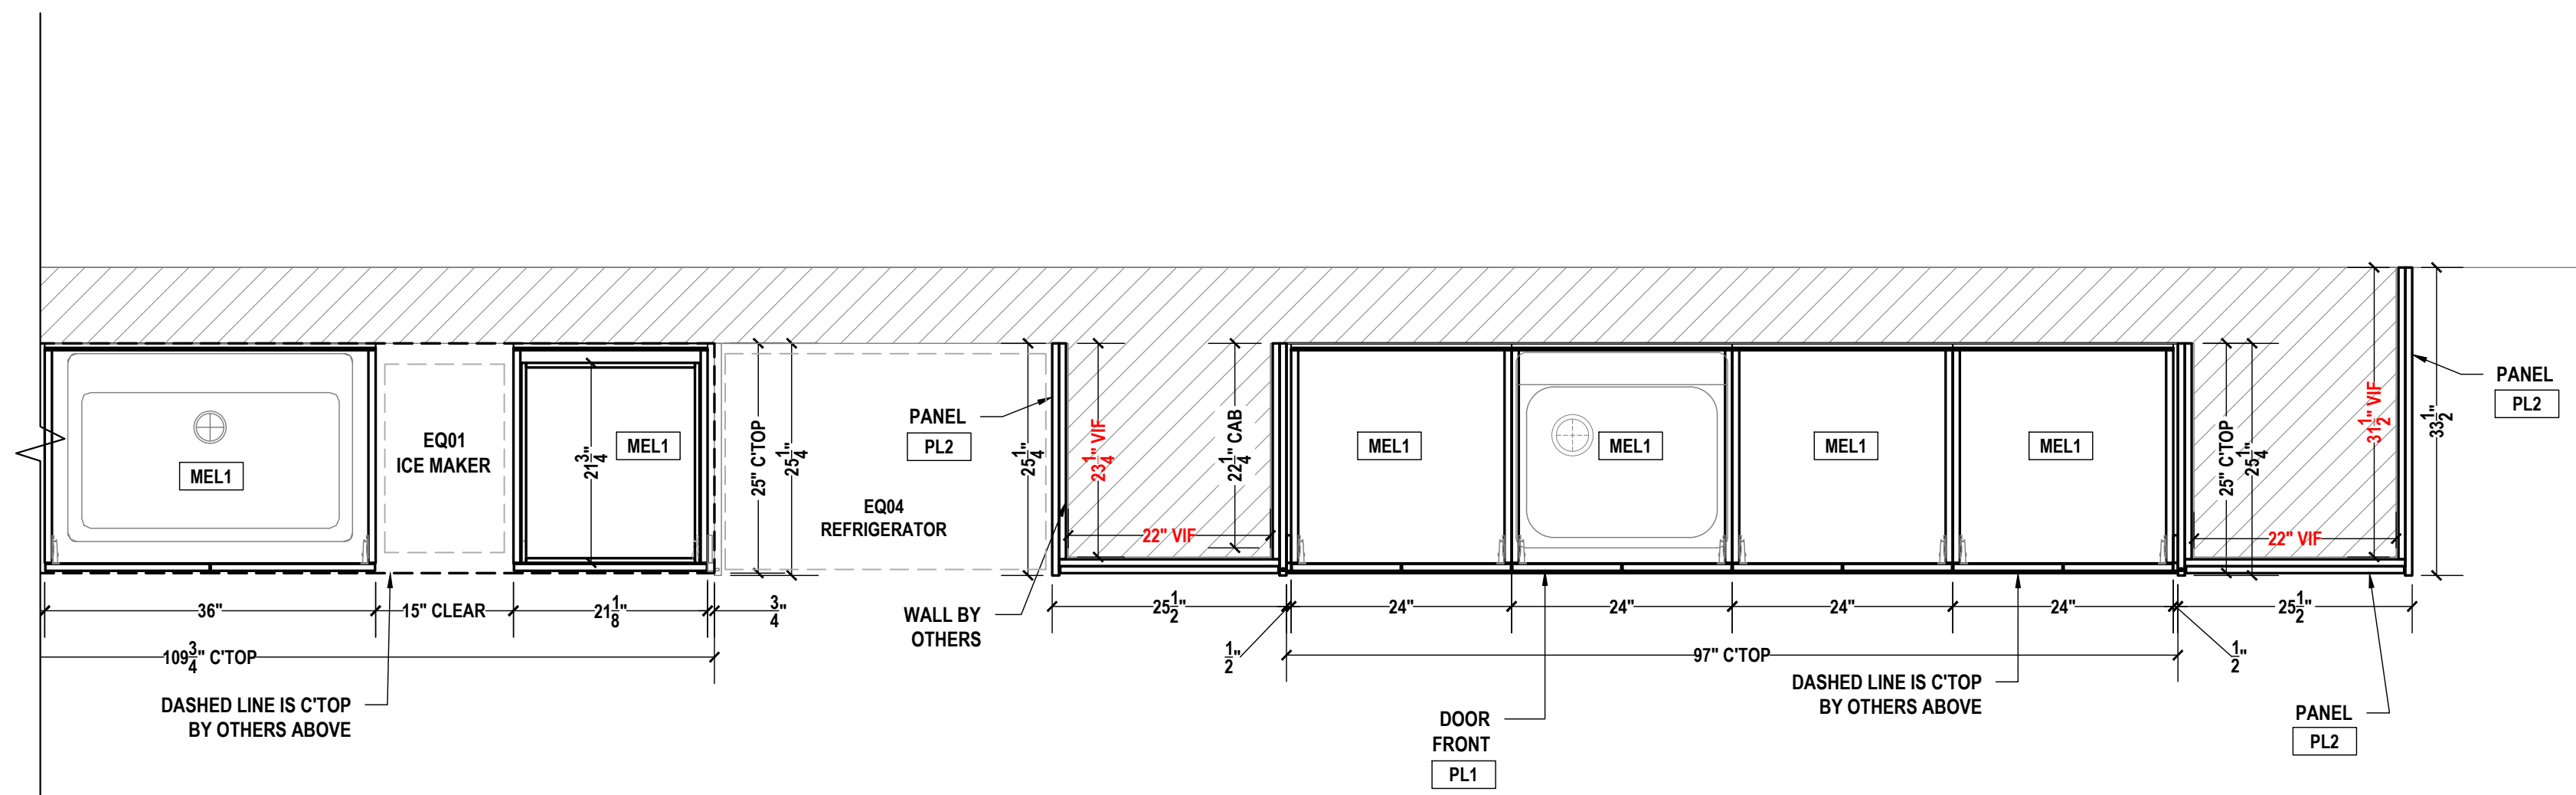

O BREAK ROOM A204
HORIZONTAL SECTION
SCALE: 3/4"=1'-0" ARCH REF.: N/A

PROJECT:
SAMPLE DRAWINGS

PROJECT ADDRESS:
ORANGE AVE, NASHVILLE, TN

ARCHITECT:
FREDDY C.

G.C.:
PAOLO P.

	QCP	YES <input checked="" type="checkbox"/>	NO <input type="checkbox"/>
	LEED	YES <input type="checkbox"/>	NO <input checked="" type="checkbox"/>
	FSC	YES <input type="checkbox"/>	NO <input checked="" type="checkbox"/>
	NAUF	YES <input type="checkbox"/>	NO <input checked="" type="checkbox"/>

FINISHES:


PLASTIC LAMINATE	
KEY	COLOR
PL1	CARBON, TRUMATTE, BLACK
KEY	STONE
KEY	COLOR
ST1	CAESARSTONE 5121 LAYATILE
INTERIOR FINISHES	
KEY	COLOR
MEL1	WHITE MELAMINE

PM:	ERW
DRAWN BY:	TMS
DATE DRAWN:	02/10/2023
REVIEWED BY:	LCT (LOC)


REVISIONS:

No.	DATE	DESCRIPTIONS	BY:
△	-	-	-
△	-	-	-
△	-	-	-
△	-	-	-
△	-	-	-
△	-	-	-
△	-	-	-

APPROVAL DATE	-
PLOT DATE	07/11/2024
PROJECT NUMBER	P-5567446
ROOM NAME	BREAK ROOM A204
SHEET NUMBER	105.11

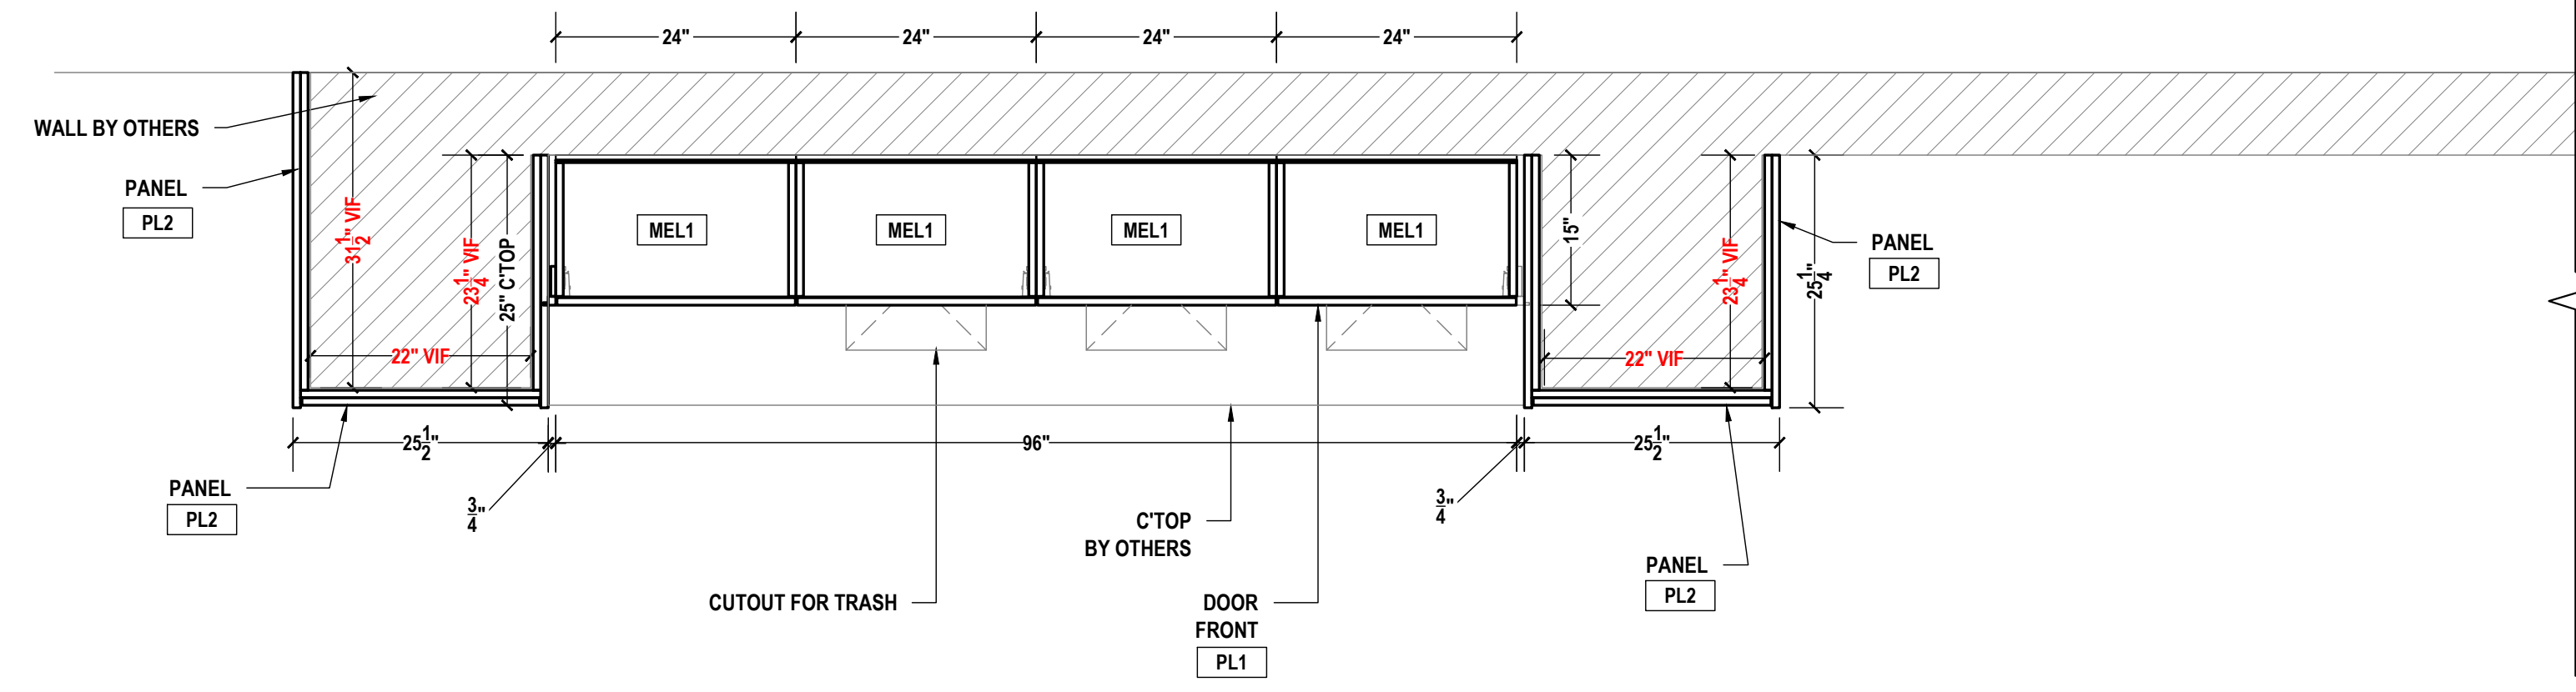

Q BREAK ROOM A204
HORIZONTAL SECTION
SCALE: 3/4"=1'-0" ARCH REF.: N/A

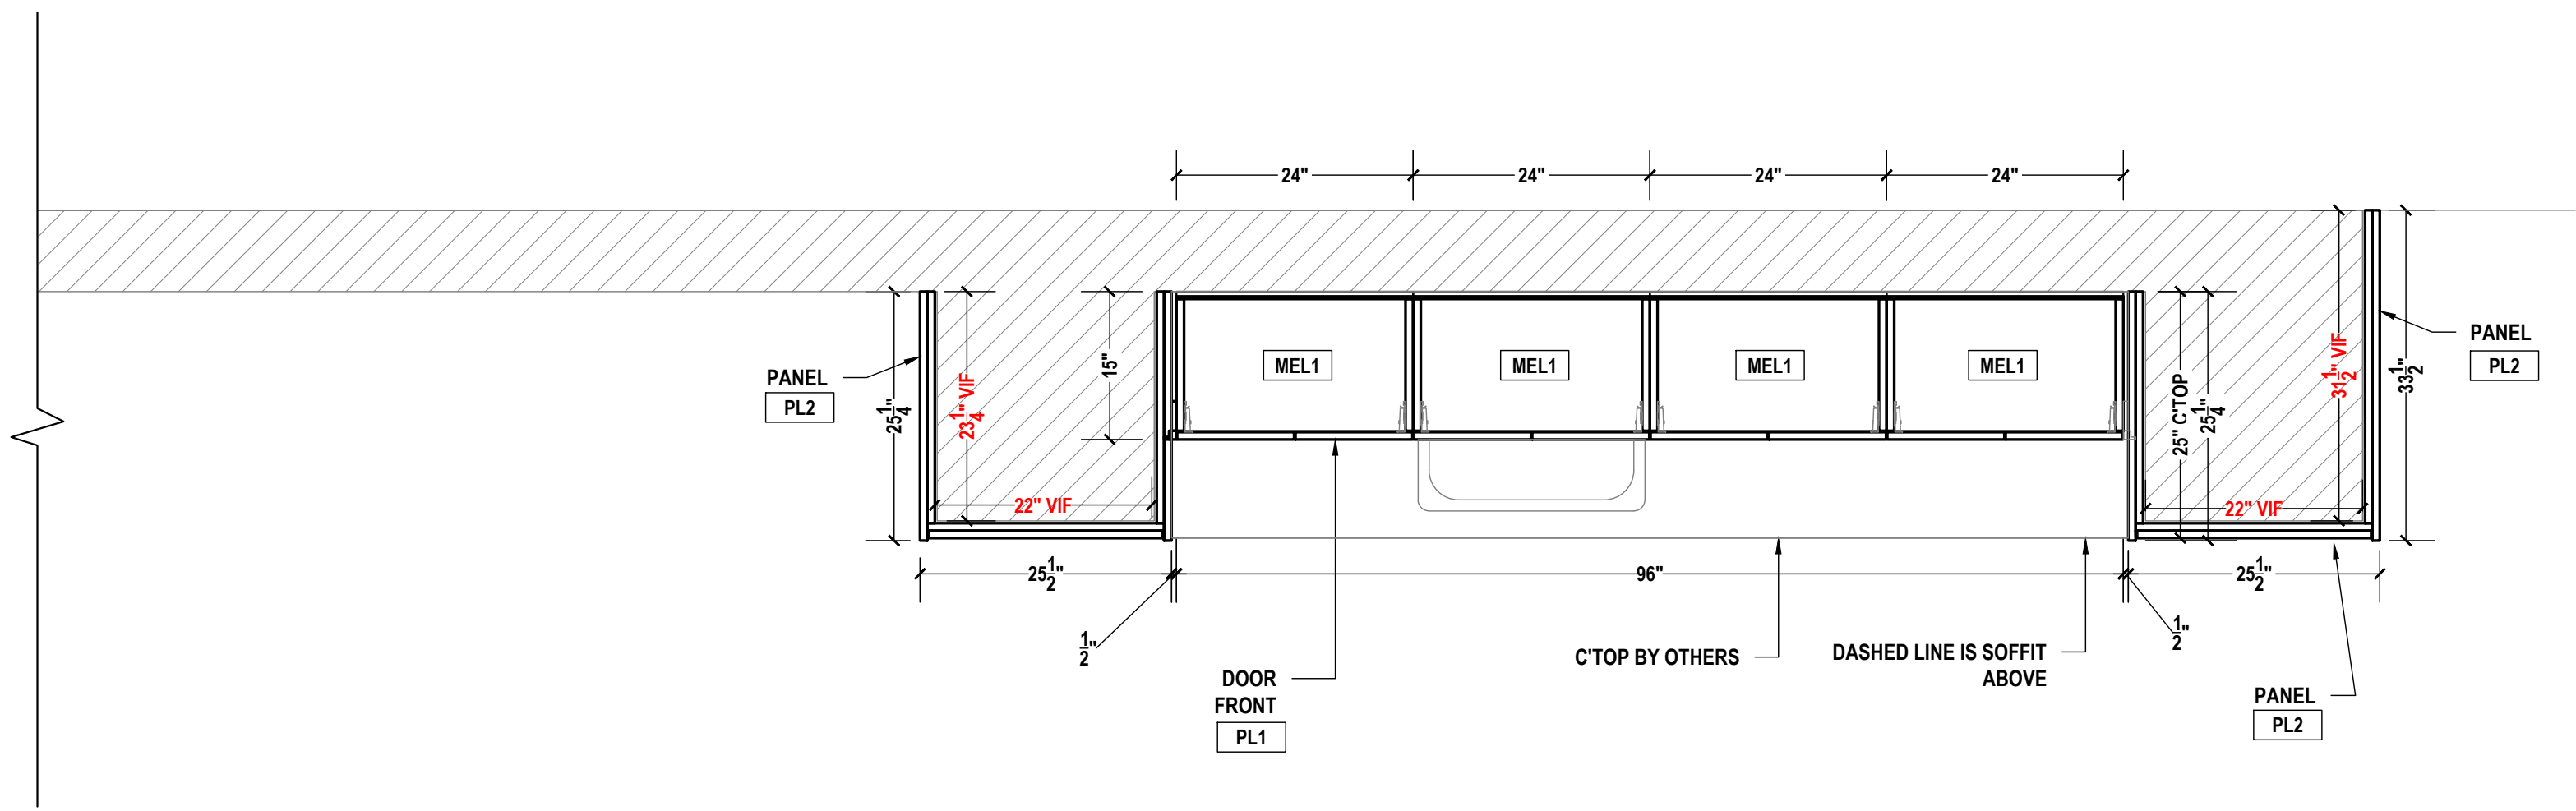

P BREAK ROOM A204
HORIZONTAL SECTION
SCALE: 3/4"=1'-0" ARCH REF.: N/A

PROJECT:
SAMPLE DRAWINGS

PROJECT ADDRESS:
ORANGE AVE, NASHVILLE, TN

ARCHITECT:
FREDDY C.

G.C.:
PAOLO P.

	QCP	YES <input checked="" type="checkbox"/>	NO <input type="checkbox"/>
	LEED	YES <input type="checkbox"/>	NO <input checked="" type="checkbox"/>
	FSC	YES <input type="checkbox"/>	NO <input checked="" type="checkbox"/>
	NAUF	YES <input type="checkbox"/>	NO <input checked="" type="checkbox"/>

FINISHES:


PLASTIC LAMINATE	
KEY	COLOR
PL1	CARBON, TRUMATTE, BLACK
STONE	
KEY	COLOR
ST1	CAESARSTONE 5121 LAYATILE
INTERIOR FINISHES	
KEY	COLOR
MEL1	WHITE MELAMINE

PM:	ERW
DRAWN BY:	TMS
DATE DRAWN:	02/10/2023
REVIEWED BY:	LCT (LOC)

REVISIONS:

No.	DATE	DESCRIPTIONS	BY:
△	-	-	-
△	-	-	-
△	-	-	-
△	-	-	-
△	-	-	-
△	-	-	-
△	-	-	-
△	-	-	-

APPROVAL DATE	-
PLOT DATE	07/11/2024
PROJECT NUMBER	P-5567446
ROOM NAME	BREAK ROOM A204
SHEET NUMBER	105.12

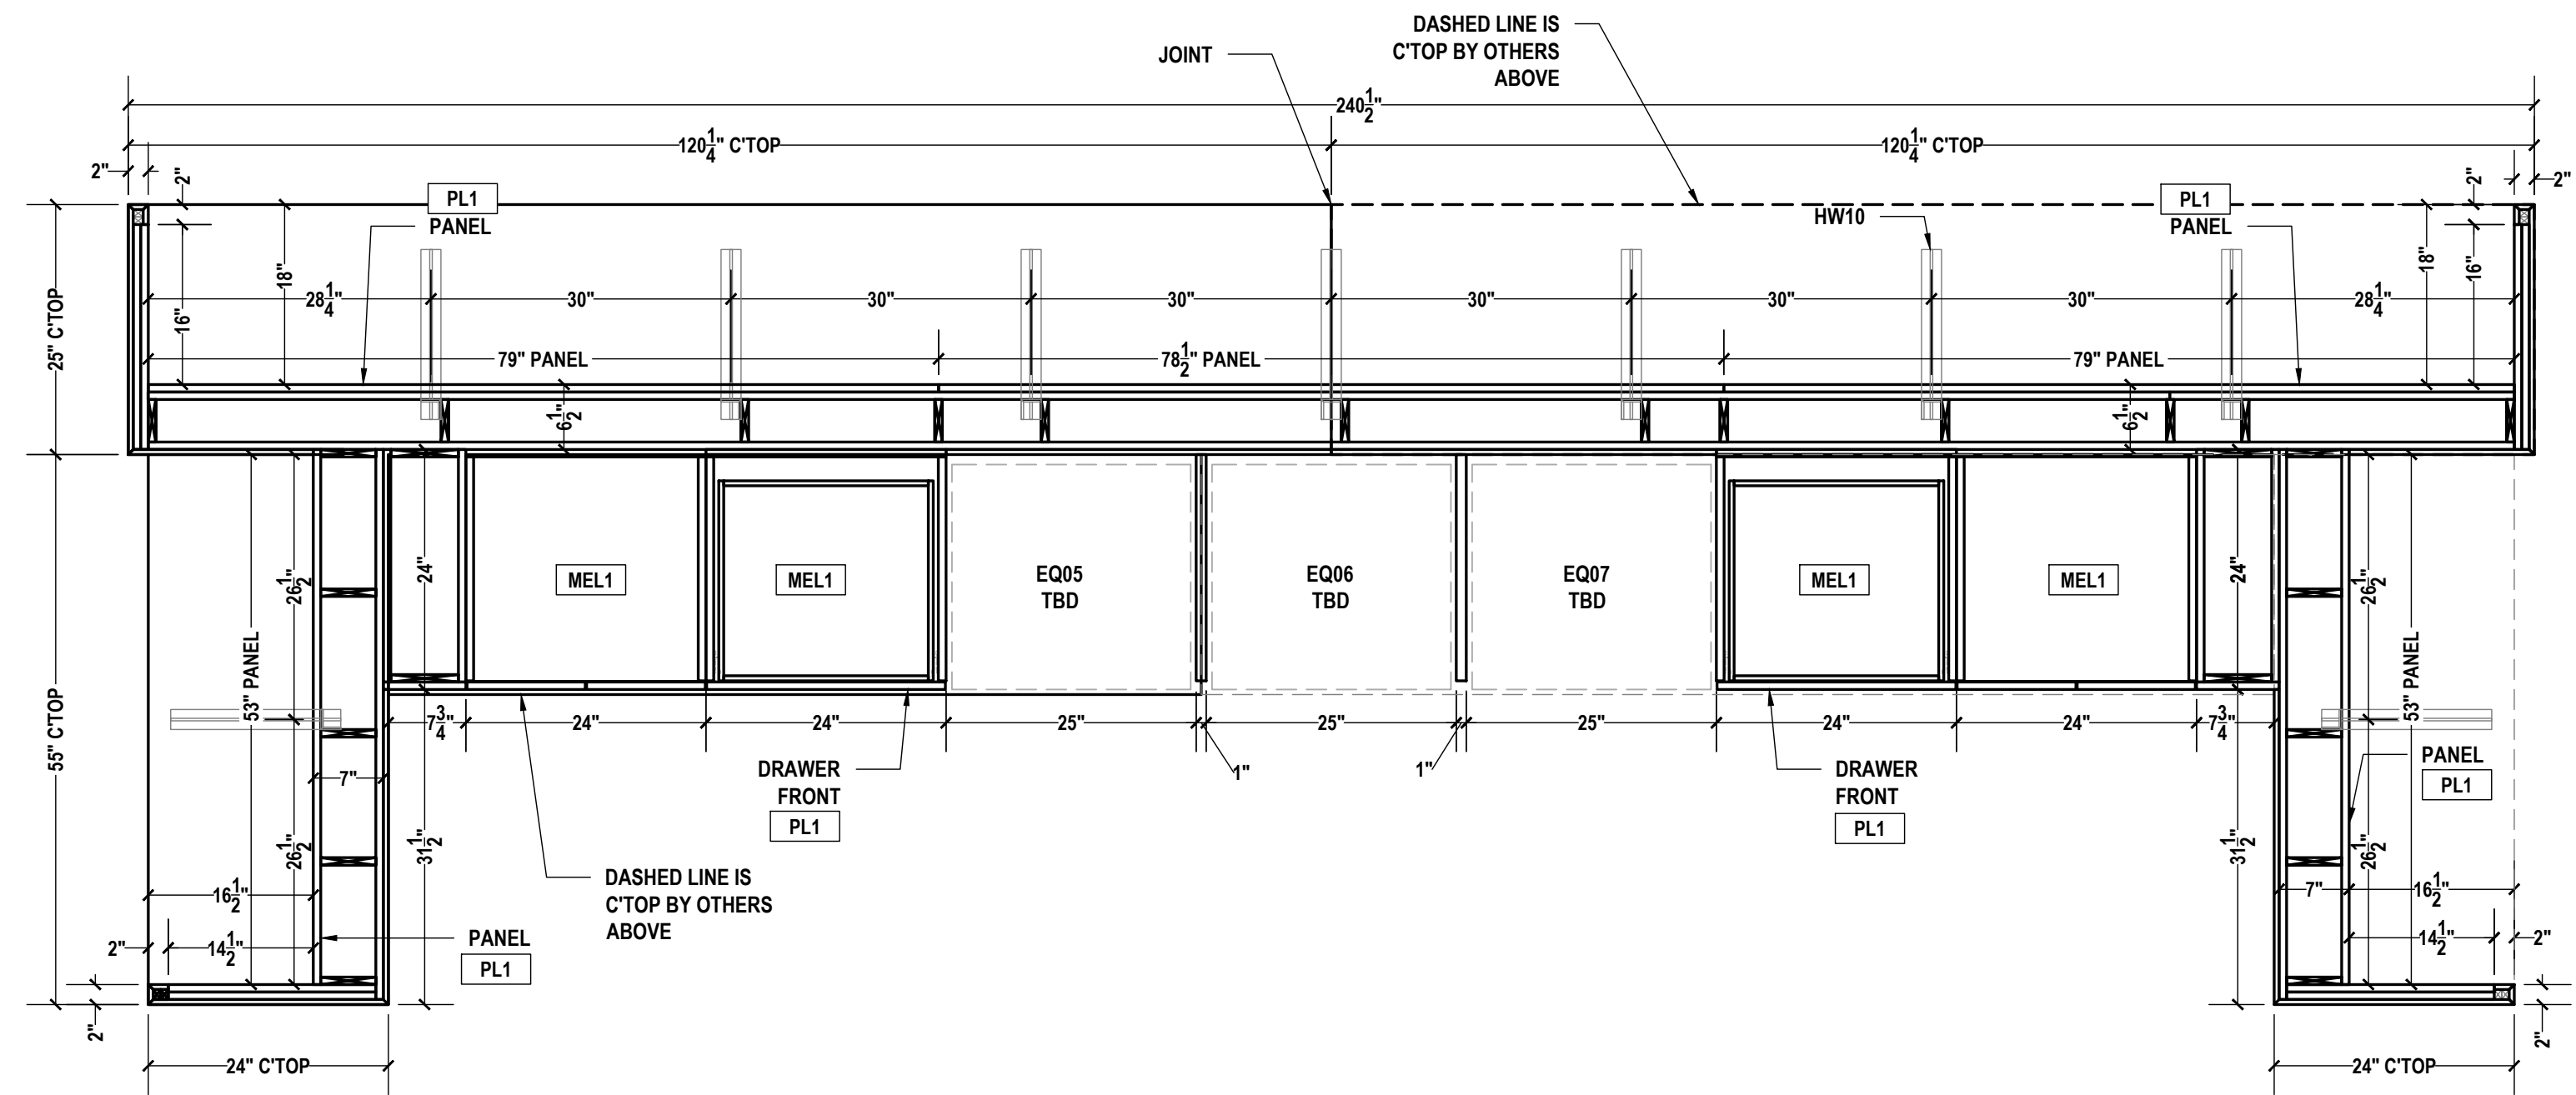

R BREAK ROOM A204
HORIZONTAL SECTION
SCALE: 3/4"=1'-0" ARCH REF.: N/A

PROJECT:
SAMPLE DRAWINGS

PROJECT ADDRESS:
ORANGE AVE, NASHVILLE, TN

ARCHITECT:
FREDDY C.

G.C.:
PAOLO P.

	QCP	YES <input checked="" type="checkbox"/>	NO <input type="checkbox"/>
	LEED	YES <input type="checkbox"/>	NO <input checked="" type="checkbox"/>
	FSC	YES <input type="checkbox"/>	NO <input checked="" type="checkbox"/>
	NAUF	YES <input type="checkbox"/>	NO <input checked="" type="checkbox"/>

FINISHES:


PLASTIC LAMINATE	
KEY	COLOR
PL1	CARBON, TRUMATTE, BLACK
STONE	
KEY	COLOR
ST1	CAESARSTONE 5121 LAYATILE
INTERIOR FINISHES	
KEY	COLOR
MEL1	WHITE MELAMINE

PM:	ERW
DRAWN BY:	TMS
DATE DRAWN:	02/10/2023
REVIEWED BY:	LCT (LOC)


REVISIONS:

No.	DATE	DESCRIPTIONS	BY:
△	-	-	-
△	-	-	-
△	-	-	-
△	-	-	-
△	-	-	-
△	-	-	-
△	-	-	-
△	-	-	-

APPROVAL DATE	-
PLOT DATE	07/11/2024
PROJECT NUMBER	P-5567446
ROOM NAME	BREAK ROOM A204
SHEET NUMBER	105.13

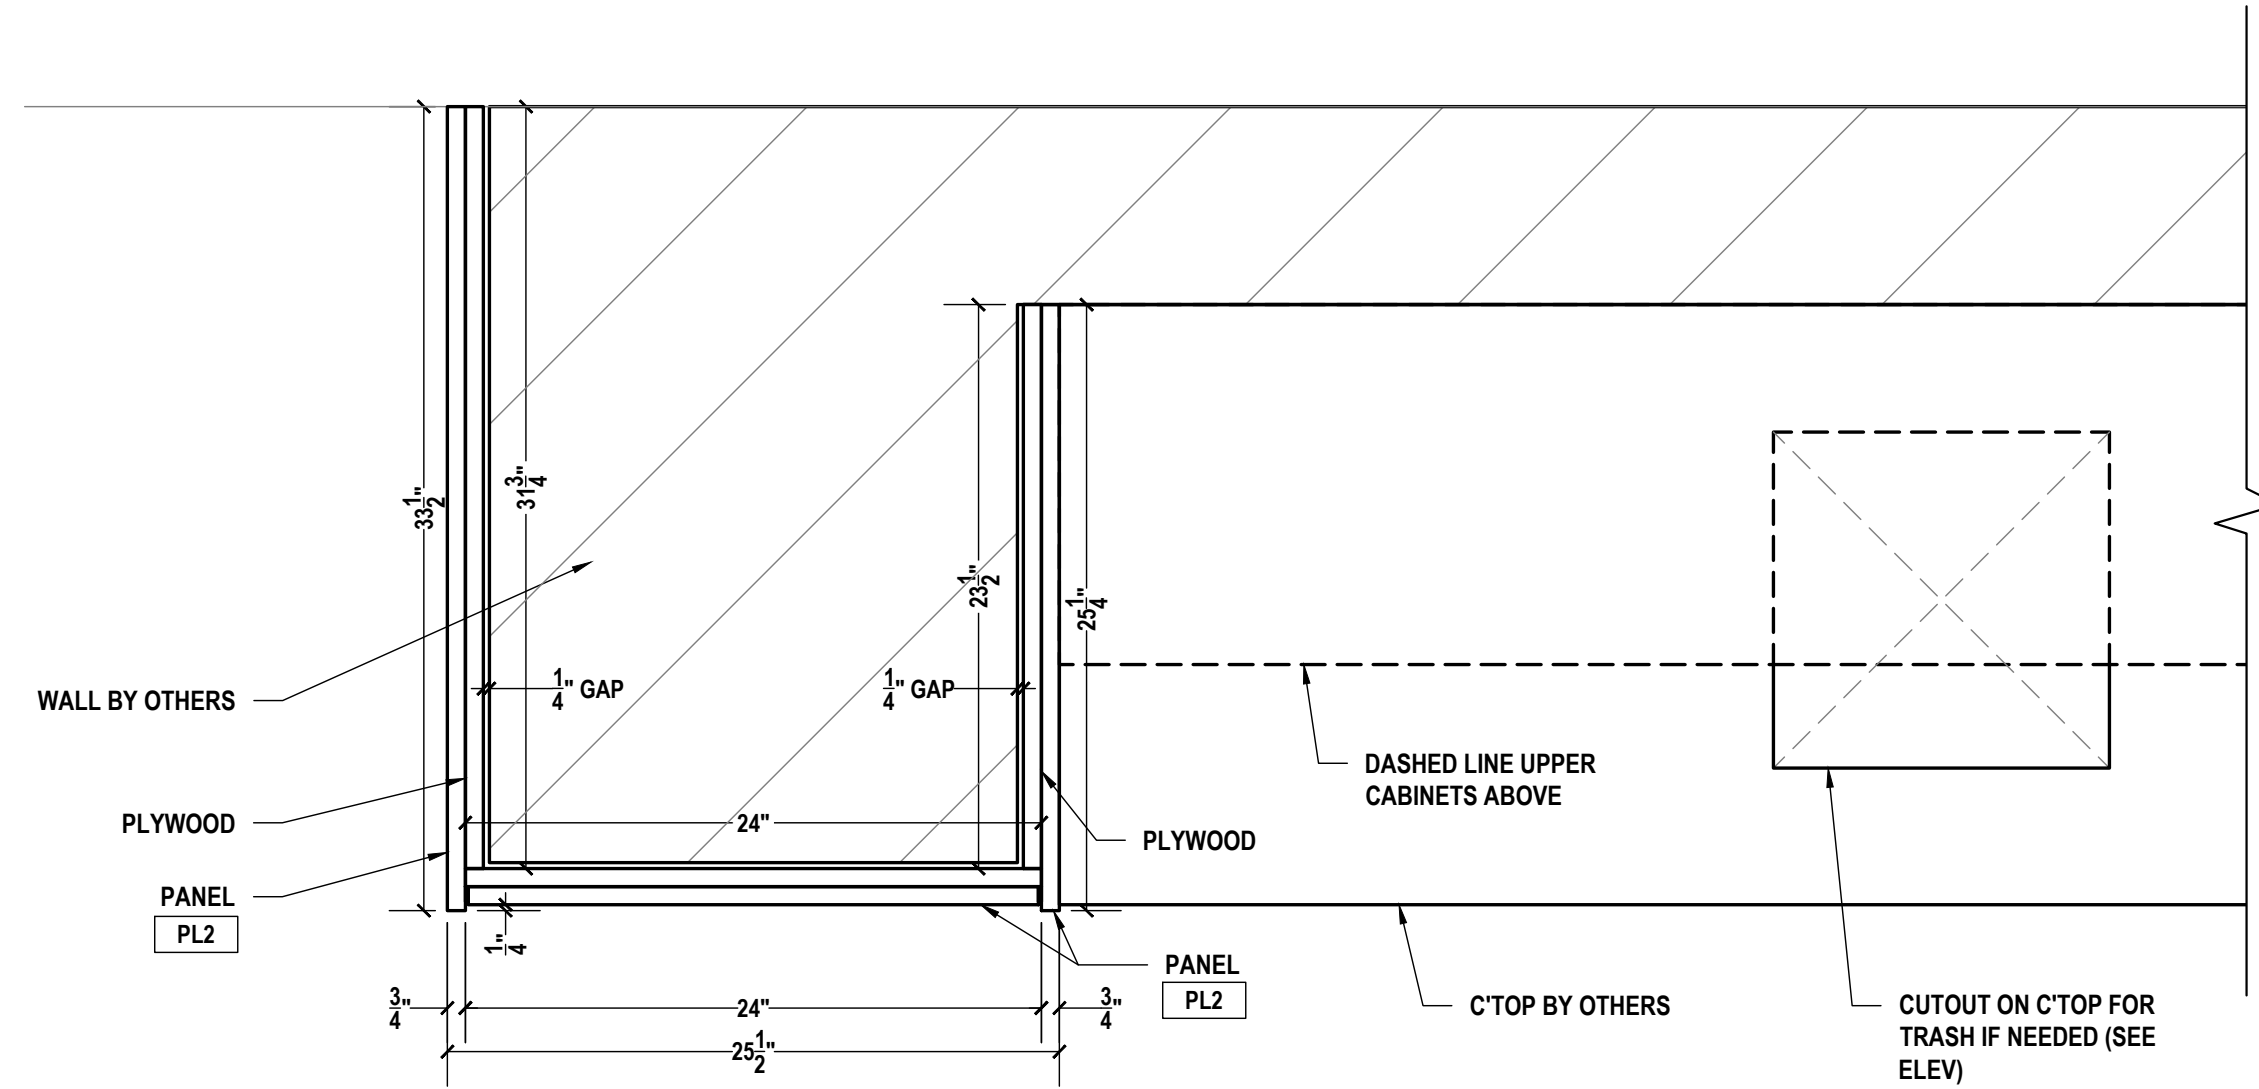

S BREAK ROOM HORIZONTAL SECTION
SCALE: 1-1/2"=1'-0" ARCH REF.: 23/A605B

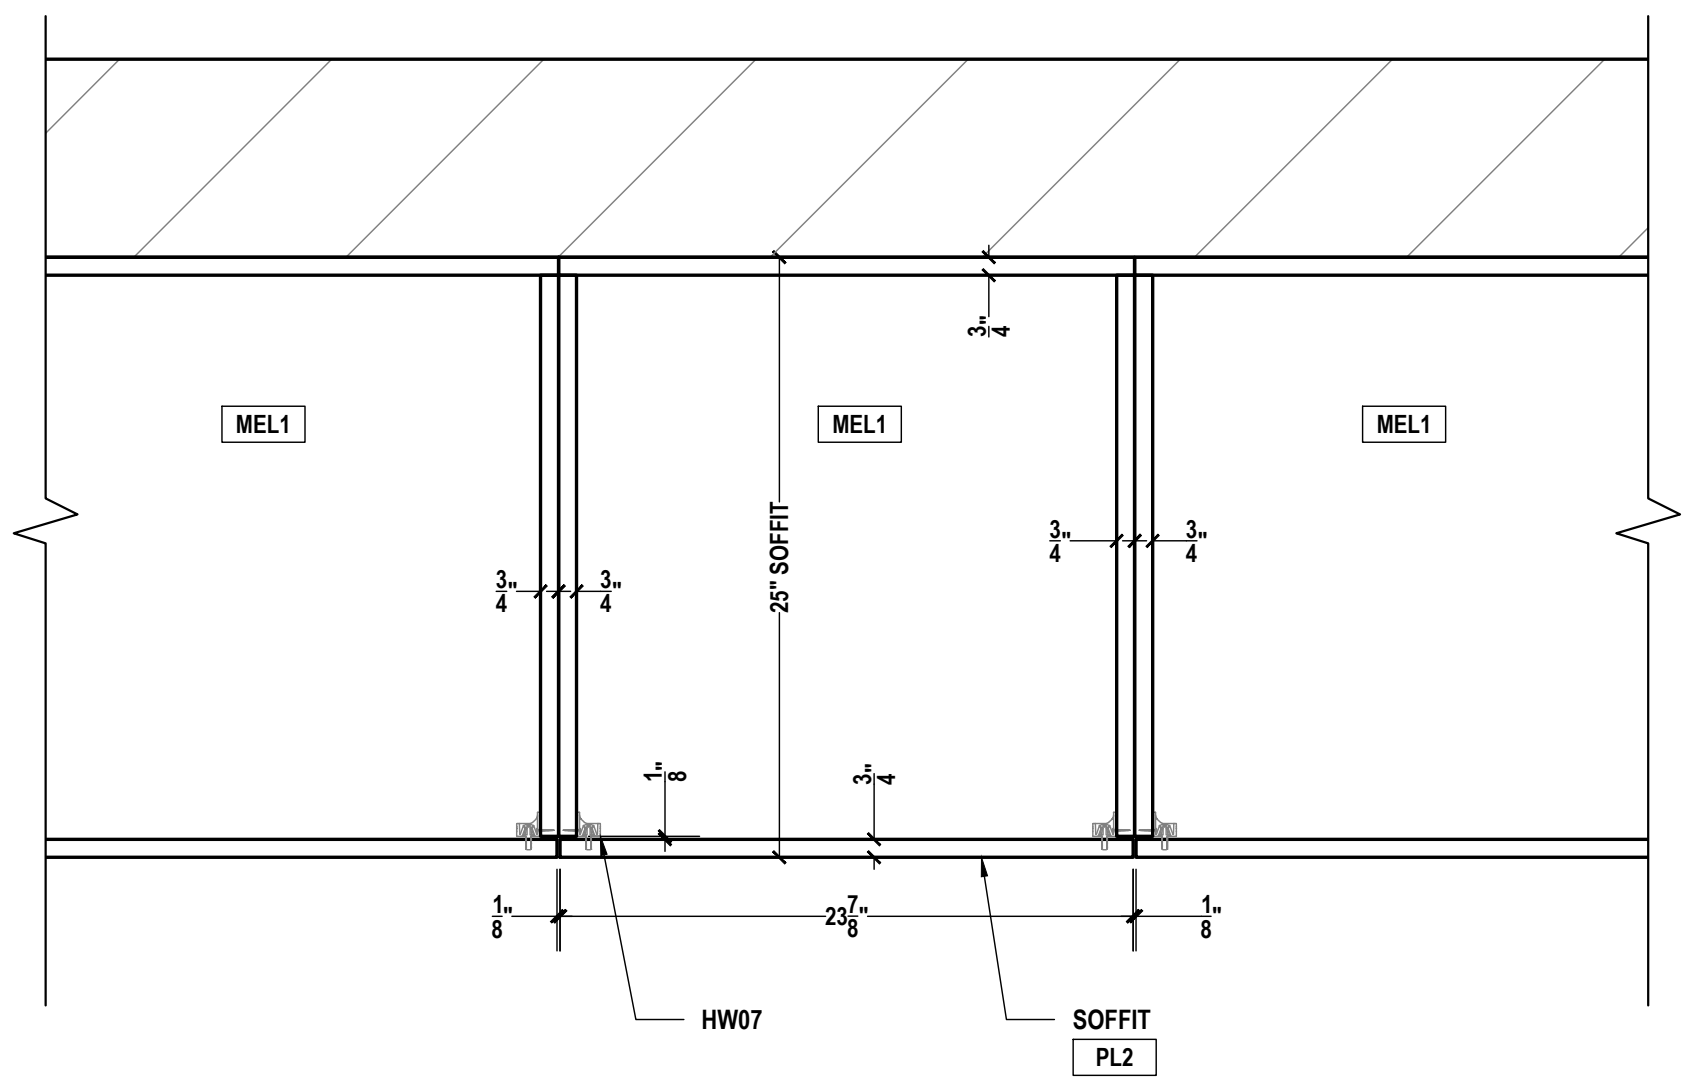

T BREAK ROOM HORIZONTAL SECTION
SCALE: 1-1/2"=1'-0" ARCH REF.: 24/A605B

PROJECT:
SAMPLE DRAWINGS

PROJECT ADDRESS:
ORANGE AVE, NASHVILLE, TN

ARCHITECT:
FREDDY C.

G.C.:
PAOLO P.

	QCP	YES <input checked="" type="checkbox"/>	NO <input type="checkbox"/>
	LEED	YES <input type="checkbox"/>	NO <input checked="" type="checkbox"/>
	FSC	YES <input type="checkbox"/>	NO <input checked="" type="checkbox"/>
	NAUF	YES <input type="checkbox"/>	NO <input checked="" type="checkbox"/>

FINISHES:


PLASTIC LAMINATE	
KEY	COLOR
PL1	CARBON, TRUMATTE, BLACK
STONE	
KEY	COLOR
ST1	CAESARSTONE 5121 LAYATILE
INTERIOR FINISHES	
KEY	COLOR
MEL1	WHITE MELAMINE

PM:	ERW
DRAWN BY:	TMS
DATE DRAWN:	02/10/2023
REVIEWED BY:	LCT (LOC)

REVISIONS:

No.	DATE	DESCRIPTIONS	BY:
△	-	-	-
△	-	-	-
△	-	-	-
△	-	-	-
△	-	-	-
△	-	-	-
△	-	-	-
△	-	#	-

APPROVAL DATE	-
PLOT DATE	07/11/2024
PROJECT NUMBER	P-5567446
ROOM NAME	BREAK ROOM A204
SHEET NUMBER	105.14

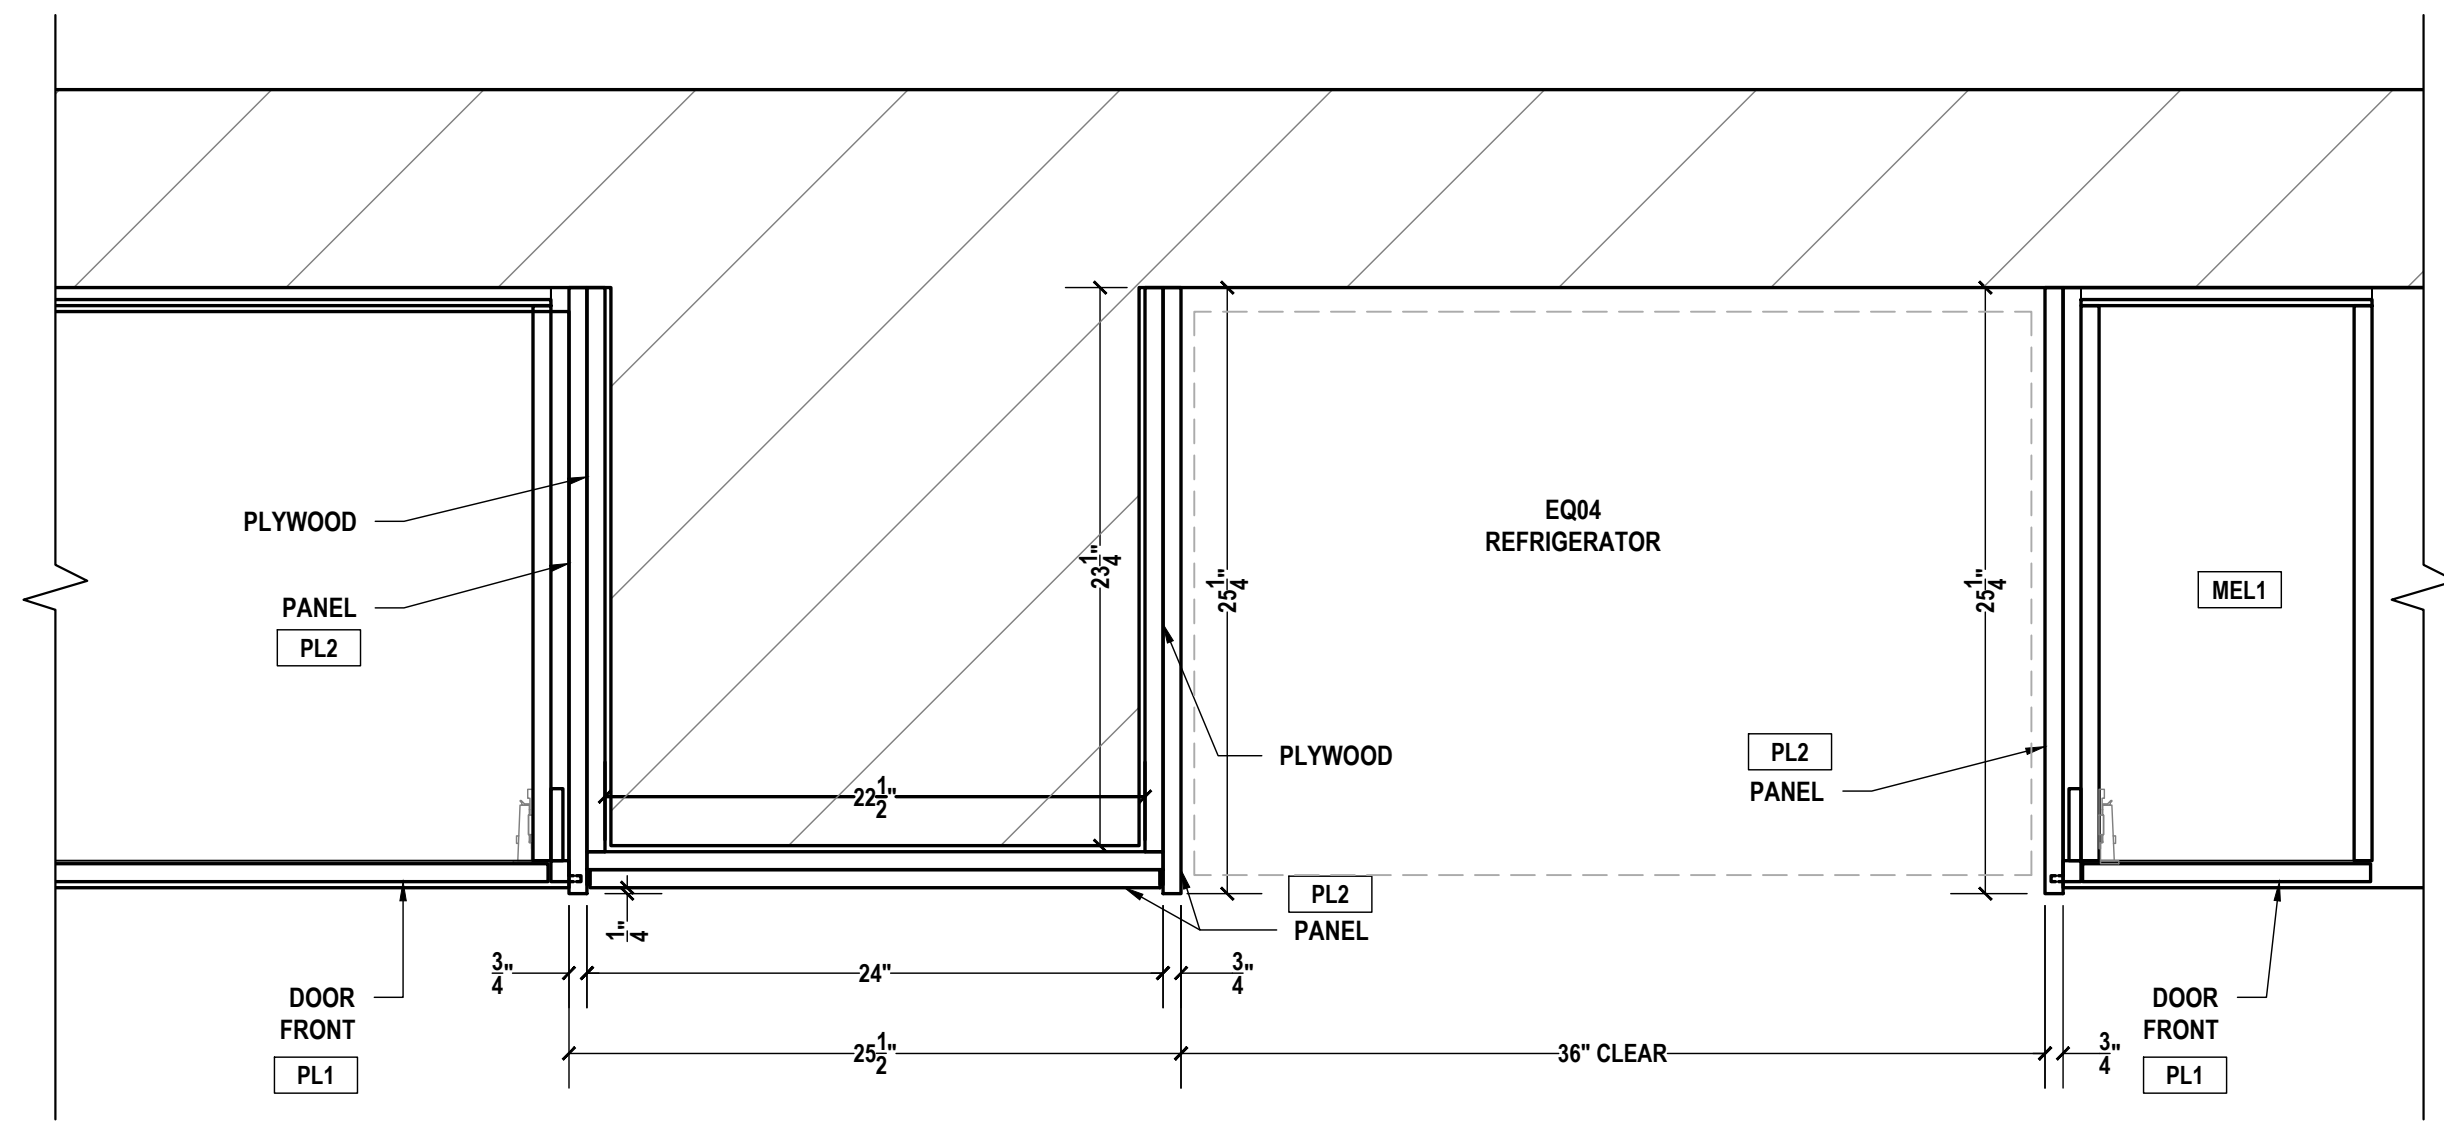

U BREAK ROOM
HORIZONTAL SECTION
SCALE: 1-1/2"=1'-0" ARCH REF.: 25/A605B